




Spencer Bristol Engineering, Inc.
2880 Lee Oak Parkway NW, Suite 110
Atlanta, Georgia 30329
Tel: 770.441.6228 Fax: 770.441.6224
SEE Project No. 00036

PRECISION PLANNING, INC. © 2008 ALL RIGHTS RESERVED.		THIS DOCUMENT IS UNCLASSIFIED AND PERMITTED FOR RELEASE IN WHOLE OR IN PART, AND REPRODUCIBILITY OF SERVICES AND THE SOLE PROPERTY OF PRECISION PLANNING, INC. UNLESS OTHERWISE AGREED TO, THIS SHALL NOT BE REPRODUCED OR COPIED FOR ANY PURPOSE WITHOUT THE WRITTEN CONSENT OF PRECISION PLANNING, INC. ANY OTHER PROJECTS SHOWN SHALL NOT NECESSARILY INDICATE REVENUE WITHOUT THE WRITTEN PERMISSION FROM PRECISION PLANNING, INC.	
STAMP		PRECISION PLANNING, INC. Planners, engineers, architects & surveyors P.O. Box 2210 Lawrenceville, GA 30046-2210 (770) 338-8000 or (770) 962-8000 (Fax) (770) 822-5990	
PROJECT		JACKSON COUNTY JAIL 555 GENERAL JACKSON DRIVE JEFFERSON, GEORGIA 30549	
SHEET TITLE		PLUMBING ROOF PLAN AREAS A, B & C	
RELEASE		NO DESCRIPTION DATE 10/31/07 D.E.C. / PLUMBING BID PACKAGE RELEASE M.P.E. COORDINATION 02/29/08	
FILE NUMBER		CAD FILE NAME 08086P21-2 PROJ. NUMBER A06136 DATE 10-31-07	
P2.7			

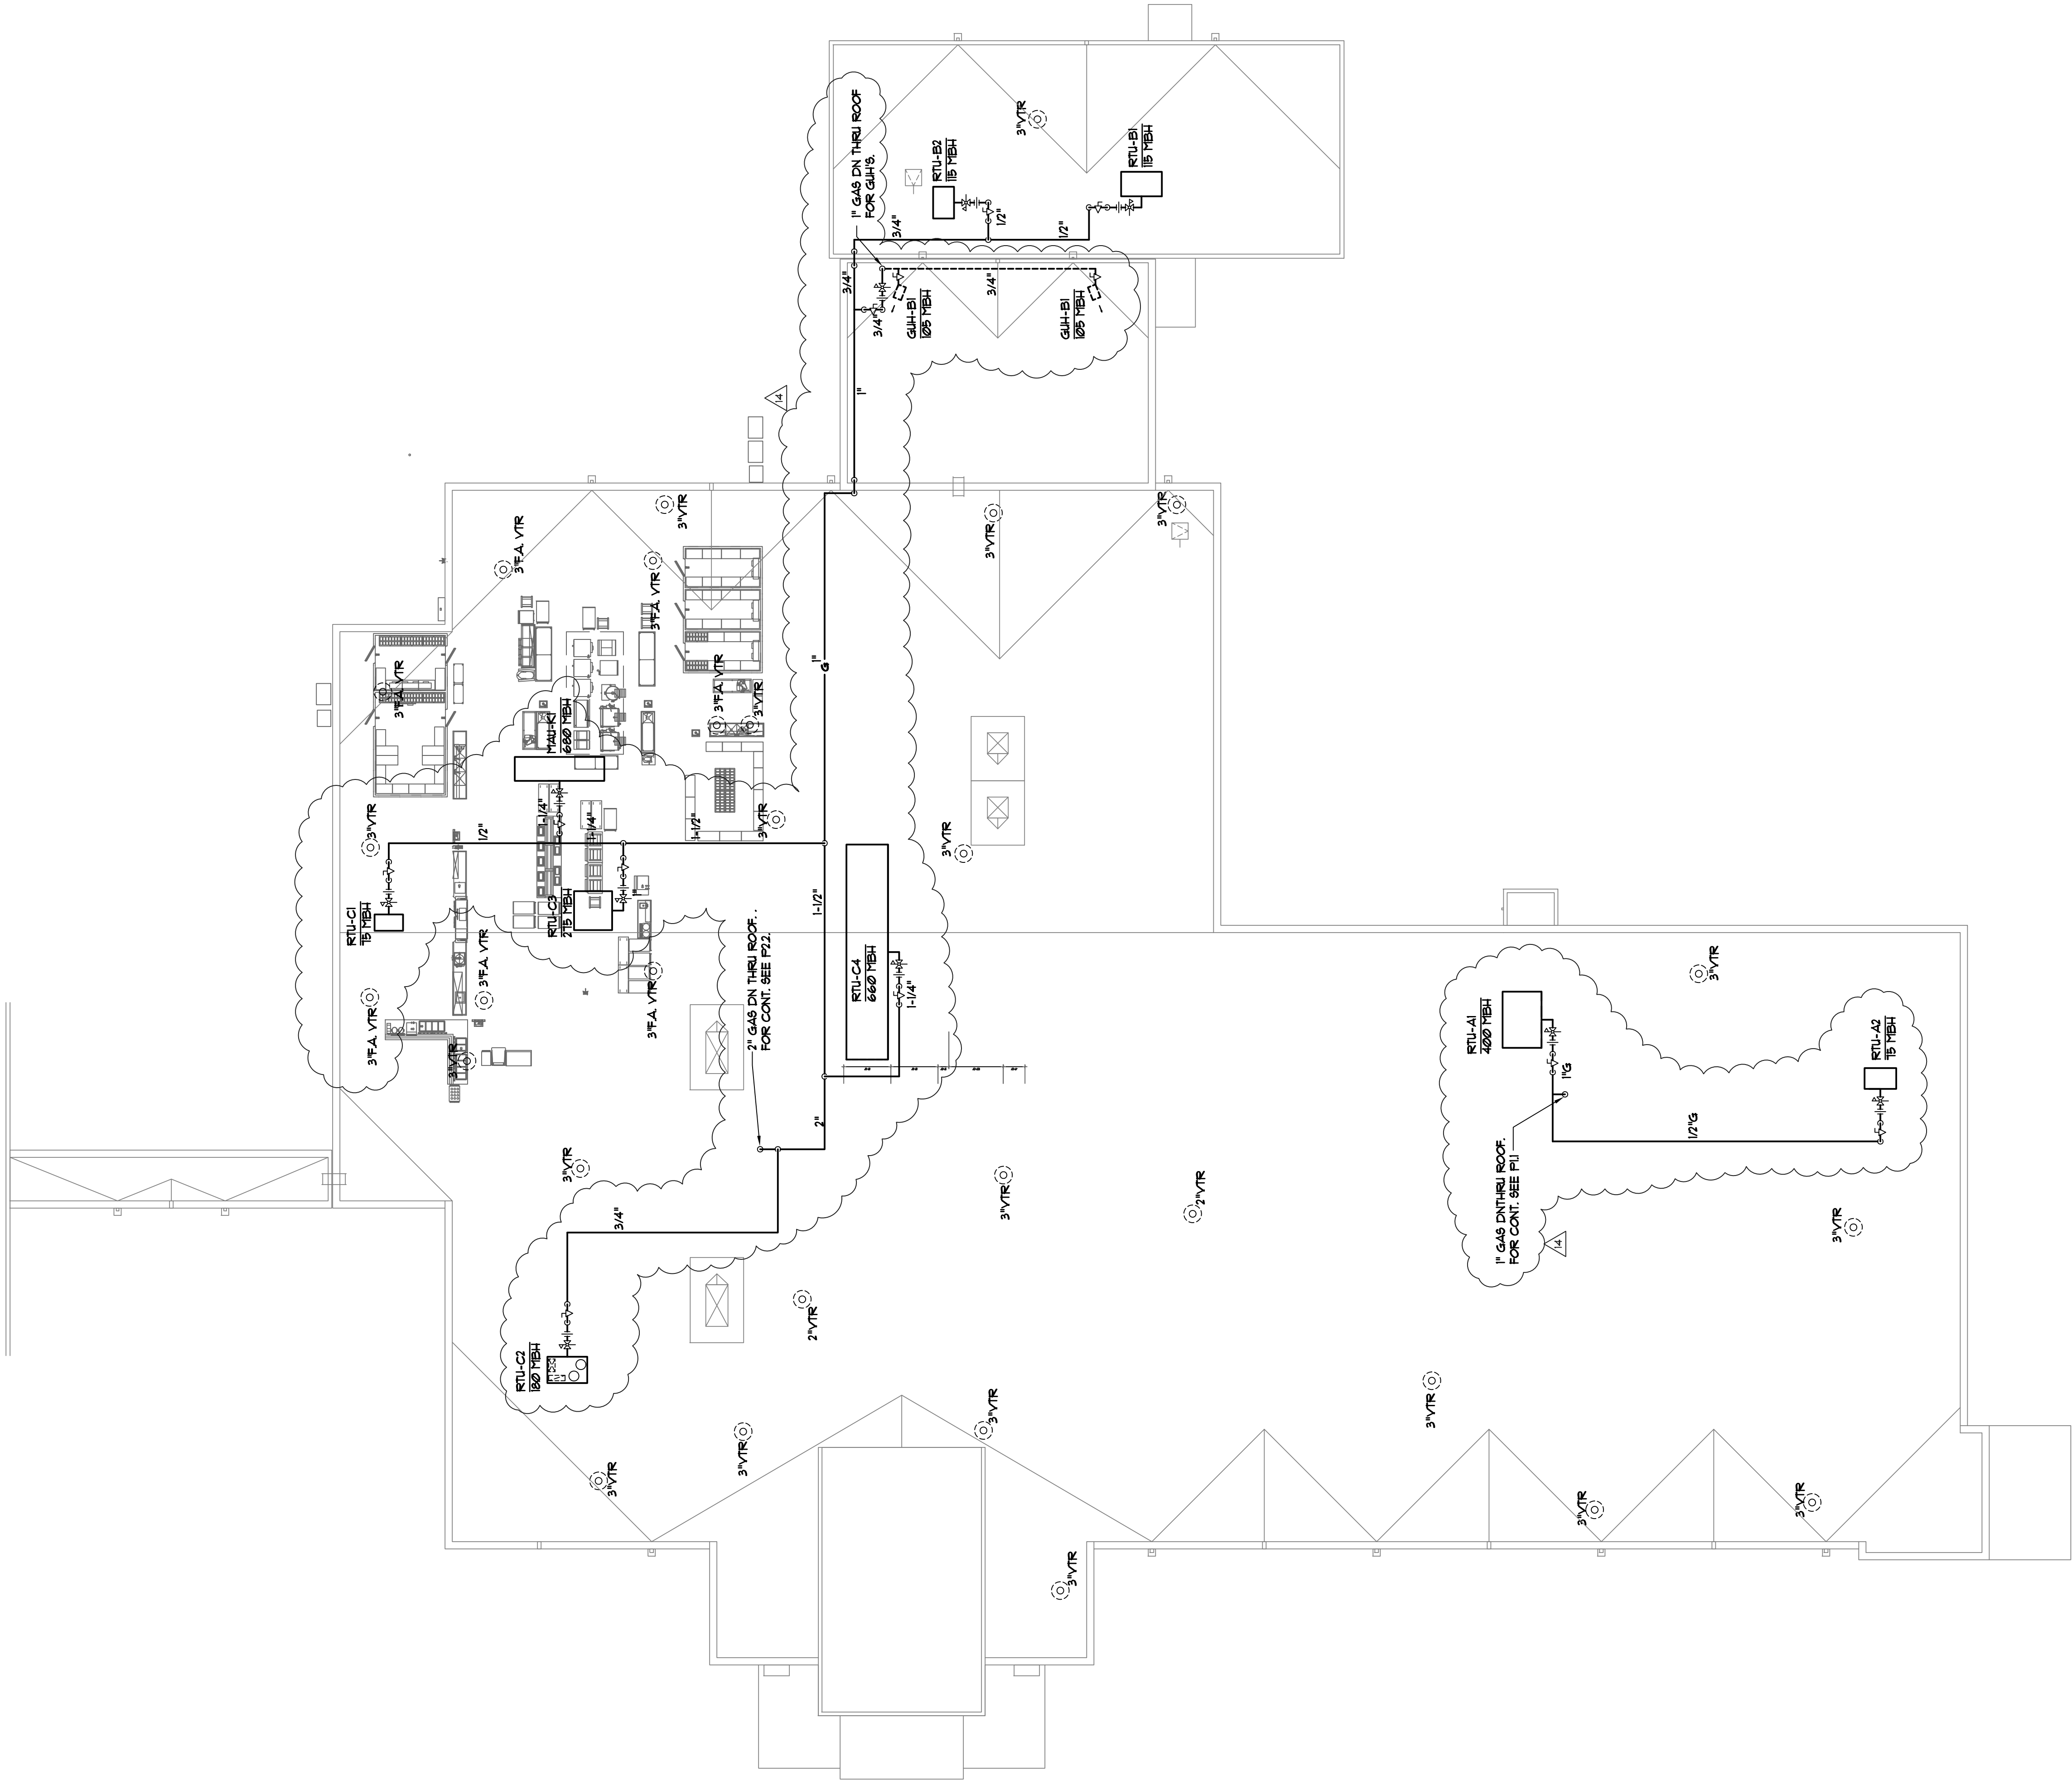

1 PLUMBING PLAN WATER - Area 'A, B + C'

SCALE 1/8" = 1'-0"

