


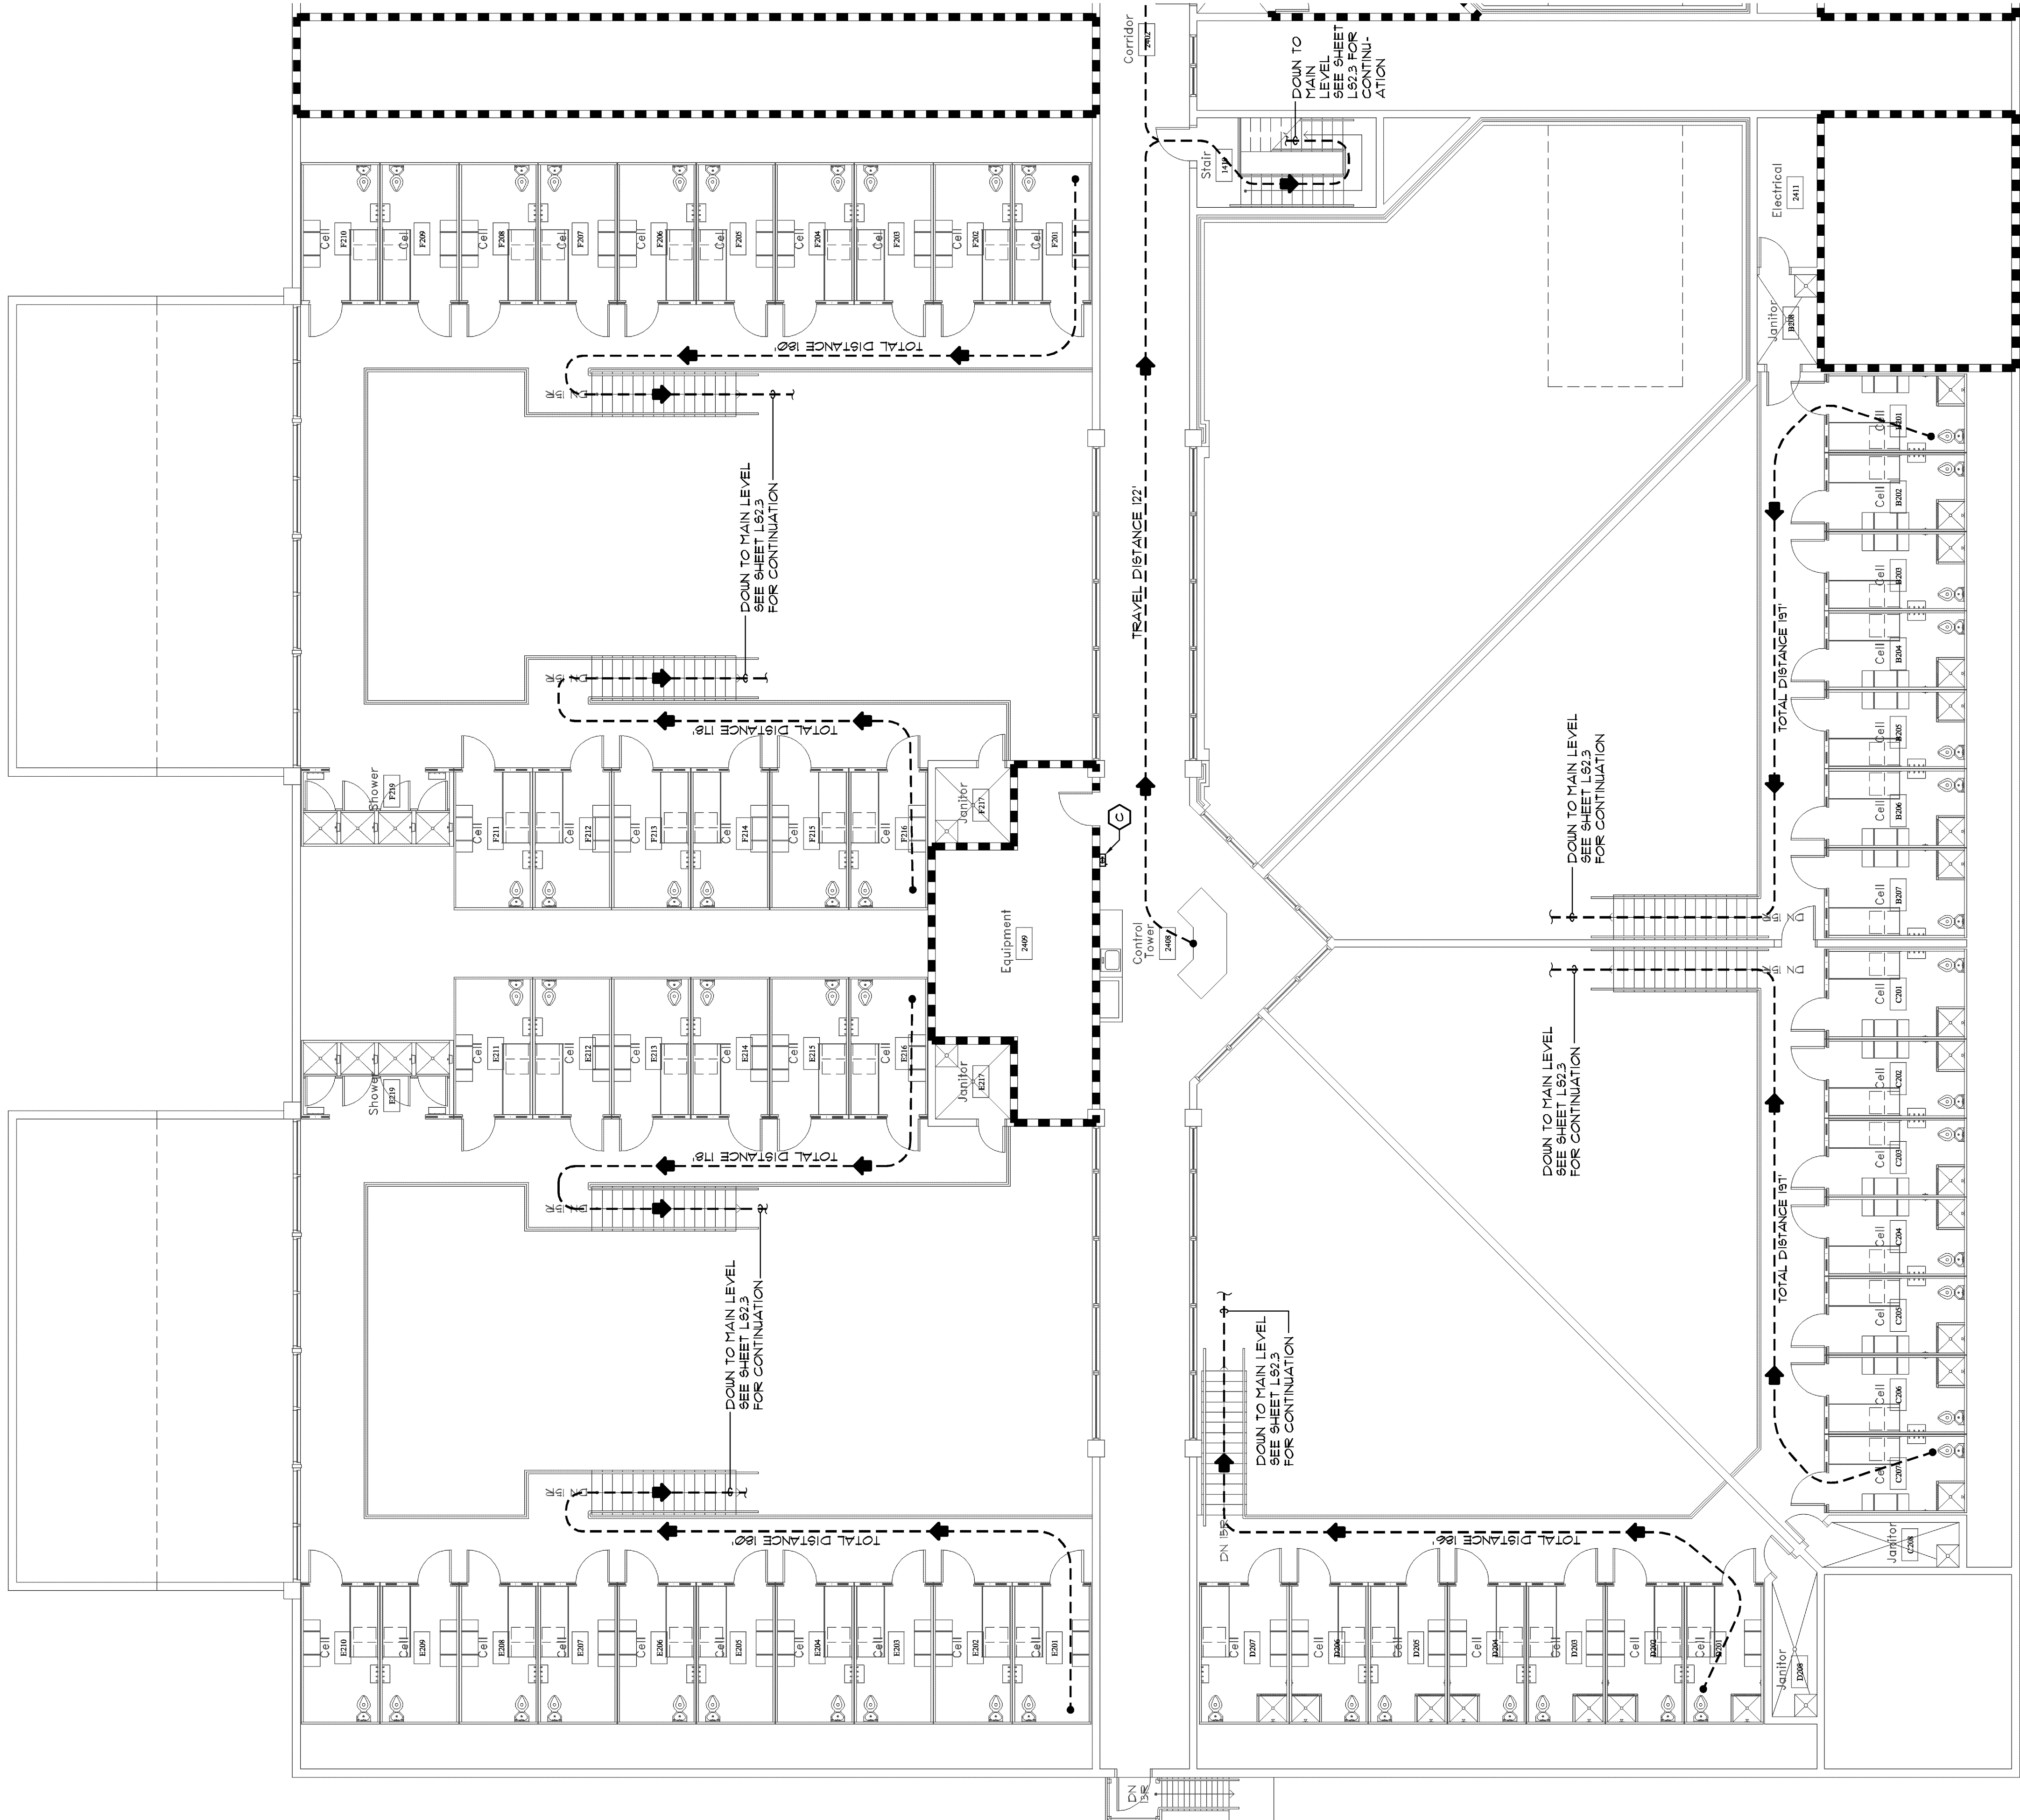

NOTE: - - - SMOKE RESISTANT CONSTRUCTION

Fire-Rating Partition Legend			
SYMBOL	ASSEMBLY	FIRE RATING	UL TEST
■ ■ ■ ■	8" CMU	(1) HOUR	UL-1909 REFER TO 7.1.6.5.7 FOR DETAIL
■ ■ ■ ■	3 5/8" or 6" RETAL STUD	(1) HOUR	UL-1465 REFER TO 7.1.6.5.7 FOR DETAIL
■ ■ ■ ■	8" CMU	(2) HOUR	UL-1909 REFER TO 7.1.6.5.7 FOR DETAIL
■ ■ ■ ■	8" CMU	(4) HOUR	UL-1909 REFER TO 7.1.6.5.7 FOR DETAIL

Life Safety Legend and Notes

↑ 12" DENOTES TOTAL WIDTH OF EGRESS PROVIDED. REFER TO 9/L\$2.1 FOR INFORMATION ON MEASUREMENT OF EGRESS CAPACITY WIDTH. (FLOOR EGRESS WIDTH REQUIRED)

- ① DENOTES SURFACE MOUNTED PORTABLE FIRE EXTINGUISHER
(SEE FIRE EXTINGUISHER LEGEND (THIS SHEET) FOR ADDITIONAL INFORMATION)
- ② DENOTES SURFACE MOUNTED OR 90° RECESSED FIRE EXTINGUISHER CABINET
(SEE FIRE EXTINGUISHER LEGEND (THIS SHEET) FOR ADDITIONAL INFORMATION)

XXX¹ — DENOTES TRAVEL DIRECTION AND TOTAL DISTANCE

163

- SEEK TO RISE ABOVE PARTITION WALL. LEGEND THIS SHEET AND REFERENCE FLOOR PLANS (AS APPLICABLE) TO THE PARTITION ASSEMBLY AND HEIGHT REQUIREMENTS.


Life Safety Notes - NFPA 101

[illegible]

Fire Extinguisher Legend

- A** SEMI-RECESSED CABINET
IN METAL STUD PARTITION.
- B** WALL MOUNTED BRACKET.
- C** SURFACE MOUNTED CABINET
ON CMU WALL OR PRECAST PANEL.

Key Plan

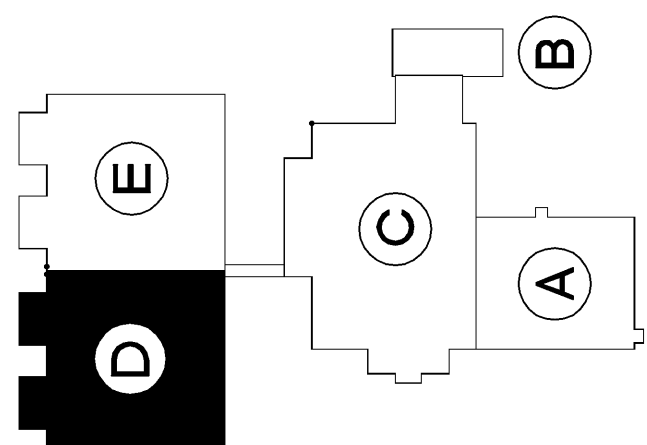

LS2.5

DATE 03-28-08

A06136

PROJ. NUMBER

136LS2-5.dwg

CAD FILE NAME

FILE NUMBER

DATE	DESCRIPTION	MECHANICAL/ ELECTRICAL BID PACKAGE RELEASE	MECHANICAL/ ELECTRICAL BID PACKAGE RELEASE	7/28/08	BALANCE OF REMAINING BID PACKAGES

LIFE SAFETY PLAN		
AREA D		
MEZZANINE		
DESIGN	DRAWN	CHECKED
LD	DM	LD

JACKSON COUNTY JAIL
555 GENERAL JACKSON DRIVE
JEFFERSON, GEORGIA 30549

Precision Planning, Inc.
planners, engineers, architects & surveyors

400 Pike Boulevard
P.O. Box 22210
Livermore, CA 94566-2210
(770) 338-8000 or (770) 962-8000
(fax) (770) 822-5990



PRECISION PLANNING, INC.
ALL RIGHTS RESERVED. © 2008