

RELEASE	
08	MFE COORDINATION
07	D.E.C. / PLUMBING BID PACKAGE RELEASE
NO	DESCRIPTION

PLUMBING ROOF PLAN AREAS 'A', 'B' & 'C'		
DESIGN	DRAWN	CHECKED
CDL	XXX	CDL
SHEET TITLE		


JACKSON COUNTY JAIL
555 GENERAL JACKSON DRIVE
JEFFERSON, GEORGIA 30549

Precision Planning, Inc.
planners, engineers, architects & surveyors

P.O. Box 2210
1400 Pike Boulevard
Livermore, CA 94566-2210
(770) 338-8000 or (770) 962-8000
(Fax) (770) 822-5990



SPENCER Bristol Engineering, Inc.
5880 Live Oak Parkway NW, Suite 400
Norcross, Georgia 30093
Tel. 770-414-1628 Fax 770-414-6024
SBE Project No. 06086

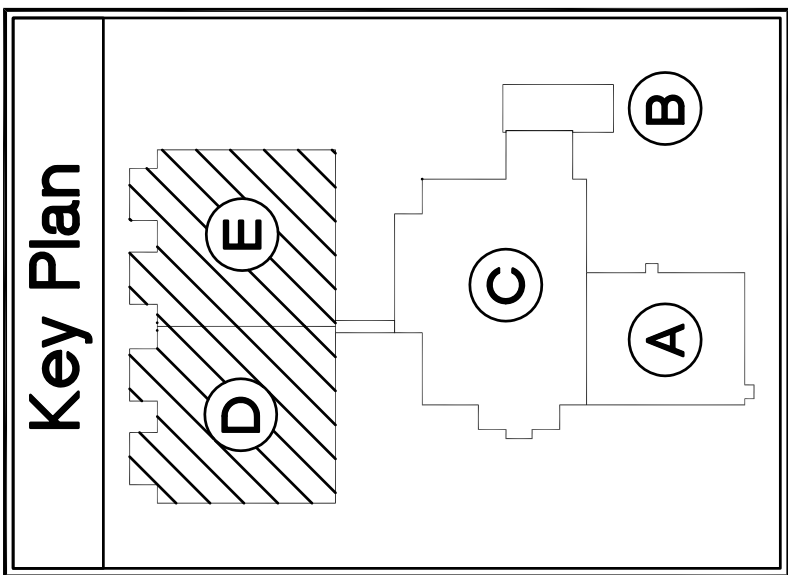

PLUMBING ROOF PLAN - Area 'D'+ 'E'

P-2B SCALE 1/8" = 1'-0"

