


PRECISION PLANNING, INC.

© 2008

ALL RIGHTS RESERVED.

PRECISION PLANNING, INC.

400 Pike Boulevard
Lawrenceville, GA 30046-2210
(770) 338-8000 or (770) 962-8000
(Fax) (770) 822-5990

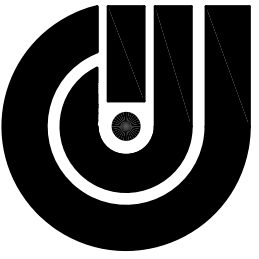

Planners, engineers, architects & surveyors

STAMP



PROJECT

JACKSON COUNTY JAIL
555 GENERAL JACKSON DRIVE
JEFFERSON, GEORGIA 30549

SHEET TITLE

PLUMBING
PLAN DWV
AREAS 'A' & 'B'

FULL
DESIGN

FULL
DRAWN

CDL
CHECKED

RELEASE

NO DESCRIPTION

10/31/07

DATE

D.E.C. / PLUMBING BID PACKAGE RELEASE

02/29/08

M.P.E. COORDINATION

FILE NUMBER

06086PH-2

CAD FILE NAME



A0616

PROJ. NUMBER

10-91-07

DATE


10/31/07

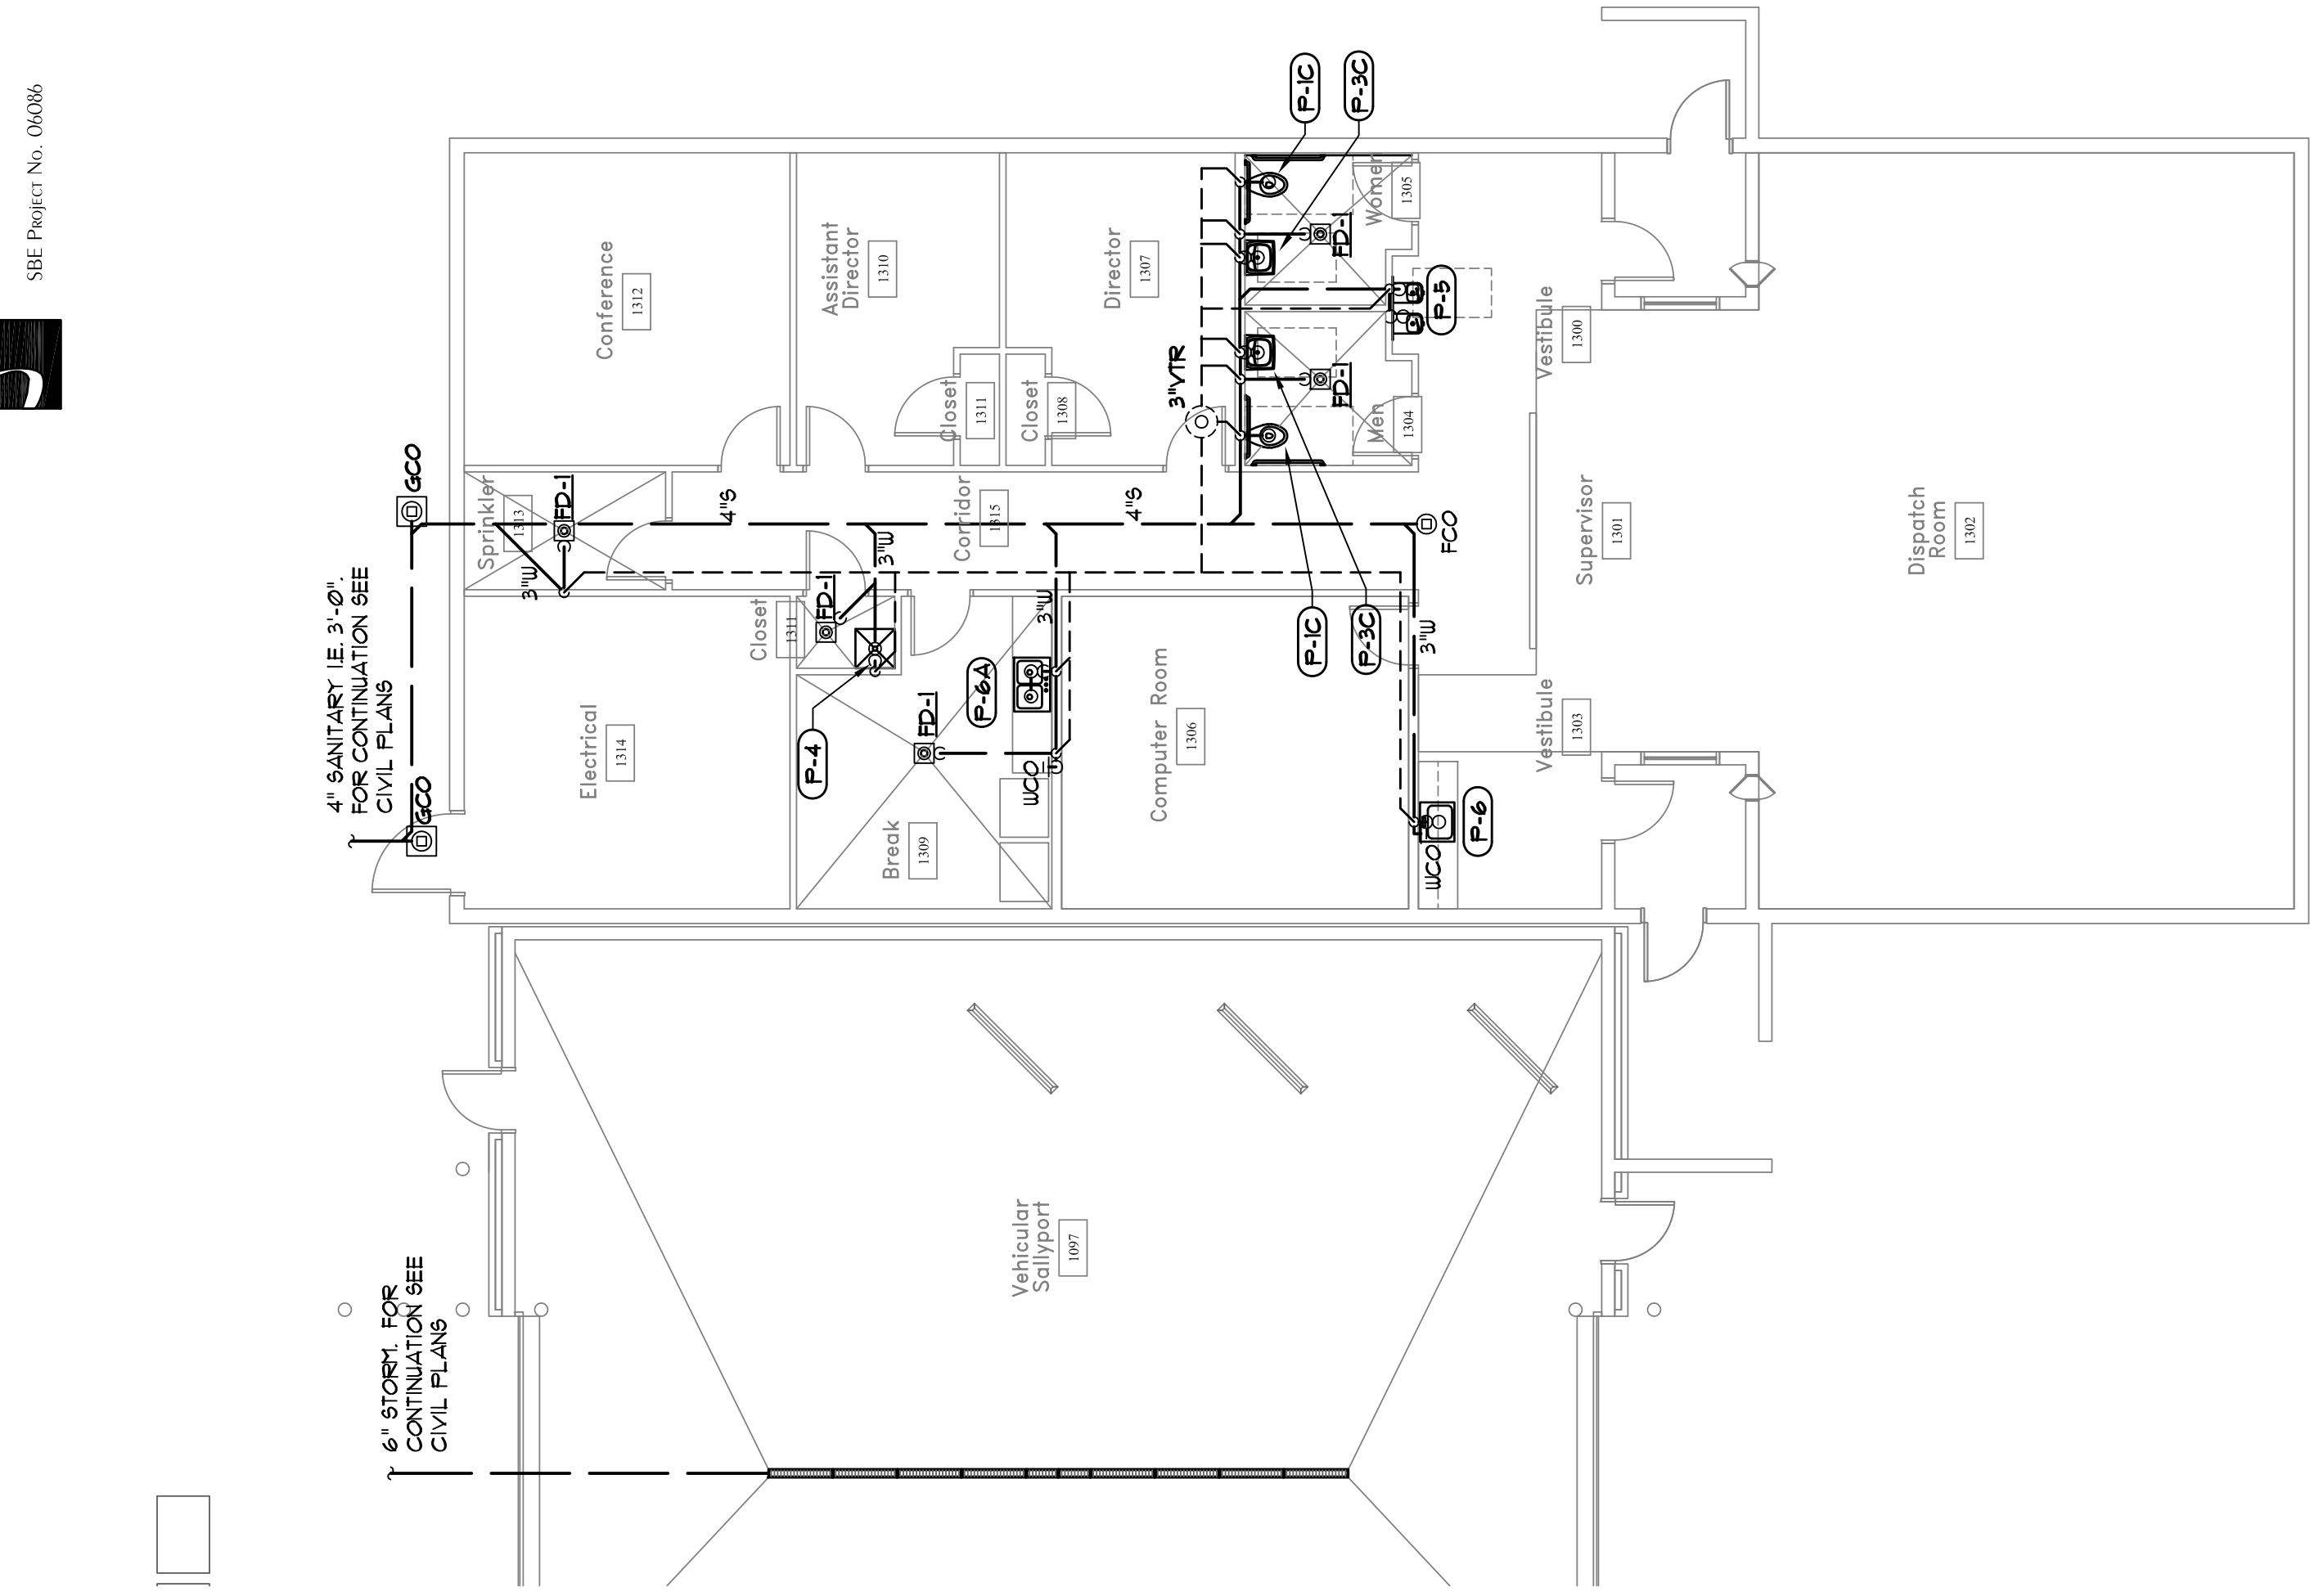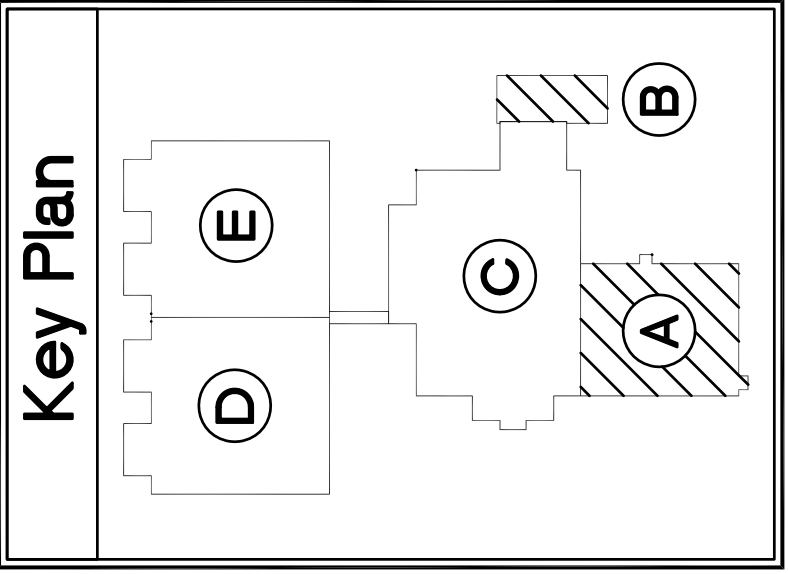

2

PLUMBING PLAN DWV - Area 'B'

SCALE 1/8" = 1'-0"

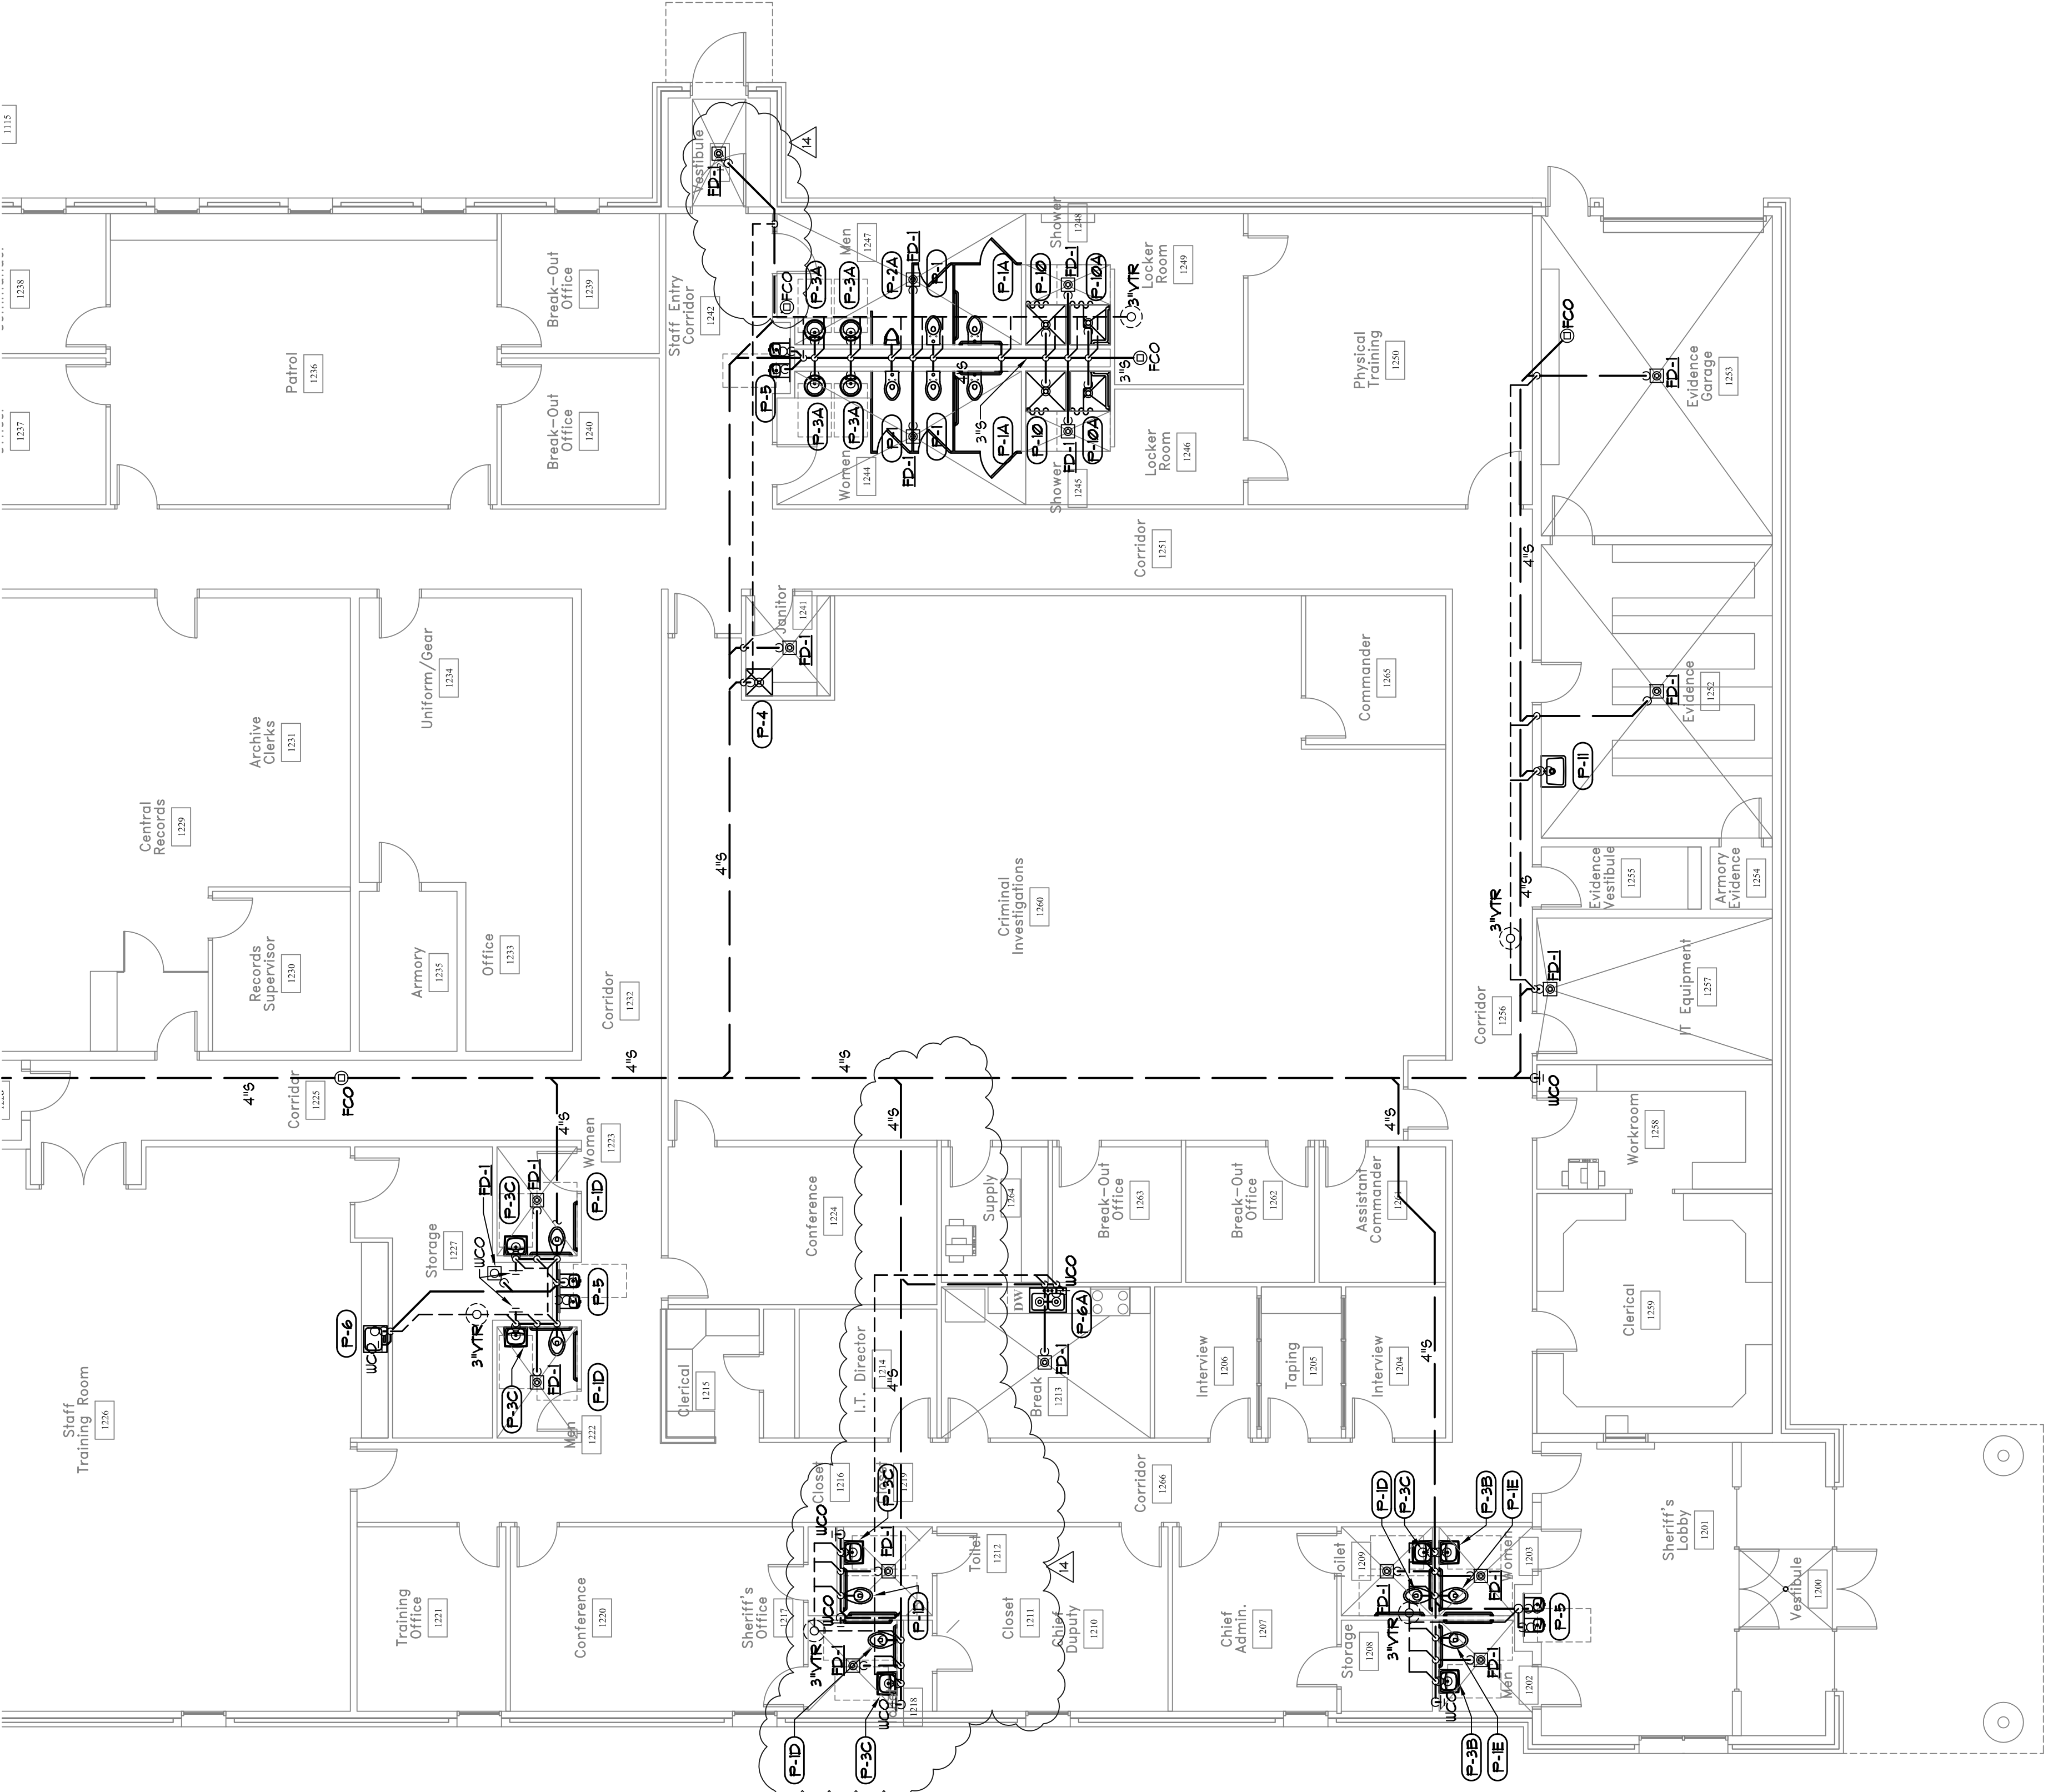

1

PLUMBING PLAN DWV - Area 'A'

SCALE 1/8" = 1'-0"