


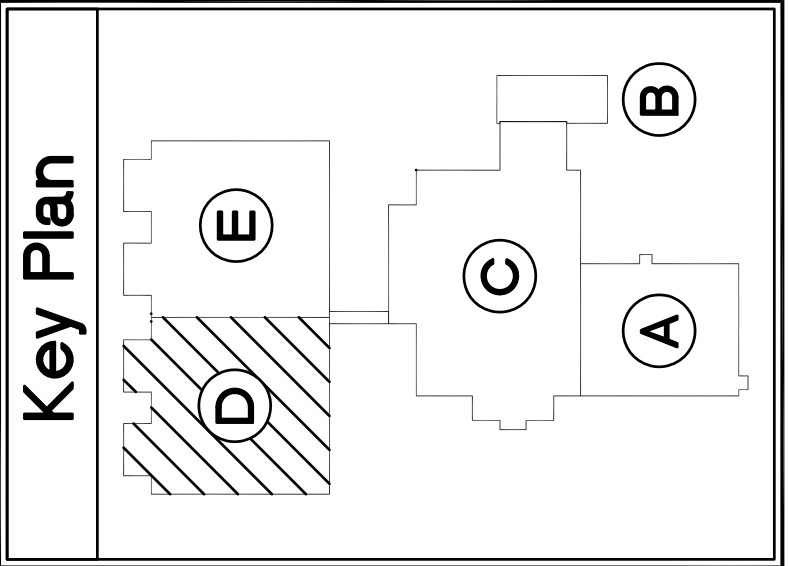


Spencer Bristol Engineering, Inc.
2880 Ilex Old Parkway NW, Suite 100
Atlanta, Georgia 30328
Tel: 770.484.6228 Fax: 770.484.0224
SEE Project No. 000066

P-15		FILE NUMBER		CAD FILE NAME		PROJ. NUMBER		DATE			
		06086X15-6		A06166		10/31/07		10-31-07			
		02/29/08		M.P.E. COORDINATION							
		10/31/07		D.E.C. / PLUMBING BID PACKAGE RELEASE							
		NO DESCRIPTION									
SHEET TITLE		DESIGN		F.U.L.		F.U.L.		F.U.L.			
MEZZANINE		DRAWN		F.U.L.		F.U.L.		F.U.L.			
		CHECKED		CDL		CDL		CDL			
PROJECT		JACKSON COUNTY JAIL		555 GENERAL JACKSON DRIVE		JEFFERSON, GEORGIA 30549					
		P.O. Box 2210		400 Pike Boulevard		Lawrenceville, GA 30046-2210		(770) 338-8000 or (770) 962-8000			
		Precision Planning, Inc.		Planners, engineers, architects & surveyors							
STAMP		PRECISION PLANNING, INC.		ALL RIGHTS RESERVED.							
		THIS DOCUMENT IS THE PROPERTY OF PRECISION PLANNING, INC. AND IS NOT TO BE REPRODUCED OR TRANSMITTED IN ANY FORM OR BY ANY MEANS, ELECTRONIC OR MECHANICAL, INCLUDING PHOTOCOPYING, RECORDING, OR BY ANY INFORMATION STORAGE AND RETRIEVAL SYSTEM. WITHOUT PERMISSION FROM PRECISION PLANNING, INC. ANY OTHER PROJECTS SHOWN HEREIN ARE NOT THE PROPERTY OF PRECISION PLANNING, INC. AND ARE NOT TO BE USED FOR ANY OTHER PROJECTS WITHOUT THE WRITTEN PERMISSION FROM PRECISION PLANNING, INC.									



KEYED NOTES:

1. 4" WASTE DN 12" V UP. CONNECT 4" STACK TO 2" VENT STACK FOR CONT. SEE P13 OR P14
2. 2" WASTE DN 4 1/2" V UP. CONNECT 2" WASTE TO 2" VENT STACK FOR CONT. SEE P 13 OR P14
3. 2" WASTE DN 4 1/2" V UP. FOR CONT. SEE P13 OR P14
4. 1 1/2" V DN FOR CONT. SEE P13 OR P14
5. 2" WASTE DN 4 1/2" V UP
6. 2" V DN FOR CONT. SEE P13 OR P14
7. 2" WASTE DN IN WALL IN LOWER LEVEL FOR CONT. SEE P13 OR P14
8. 4" WASTE DN 2" V UP FOR CONT. SEE P14

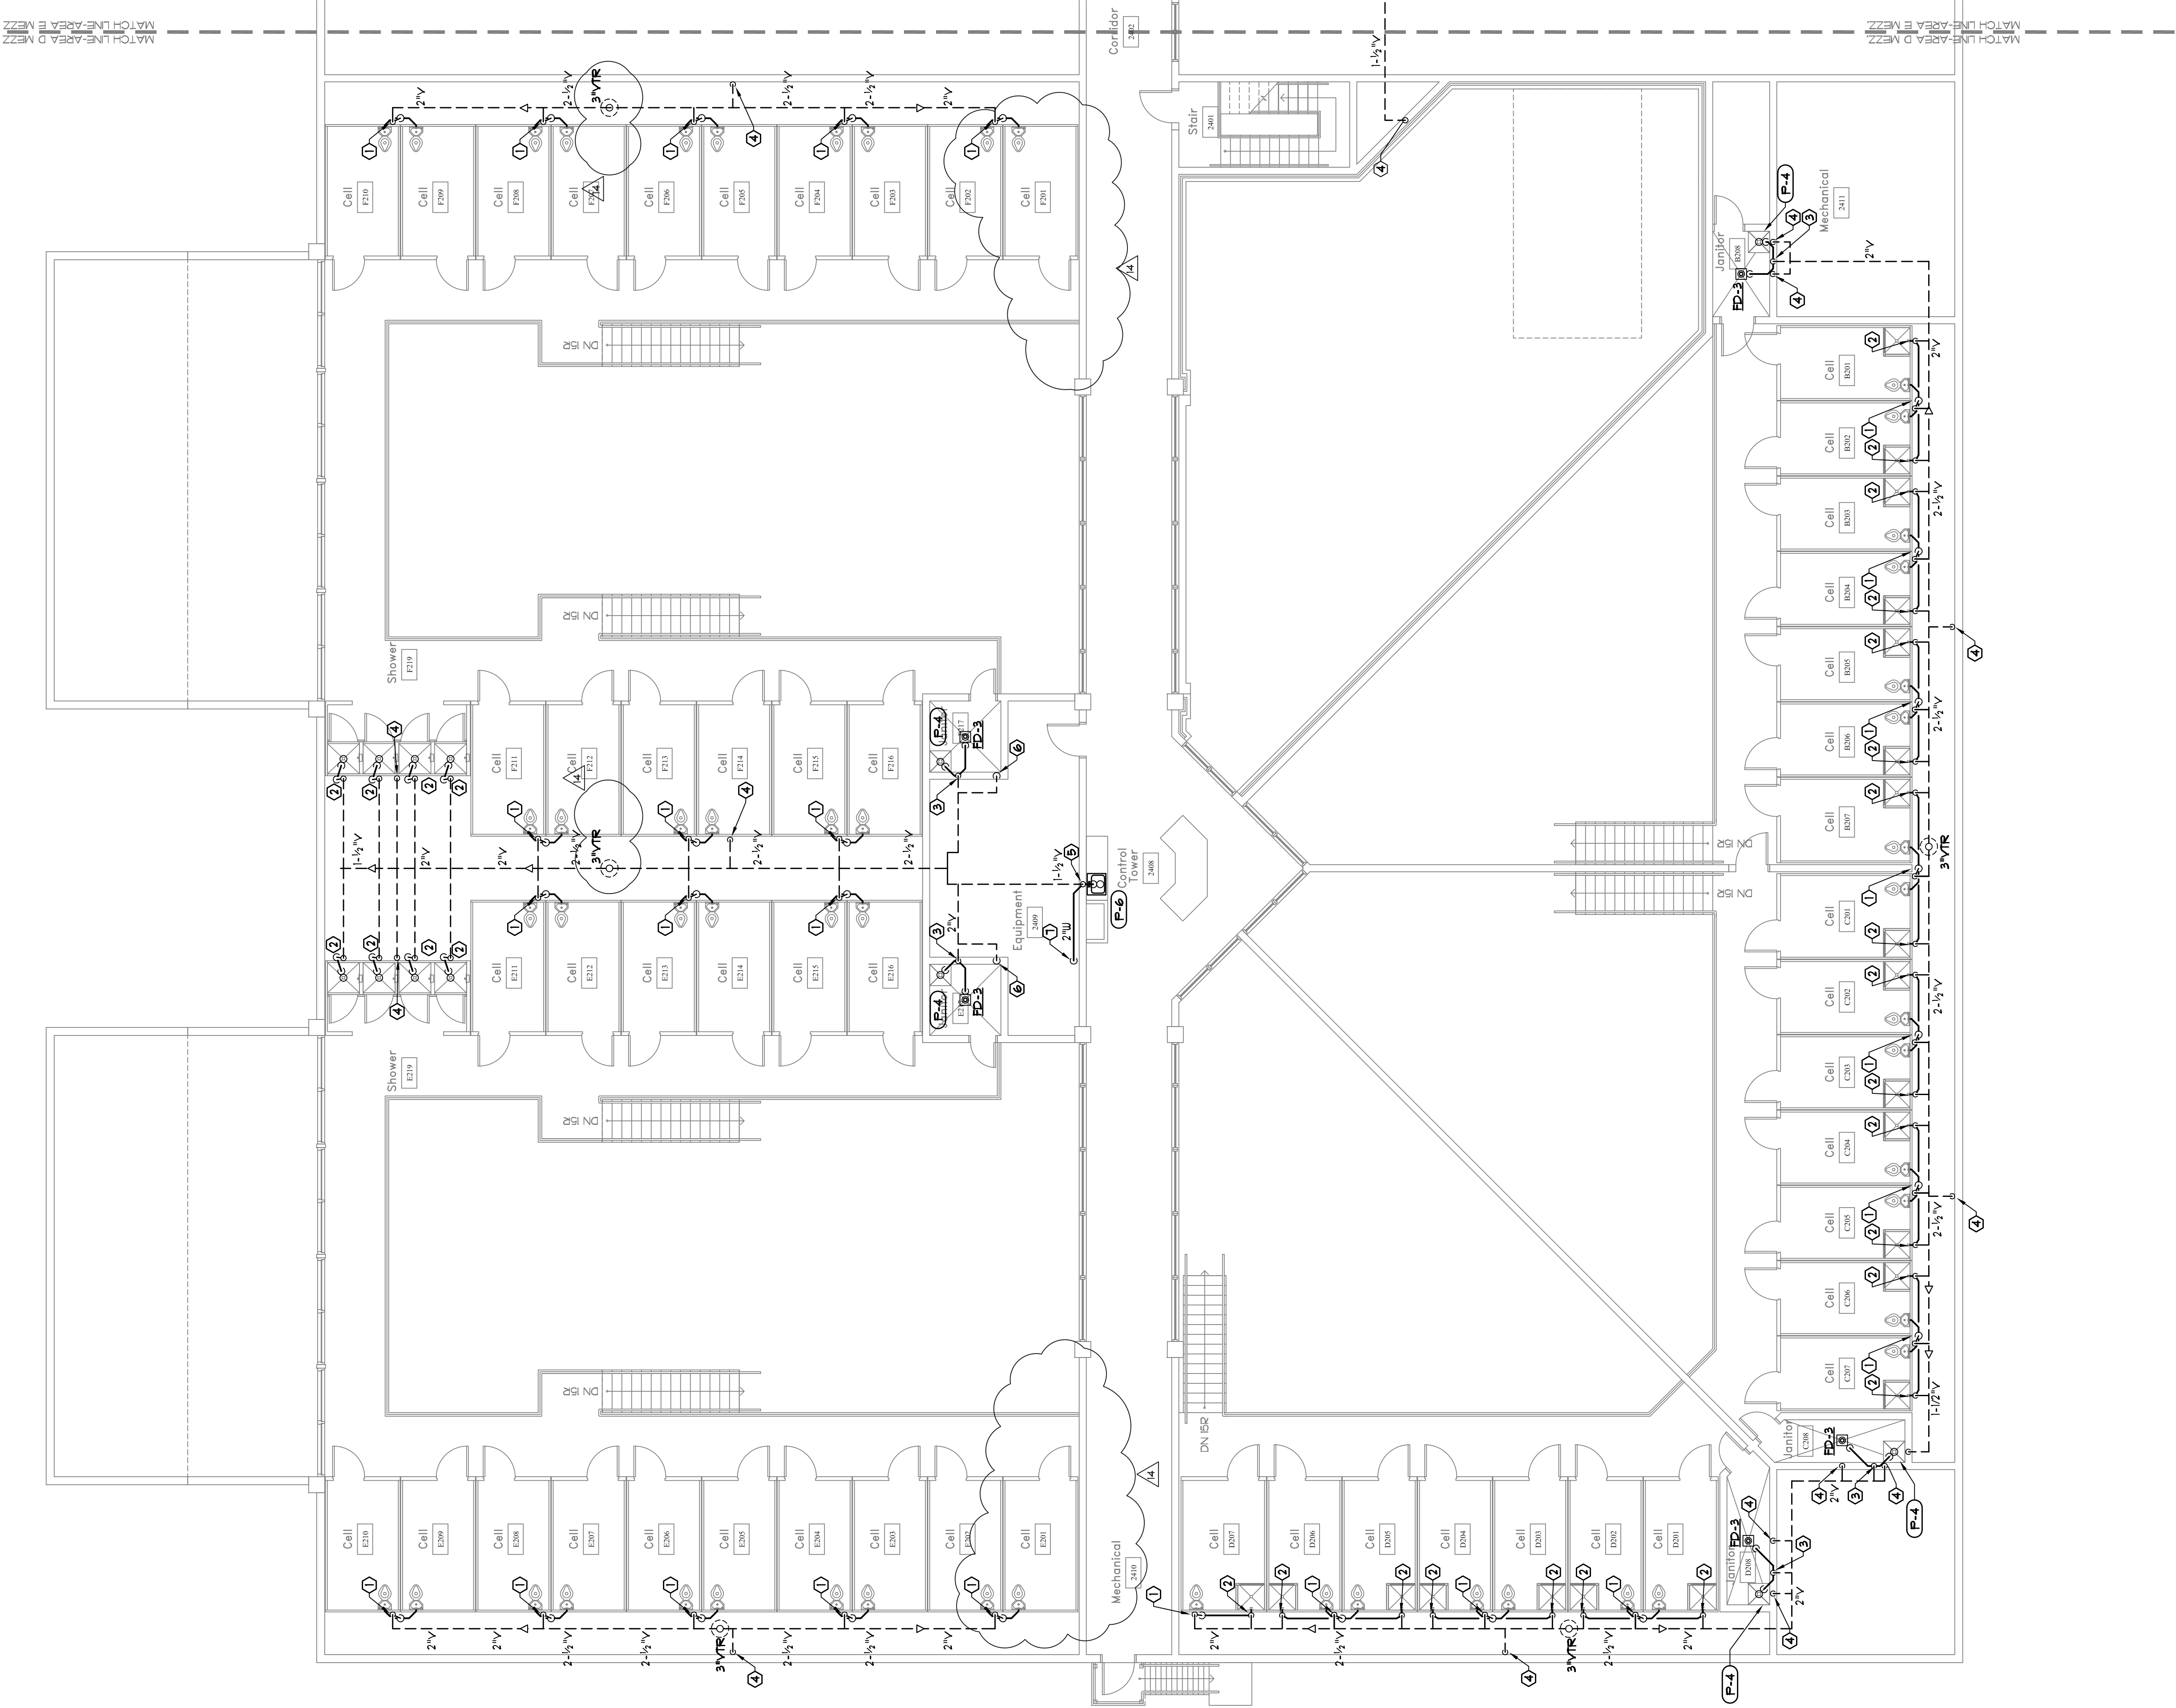

1 PLUMBING PLAN - Area 'D' - Mezzanine
P-15 SCALE 1/8\"/>