



Spencer Bristol Engineering, Inc.
2800 Ilex Old Parkway NW, Suite 100
Atlanta, Georgia 30328
Tel: 770.484.0228 Fax: 770.484.0224
SEE Project No. 00006

STAMP

© 2008
PRECISION PLANNING, INC.
ALL RIGHTS RESERVED.

Planners, engineers, architects & surveyors
Precision Planning, Inc.
P.O. Box 2210
400 Pike Boulevard
Lawrenceville, GA 30046-2210
(770) 338-8000 or (770) 962-8000
(Fax) (770) 822-5990

PROJECT

JACKSON COUNTY JAIL
555 GENERAL JACKSON DRIVE
JEFFERSON, GEORGIA 30549

SHEET TITLE

PLUMBING
PLAN DWV
AREA 'D'

FULL

DESIGN

FULL

DRAWN

CDL

CHECKED

RELEASE

NO DESCRIPTION
DATE 10/31/07
D.E.C. / PLUMBING BID PACKAGE RELEASE
M.P.E. COORDINATION
02/29/08

FILE NUMBER
06086P13-4

CAD FILE NAME
A06136


PROJ. NUMBER
A06136

DATE
10-31-07

P-13

KEYED NOTES:

- 1" V UP 4" WASTE UP 1 DN CONNECT TO WATER CLOSET COMBINATION FOR CONT. SEE P15 OR P16
- 1 1/2" V UP 4" WASTE DN CONNECT TO SINK
- 3" WASTE UP FOR CONT. SEE P15 OR P16
- 1 1/2" V UP FOR CONT. SEE P15 OR P16
- 1 1/2" V UP 4" TRANSITION TO 3" BFF 1 1/2" V UP TO AIR ADJUSTANCE VALVE
- 2" WASTE DN 4" TRANSITION TO 3" BFF 1 1/2" V UP TO AIR ADJUSTANCE VALVE
- 2" V UP TO LEVEL ABOVE FOR CONT. SEE P15 OR P16
- 2" WASTE UP FOR CONT. SEE P15 OR P16
- 4" WASTE UP FOR CONT. SEE P16
- 1 1/2" V BFF STUB UP ABOVE FLOOR AND CONNECT TO VENT STACK

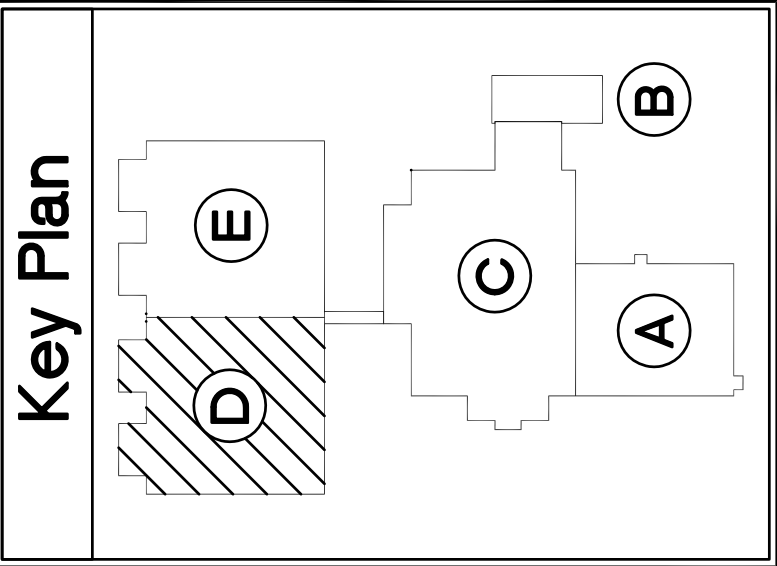

1 PLUMBING PLAN DWV - Area 'D'
P-13 SCALE 1/8" = 1'-0"

