



X'0'x'1'	APC - 1 RADAR 2'x2'x5'8". REFER TO 6 SPECIFICATIONS.
X'1'x'1'	APC - 3 HALCYON CLIMATEPLUS 2'x2'x1' WITH NRC OF .90 - REFER TO 6 SPECIFICATIONS.
X'0'x'1'	PREFRCAST FLANK - PAINT. REFER TO STRUCTURAL.
X'1'x'1'	NOT USED

X⁺ X⁺ INSTALL HOLDOWN CLIPS.

- CENTER ALL LIGHTING GRIDS IN BOTH DIRECTIONS IN ALL CORRIDORS AND IN ALL
 ROOMS WITH CEILING GRIDS. INSTALL CEILING TRACEDOS HANGING 6" FROM WALLS
 AND 12" FROM CEILING.
 CENTER ALL VENTILATION GRIDS IN BOTH DIRECTIONS IN ALL CORRIDORS AND
 CEILING TILES. CENTER CONDENSATE DRAIN DIRECTIONS TO RESISTANT WALLS.
 CENTER ALL SECURITY AND NON-SECURITY WALL MOUNTED VANITY FIXTURES
 OVER HOOKERS BELOW.
 CENTER ALL 1X4 AND 2X2 SURFACE MOUNTED FIXTURES IN BOTH DIRECTIONS
 OF SPACES.
 PROVIDE SPECIFICATIONS OF EACH FIXTURE TYPE REFER TO ELECTRICAL
 DRAWINGS.
 CENTER ALL SPRINKLER HEADS IN CEILING TILES WHERE APPLICABLE.
 PRODUCT TYPES INDICATED ARE BASIS OF DESIGN - REFER TO
 SPECIFICATIONS.
 PROVIDE SPECIFICATIONS FOR ALL WALL FIXTURES WITH HVAC GRILLES. CONTACT
 CONTRACTOR TO CONSULT OCCUPANT.
 CEILING TILES IN AREAS WITH DEPRESSIONED ALUM SHALL BE MEASURED
 FROM OVERALL BUILDING FINISH FLOOR. NOT INCLUDING DEPRESSIONED
 CEILING TILES.
 PROVIDE ADEQUATE ACCESSING TO IDENTIFY FITTING VALVES. TILES THAT ARE
 NOT EXPOSED ABOVE CEILING AND BEHIND WALLS. IDENTIFY TILES THAT ARE
 NOT EXPOSED ABOVE CEILING AND BEHIND WALLS. IDENTIFY TILES THAT ARE
 BARRIER FREE WITHIN THE SAFETY CODE.
 PROVIDE FIRM WALL BOARD EXPANSION JOINTS AT 75' OR 50' O.C.
 REINFORCE IN BULKHEADS.
 MECHANICAL ELECTRICAL PLUMBING AND FIRE PROTECTION INSTALLATION
 ALL OTHERS BOUND IN SECURE AREAS SHALL BE VERY HIGH IMPACT
 RESISTANT GRAFTED BOUND.

A diagram of a dimension line. It consists of a horizontal line with a vertical tick mark at each end. The text "9'-6"" is centered above the line. To the left of the left tick mark, the text "CEILING TYPE" is written vertically. To the right of the right tick mark, the text "CEILING HEIGHT" is written vertically. Below the line, the text "MODIFIER" is written vertically, with a line pointing to the dimension line itself.

2x4 FLUORESCENT LIGHT FIXTURE

2x2 FLUORESCENT LIGHT FIXTURE

SURFACE MOUNTED FLUORESCENT LIGHT FIXTURE

FLUORESCENT LIGHT FIXTURE - WALL MOUNTED

FLUORESCENT HIGH BAY FIXTURE

REFER TO ELECTRICAL DRAWINGS FOR EXISTING LOCATIONS

EMERGENCY LIGHT

WALL MOUNTED SCONCE

RECESSED CAN LIGHT


HVAC SUPPLY DIFFUSER

HVAC RETURN AIR GRILLE

NOT LIGHT - REFER TO A32 - CONTRACTOR SHALL COORDINATE ALL STRUCTURE MECHANICAL INSTALLATION AROUND SKY LIGHT

NOT LIGHT - REFER TO A32 - CONTRACTOR SHALL COORDINATE ALL STRUCTURE MECHANICAL INSTALLATION AROUND SKY LIGHT

NOTE: REFER TO ELECTRICAL AND MECHANICAL DRAWINGS FOR FIXTURE
DETAIL &

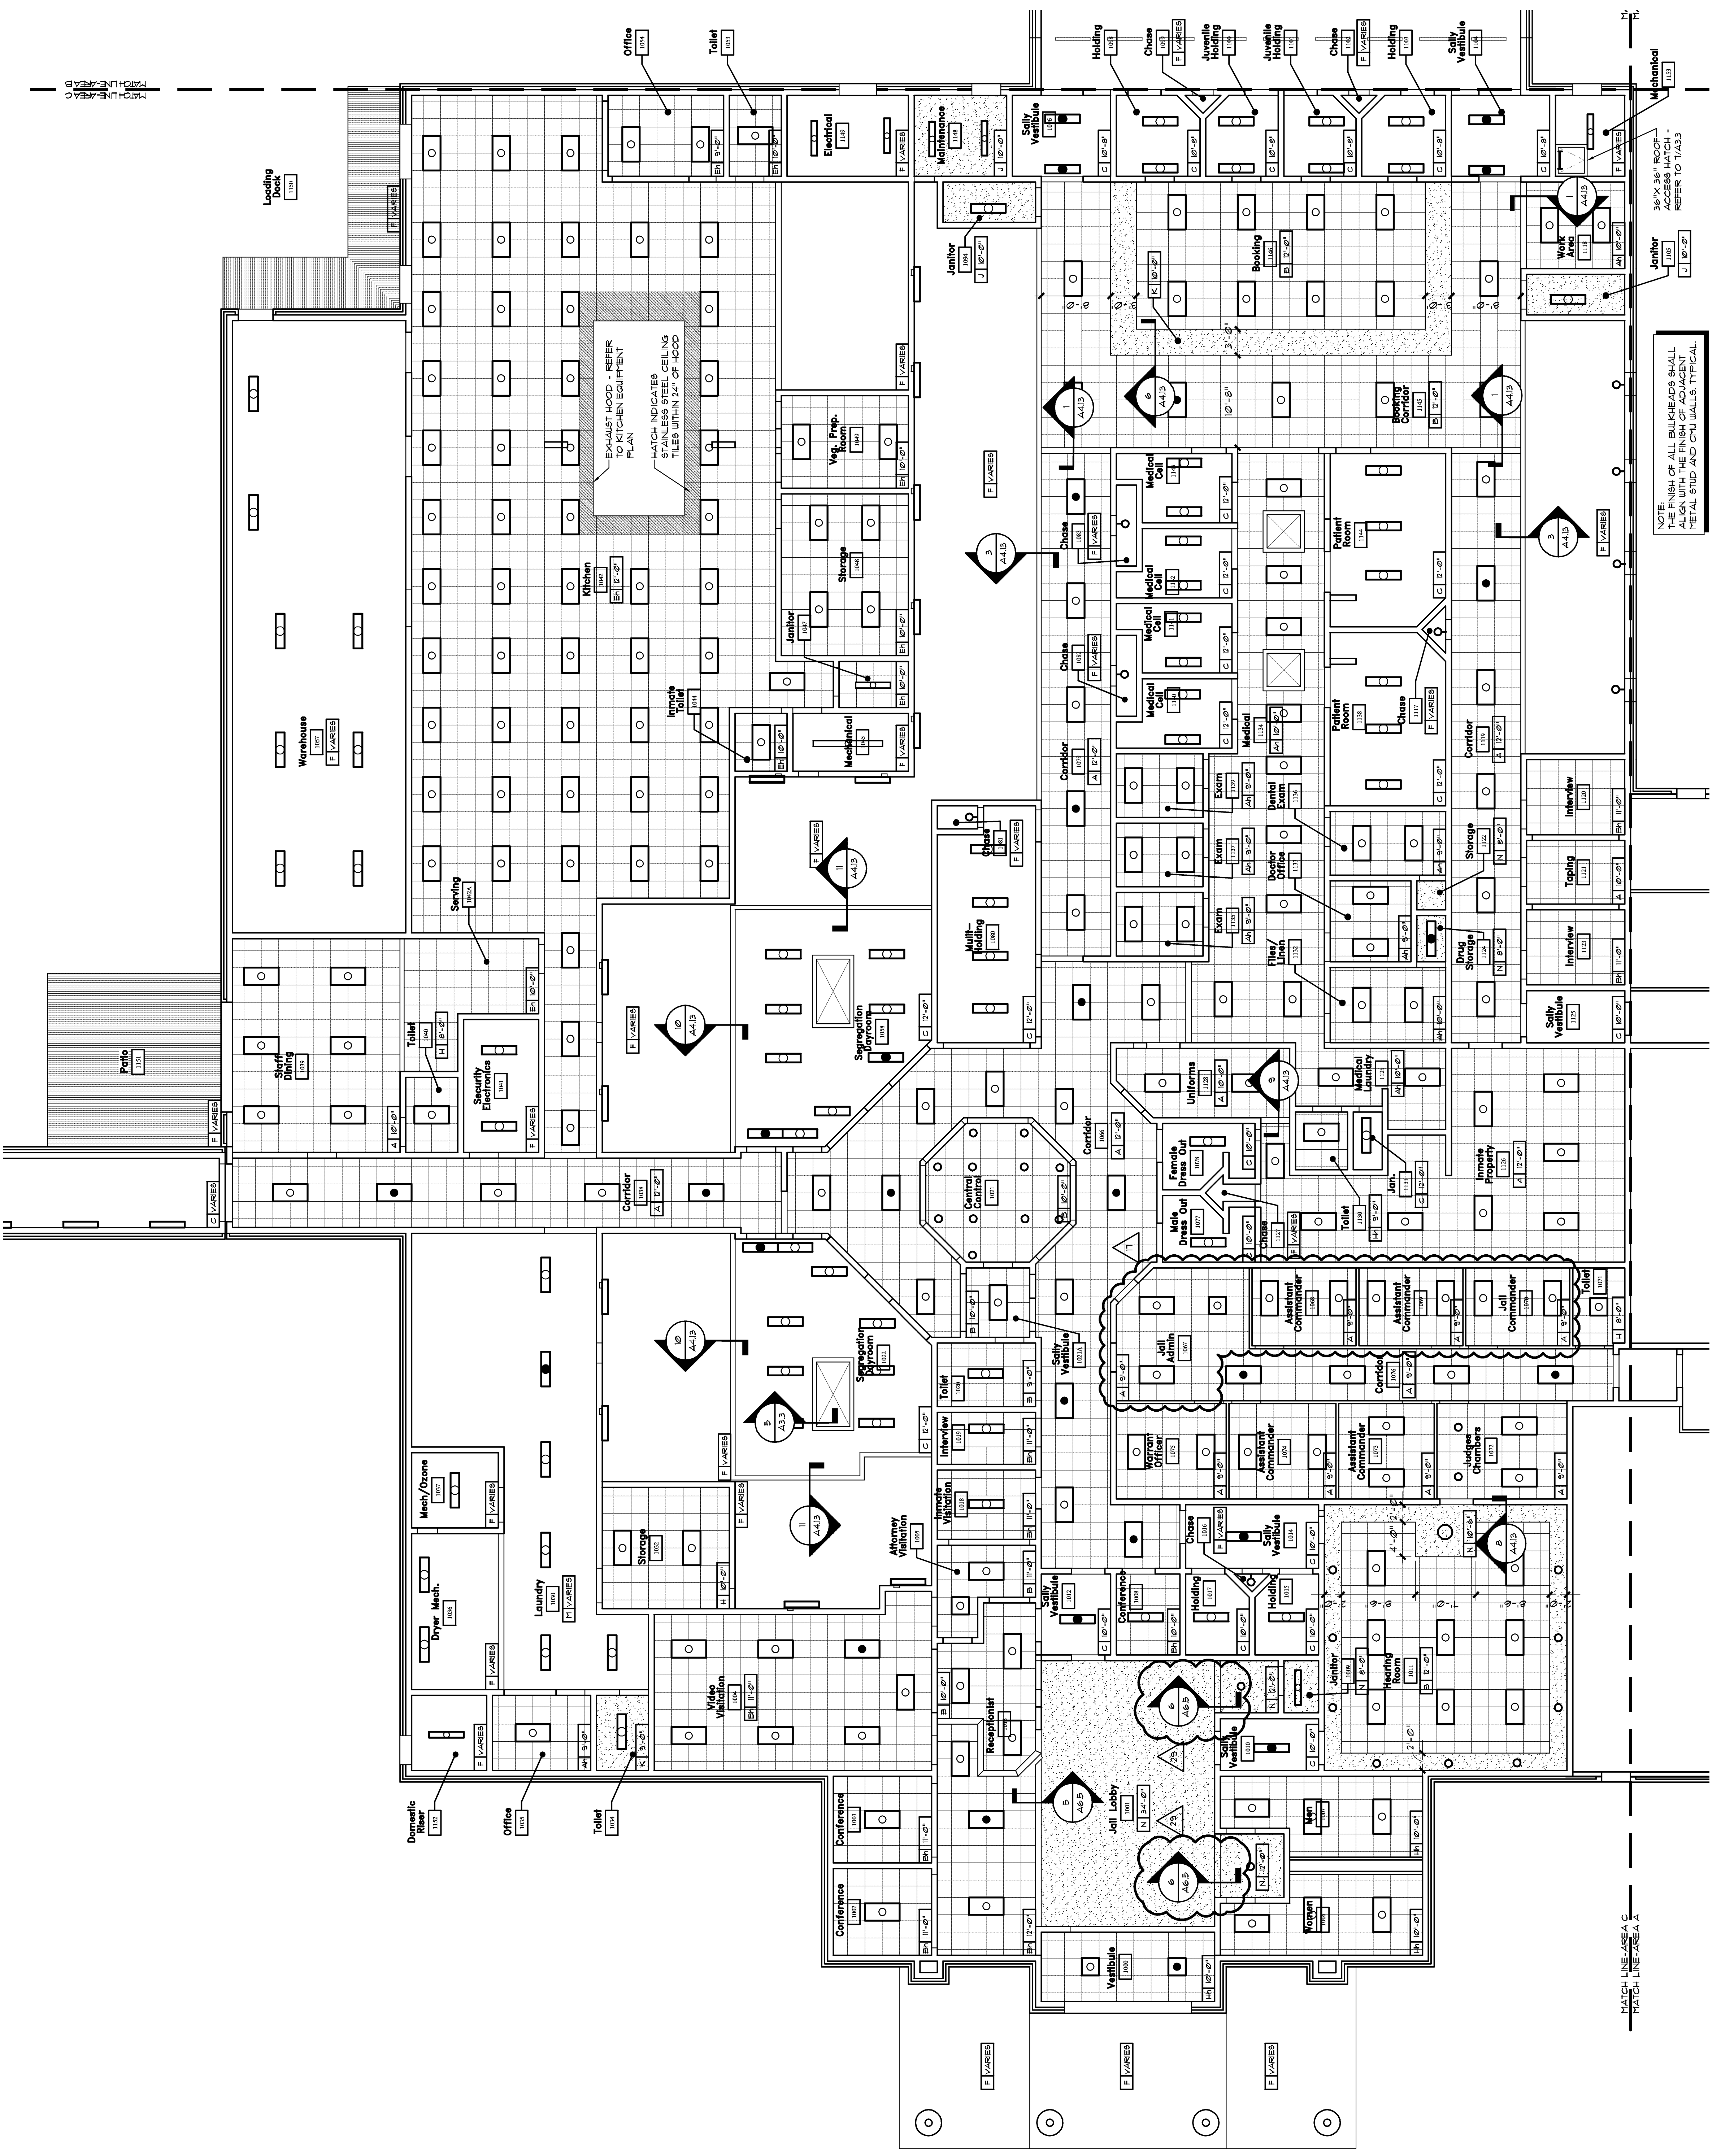

Reflected Ceiling Plan Area "C"



SCALE 1/8" = 1'-0"

Job North