



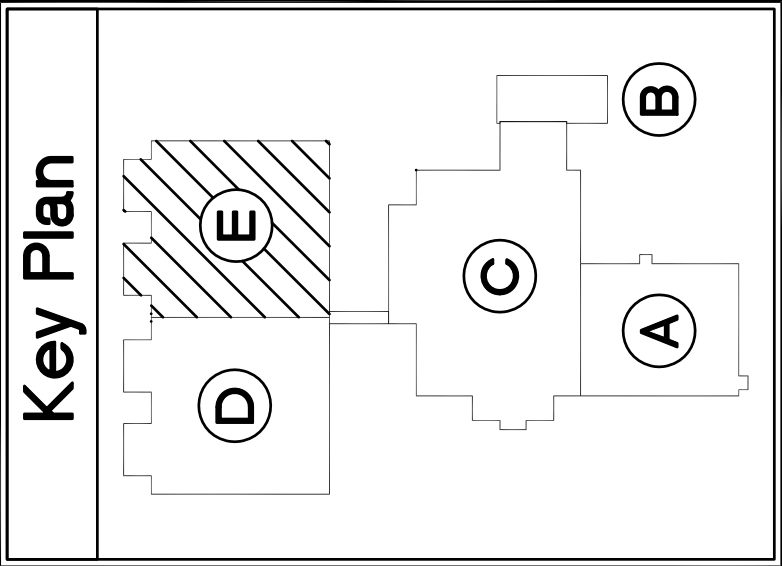

Spencer Bristol Engineering, Inc.
2800 Iac Old Parkway NW, Suite 100
Atlanta, Georgia 30328
Tel: 770.484.1628 Fax: 770.484.0224
SEE Project No. 00036

PROJECT JACKSON COUNTY JAIL 555 GENERAL JACKSON DRIVE JEFFERSON, GEORGIA 30549		SHEET TITLE PLUMBING PLAN DWV AREA 'E' MEZZANINE		RELEASE NO DESCRIPTION DATE 10/31/07 D.E.C. / PLUMBING BD PACKAGE RELEASE 02/29/08 M.P.E. COORDINATION		FILE NUMBER CAD FILE NAME 06086PF15-6 PROJ. NUMBER A06136 DATE 10-31-07		P-16	
Precision Planning, Inc. P.O. Box 2210 400 Pike Boulevard Lawrenceville, GA 30046-2210 (770) 338-8000 or (770) 962-8000 (Fax) (770) 822-5990 Planners, engineers, architects & surveyors		DESIGN F.U.L. DRAWN F.U.L. CHECKED C.D.L.		DATE 10/31/07 D.E.C. / PLUMBING BD PACKAGE RELEASE 02/29/08 M.P.E. COORDINATION		PRECISION PLANNING, INC. © 2008 ALL RIGHTS RESERVED.		STAMP PRECISION PLANNING, INC. P.L.L.C. GEORGIA REGISTERED PROFESSIONAL ENGINEER NO. 15840 EXPIRATION DATE 12/31/2011	

- KEYED NOTES:
- 1 4" WASTE DN 1/2" UP, CONNECT 4" STACK VENT TO 2" VENT STACK FOR CONT. SEE P13 OR P14
 - 2 2" WASTE DN 1 1/2" UP, CONNECT 2" WASTE TO 2" WASTE STACK FOR CONT. SEE P13 OR P14
 - 3 3" WASTE DN 1 1/2" UP, FOR CONT. SEE P13 OR P14
 - 4 1 1/2" DN FOR CONT. SEE P13 OR P14
 - 5 2" WASTE DN 1 1/2" UP
 - 6 2" V DN FOR CONT. SEE P13 OR P14
 - 7 2" WASTE DN IN WALL IN LOWER LEVEL FOR CONT. SEE P13 OR P14
 - 8 4" WASTE DN, 2" UP FOR CONT. SEE P14

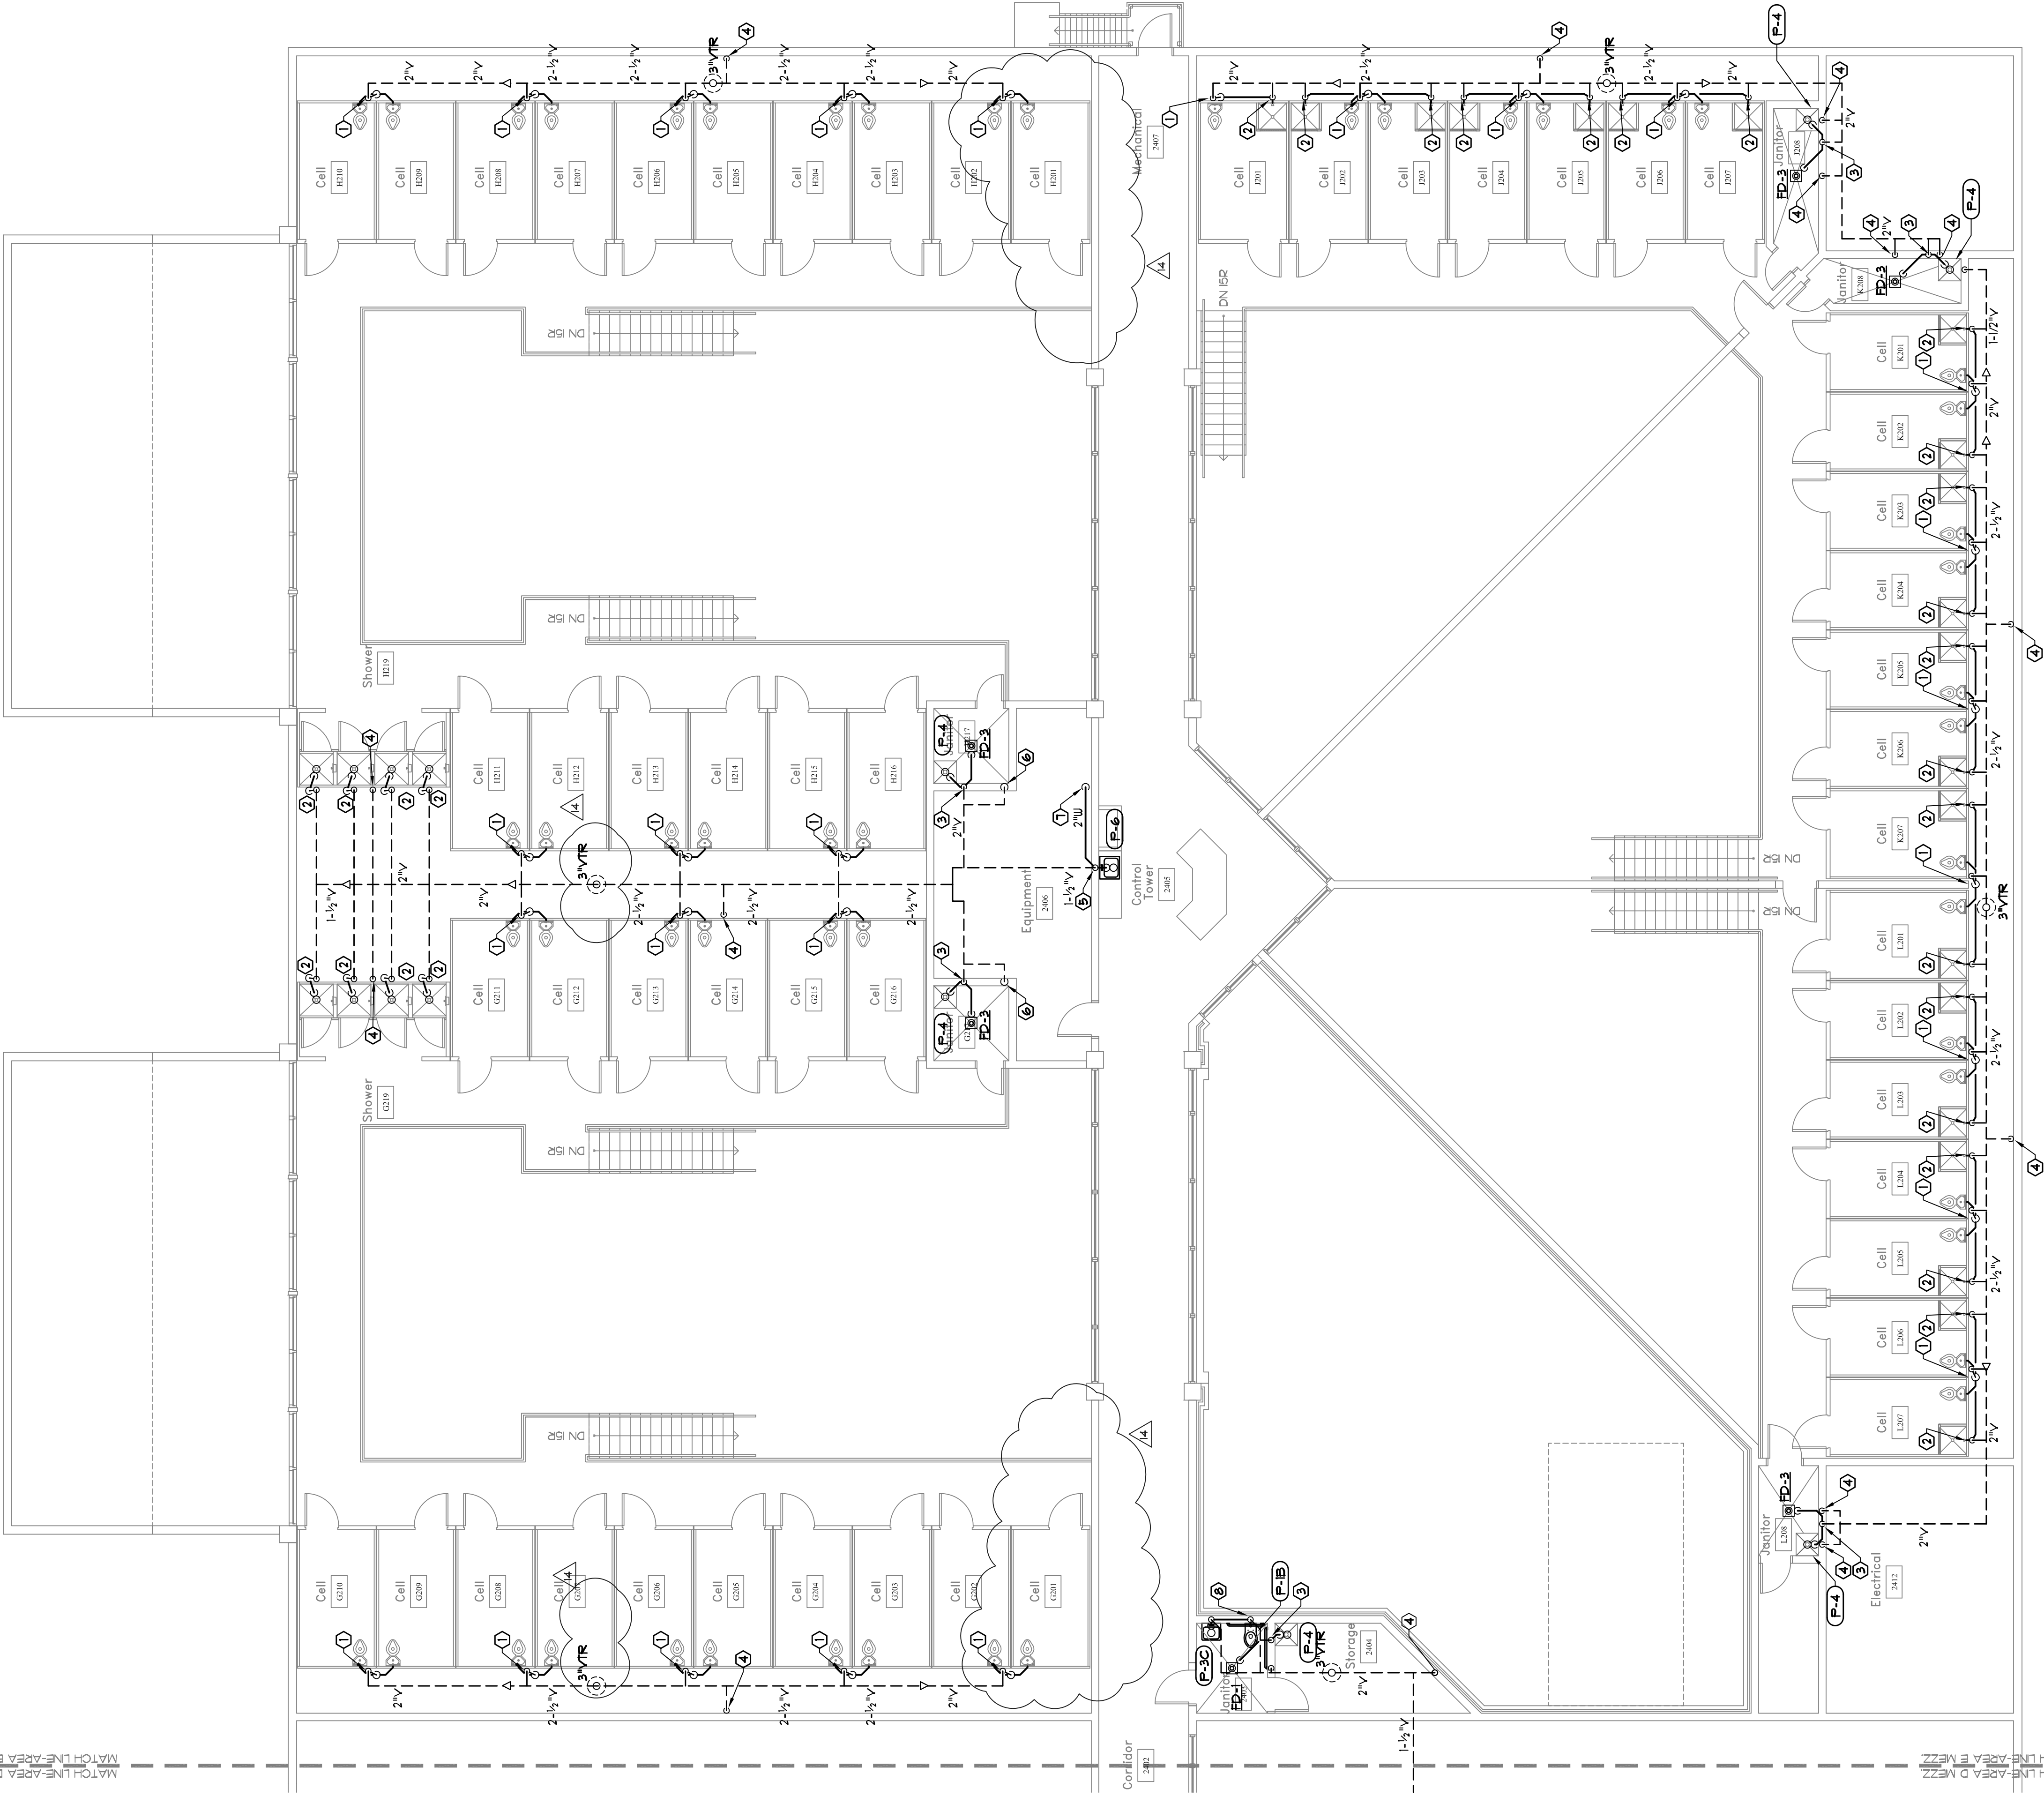

1 PLUMBING PLAN - Area 'E' - Mezzanine
SCALE 1/8" = 1'-0"