



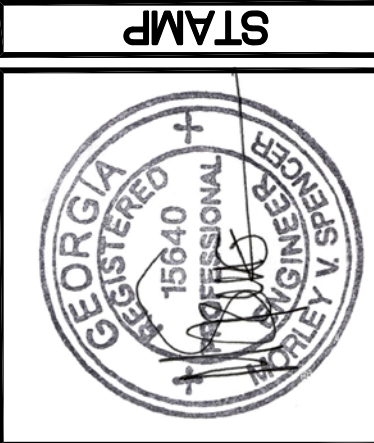

Precision Planning, Inc.
planners, engineers, architects & surveyors
P.O. Box 2210
Lawrenceville, GA 30046-2210
(770) 538-8000 or (770) 962-8000
(Fax) (770) 822-5990

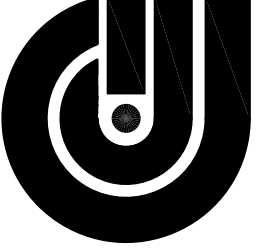


JACKSON COUNTY JAIL
555 GENERAL JACKSON DRIVE
JEFFERSON, GEORGIA 30549

SHEET TITLE	
PLAN WATER	AREAS 'A' & 'B'
DESIGN	CDL
DRAWN	XXX
CHECKED	CDL


RELEASE	
DATE	NO DESCRIPTION
10/31/07	D.E.C. / PLUMBING BID PACKAGE RELEASE
02/29/08	M.P.E. COORDINATION
02/29/08	M.P.E. COORDINATION
02/29/08	M.P.E. COORDINATION

FILE NUMBER	06086P21-2
CAD FILE NAME	A06136
PROJ. NUMBER	A06136
DATE	10-31-07

P2.1

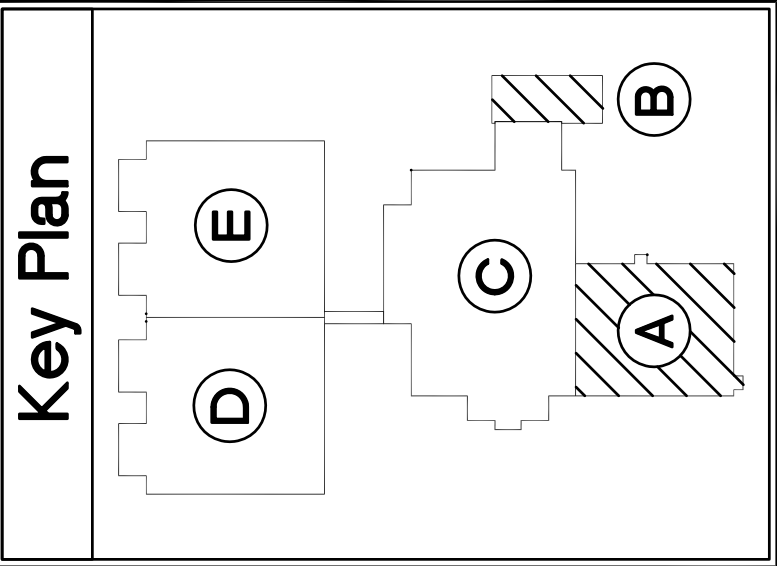

2 PLUMBING PLAN WATER - Area 'B'
SCALE 1/8" = 1'-0"

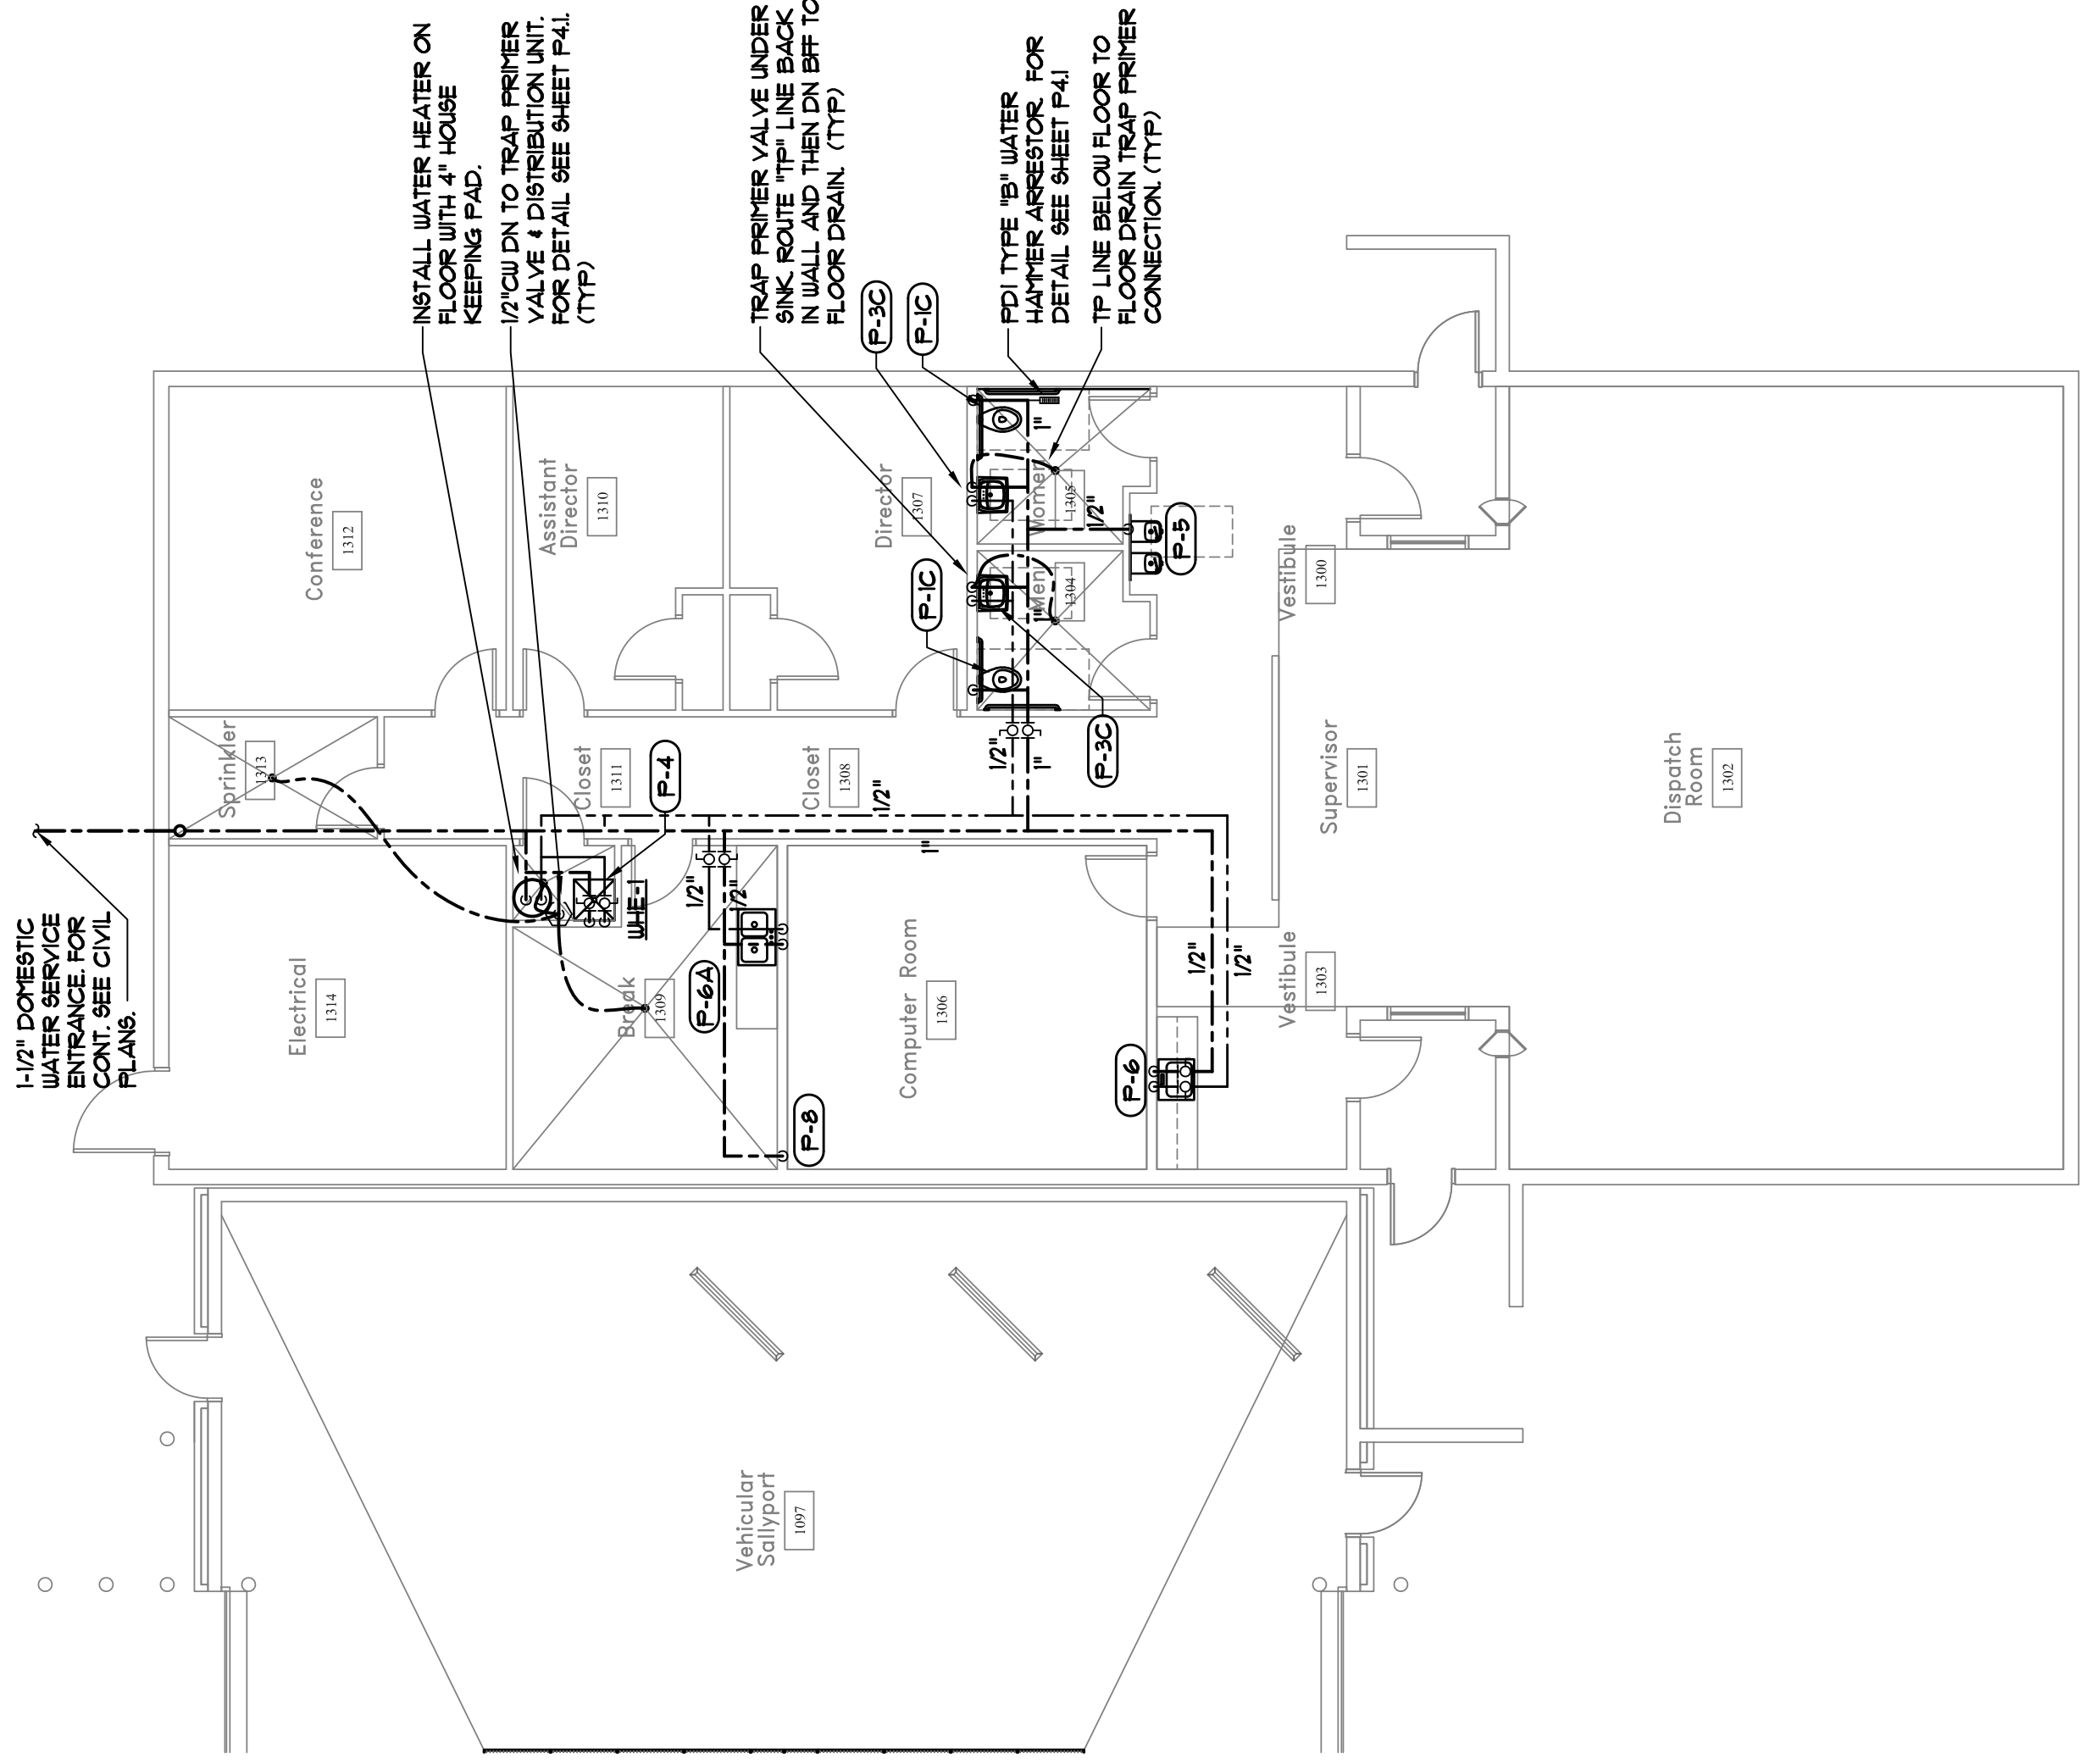

1 PLUMBING PLAN WATER - Area 'A'
SCALE 1/8" = 1'-0"

