


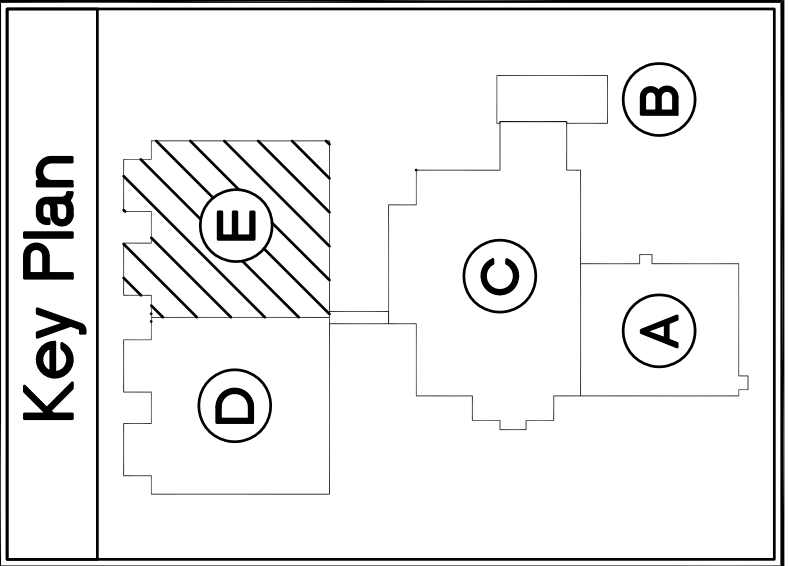


Spencer Bristol Engineering, Inc.
2880 Ilex Old Parkway NW, Suite 100
Atlanta, Georgia 30328
Tel: 770.484.1628 Fax: 770.484.0224
SEE Project No. 00006

FILE NUMBER CAD FILE NAME PROJ. NUMBER DATE		RELEASE NO DESCRIPTION DATE		SHEET TITLE DESIGN F.U.L. DRAWN F.U.L. CHECKED CDL		PROJECT JACKSON COUNTY JAIL 555 GENERAL JACKSON DRIVE JEFFERSON, GEORGIA 30549		STAMP Precision Planning, Inc. P.O. Box 2210 Lawrenceville, GA 30046-2210 (770) 338-8000 or (770) 962-8000 (Fax) (770) 822-5990	
06086P25-6 A0616 10-31-07		10/31/07 D.E.C. / PLUMBING BID PACKAGE RELEASE		PLUMBING PLAN WATER AREA 'E' MEZZANINE		Precision Planning, Inc. Planners, engineers, architects & surveyors P.O. Box 2210 Lawrenceville, GA 30046-2210 (770) 338-8000 or (770) 962-8000 (Fax) (770) 822-5990		Precision Planning, Inc. Planners, engineers, architects & surveyors P.O. Box 2210 Lawrenceville, GA 30046-2210 (770) 338-8000 or (770) 962-8000 (Fax) (770) 822-5990	
PRECISION PLANNING, INC. © 2008 ALL RIGHTS RESERVED.		THIS DOCUMENT IS THE PROPERTY OF PRECISION PLANNING, INC. AND IS NOT TO BE REPRODUCED OR TRANSMITTED IN ANY FORM OR BY ANY MEANS, ELECTRONIC OR MECHANICAL, INCLUDING PHOTOCOPYING, RECORDING, OR BY ANY INFORMATION STORAGE AND RETRIEVAL SYSTEM, WITHOUT PERMISSION FROM PRECISION PLANNING, INC. ANY UNAUTHORIZED REPRODUCTION OR TRANSMISSION OF THIS DOCUMENT IS STRICTLY PROHIBITED. PRECISION PLANNING, INC. SHALL BE RESPONSIBLE FOR THE ACCURACY OF THE INFORMATION CONTAINED HEREIN. THE USER OF THIS DOCUMENT SHALL BE RESPONSIBLE FOR THE ACCURACY OF THE INFORMATION CONTAINED HEREIN.		PRECISION PLANNING, INC. © 2008 ALL RIGHTS RESERVED.		PRECISION PLANNING, INC. Planners, engineers, architects & surveyors P.O. Box 2210 Lawrenceville, GA 30046-2210 (770) 338-8000 or (770) 962-8000 (Fax) (770) 822-5990		PRECISION PLANNING, INC. Planners, engineers, architects & surveyors P.O. Box 2210 Lawrenceville, GA 30046-2210 (770) 338-8000 or (770) 962-8000 (Fax) (770) 822-5990	



1 PLUMBING PLAN WATER - Area 'E' - Mezzanine
P-25 SCALE 1/8" = 1'-0"

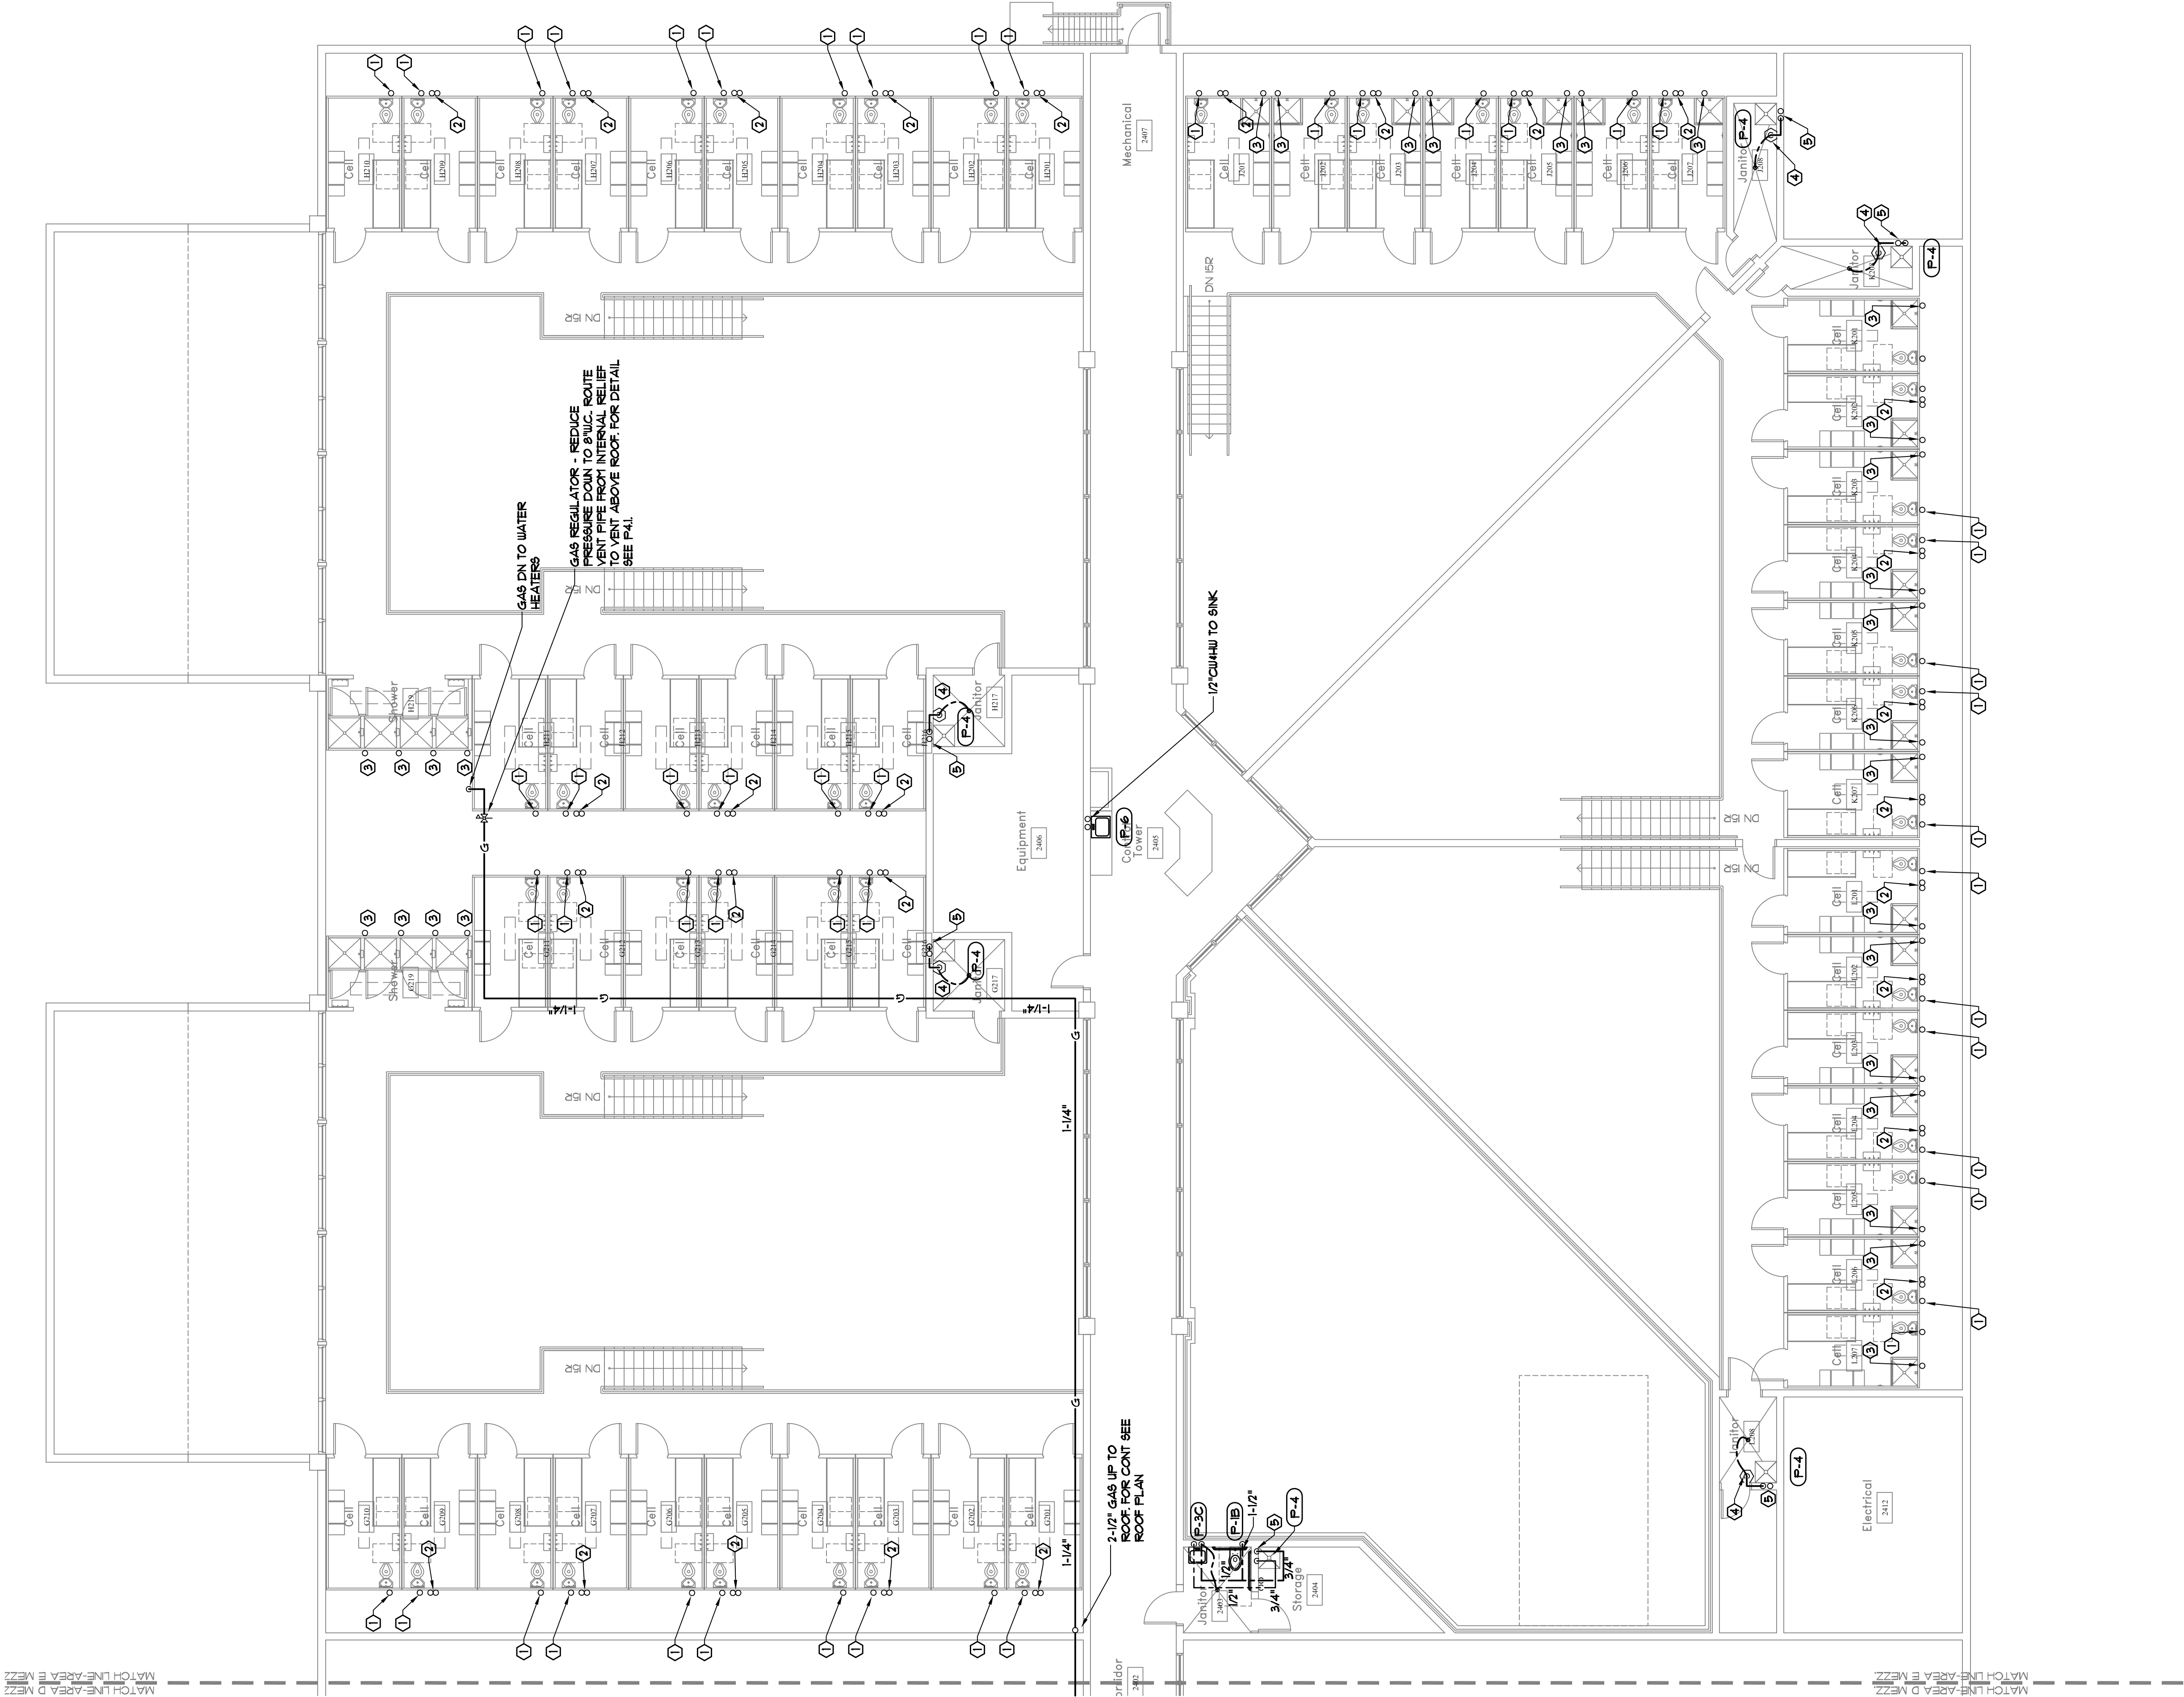

- KEYED NOTES:
- 1 1/2" CU UP AND DOWN TO SERVE WATER CLOSET FLUSH VALVES
 - 2 ROUTE CU 1/2" FROM HANGFOLD TO LAVATORY CONNECTION
 - 3 ROUTE 1/2" FROM HANGFOLD TO SHOWER CONNECTION
 - 4 1/2" CU TO TRAP PRIMER VALVE. ROUTE TP LINE DN BFF TO FLOOR DRAIN
 - 5 3/4" CU 1 CU TO HOP SINK