

LAUNDRY ELECTRICAL PLAN

JCC

DESIGN

DRAWN

CHECKED

RELEASE

DATE

NO DESCRIPTION

16

BALANCE OF REMAINING BID PACKAGE

FILE NUMBER

CAD FILE NAME

PROJ. NUMBER

DATE

STAMP

FOR BIDDING PURPOSES ONLY

PROJECT

JACKSON COUNTY, GEORGIA


JACKSON COUNTY JAIL

Precision Planning, Inc.

Planners, engineers, architects & surveyors


P.O. Box 2210
400 Pike Boulevard
Lawrenceville, GA 30046-2210
(770) 338-8000 or (770) 962-8000
(Fax) (770) 822-5990

FOR BIDDING PURPOSES ONLY - FOR BIDDING PURPOSES ONLY - FOR BIDDING PURPOSES ONLY - FOR BIDDING PURPOSES ONLY - FOR BIDDING PURPOSES ONLY

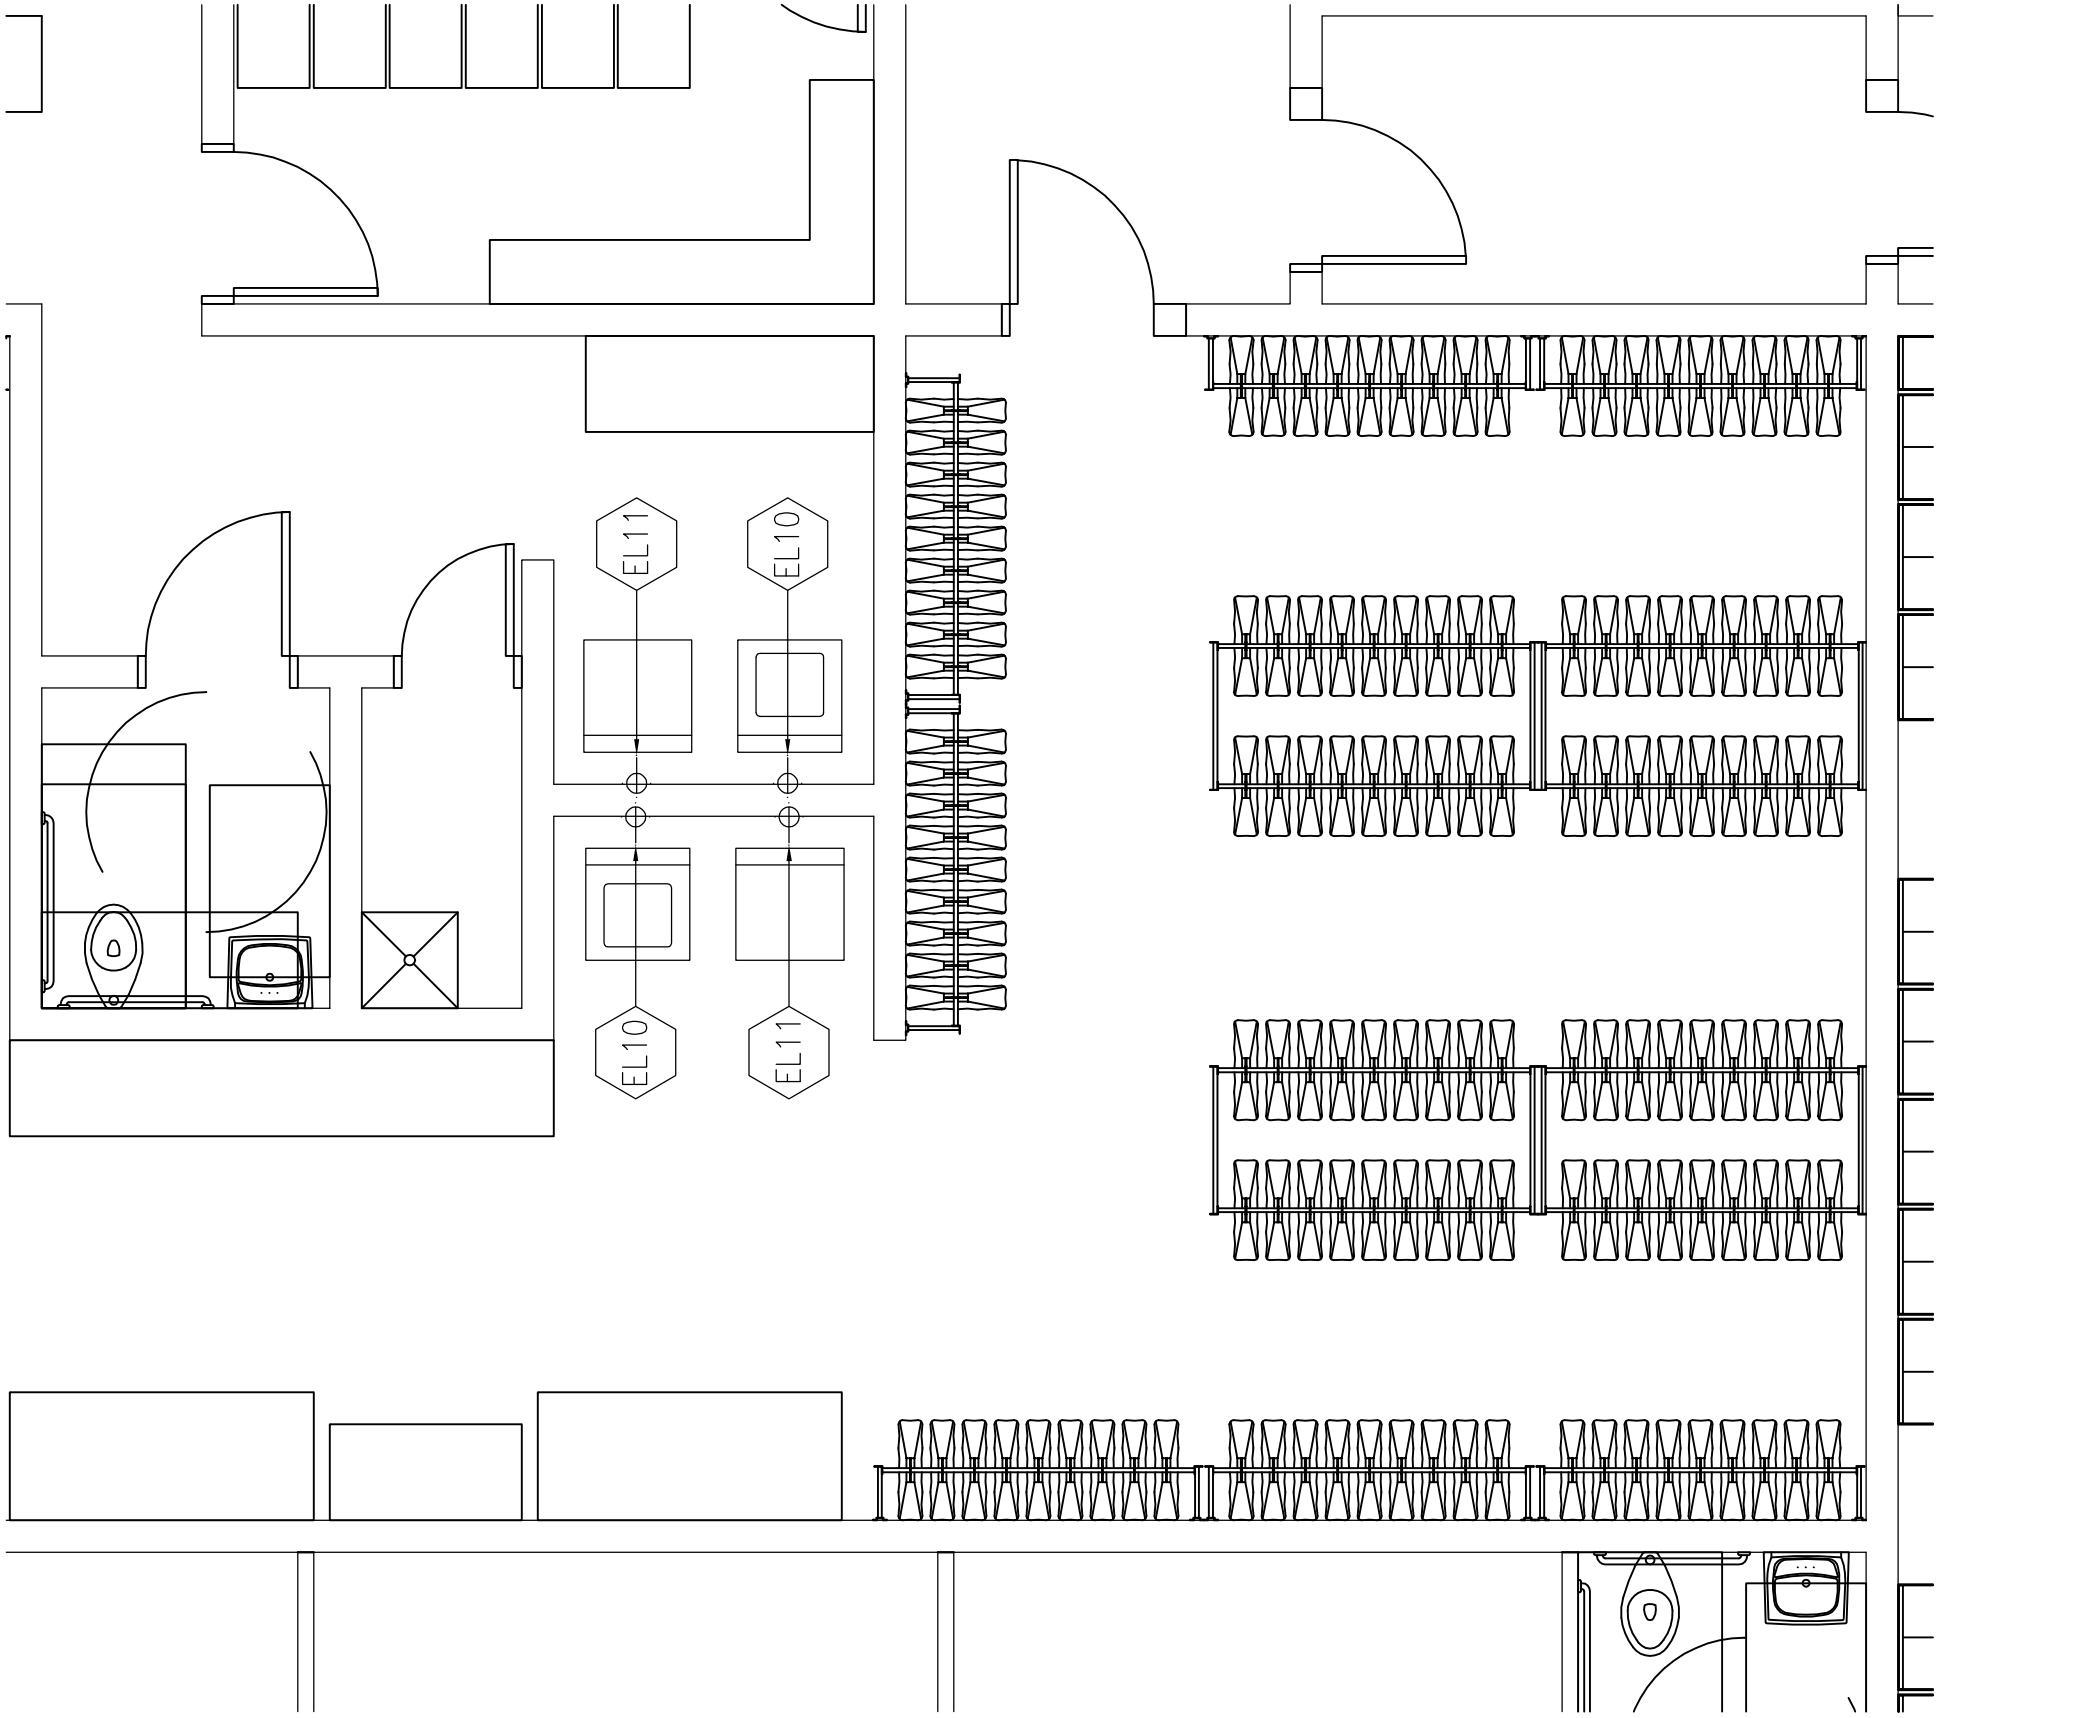

2 MEDICAL/INMATE PROPERTY
LAUNDRY EQUIPMENT ELECTRICAL PLAN
L3.1 SCALE: 1/4" = 1'-0"


ELECTRICAL LEGEND & SYMBOLS	
W	WATTS
KW	KILOWATTS
HP	HORSEPOWER
AMPS.	AMPERES
REC'T.	RECEPTACLE
V	VOLTS
PHASE	PHASE
SINGLE	SINGLE RECEPTACLE
DUPLX	DUPLX RECEPTACLE
CONV.	CONVERTIBLE RECEPTACLE
STUB-UP/SPECIAL	STUB-UP/SPECIAL
FLEXIBLE CONDUIT	FLEXIBLE CONDUIT
JUNCTION BOX	JUNCTION BOX
ABOVE FINISHED FLOOR	ABOVE FINISHED FLOOR

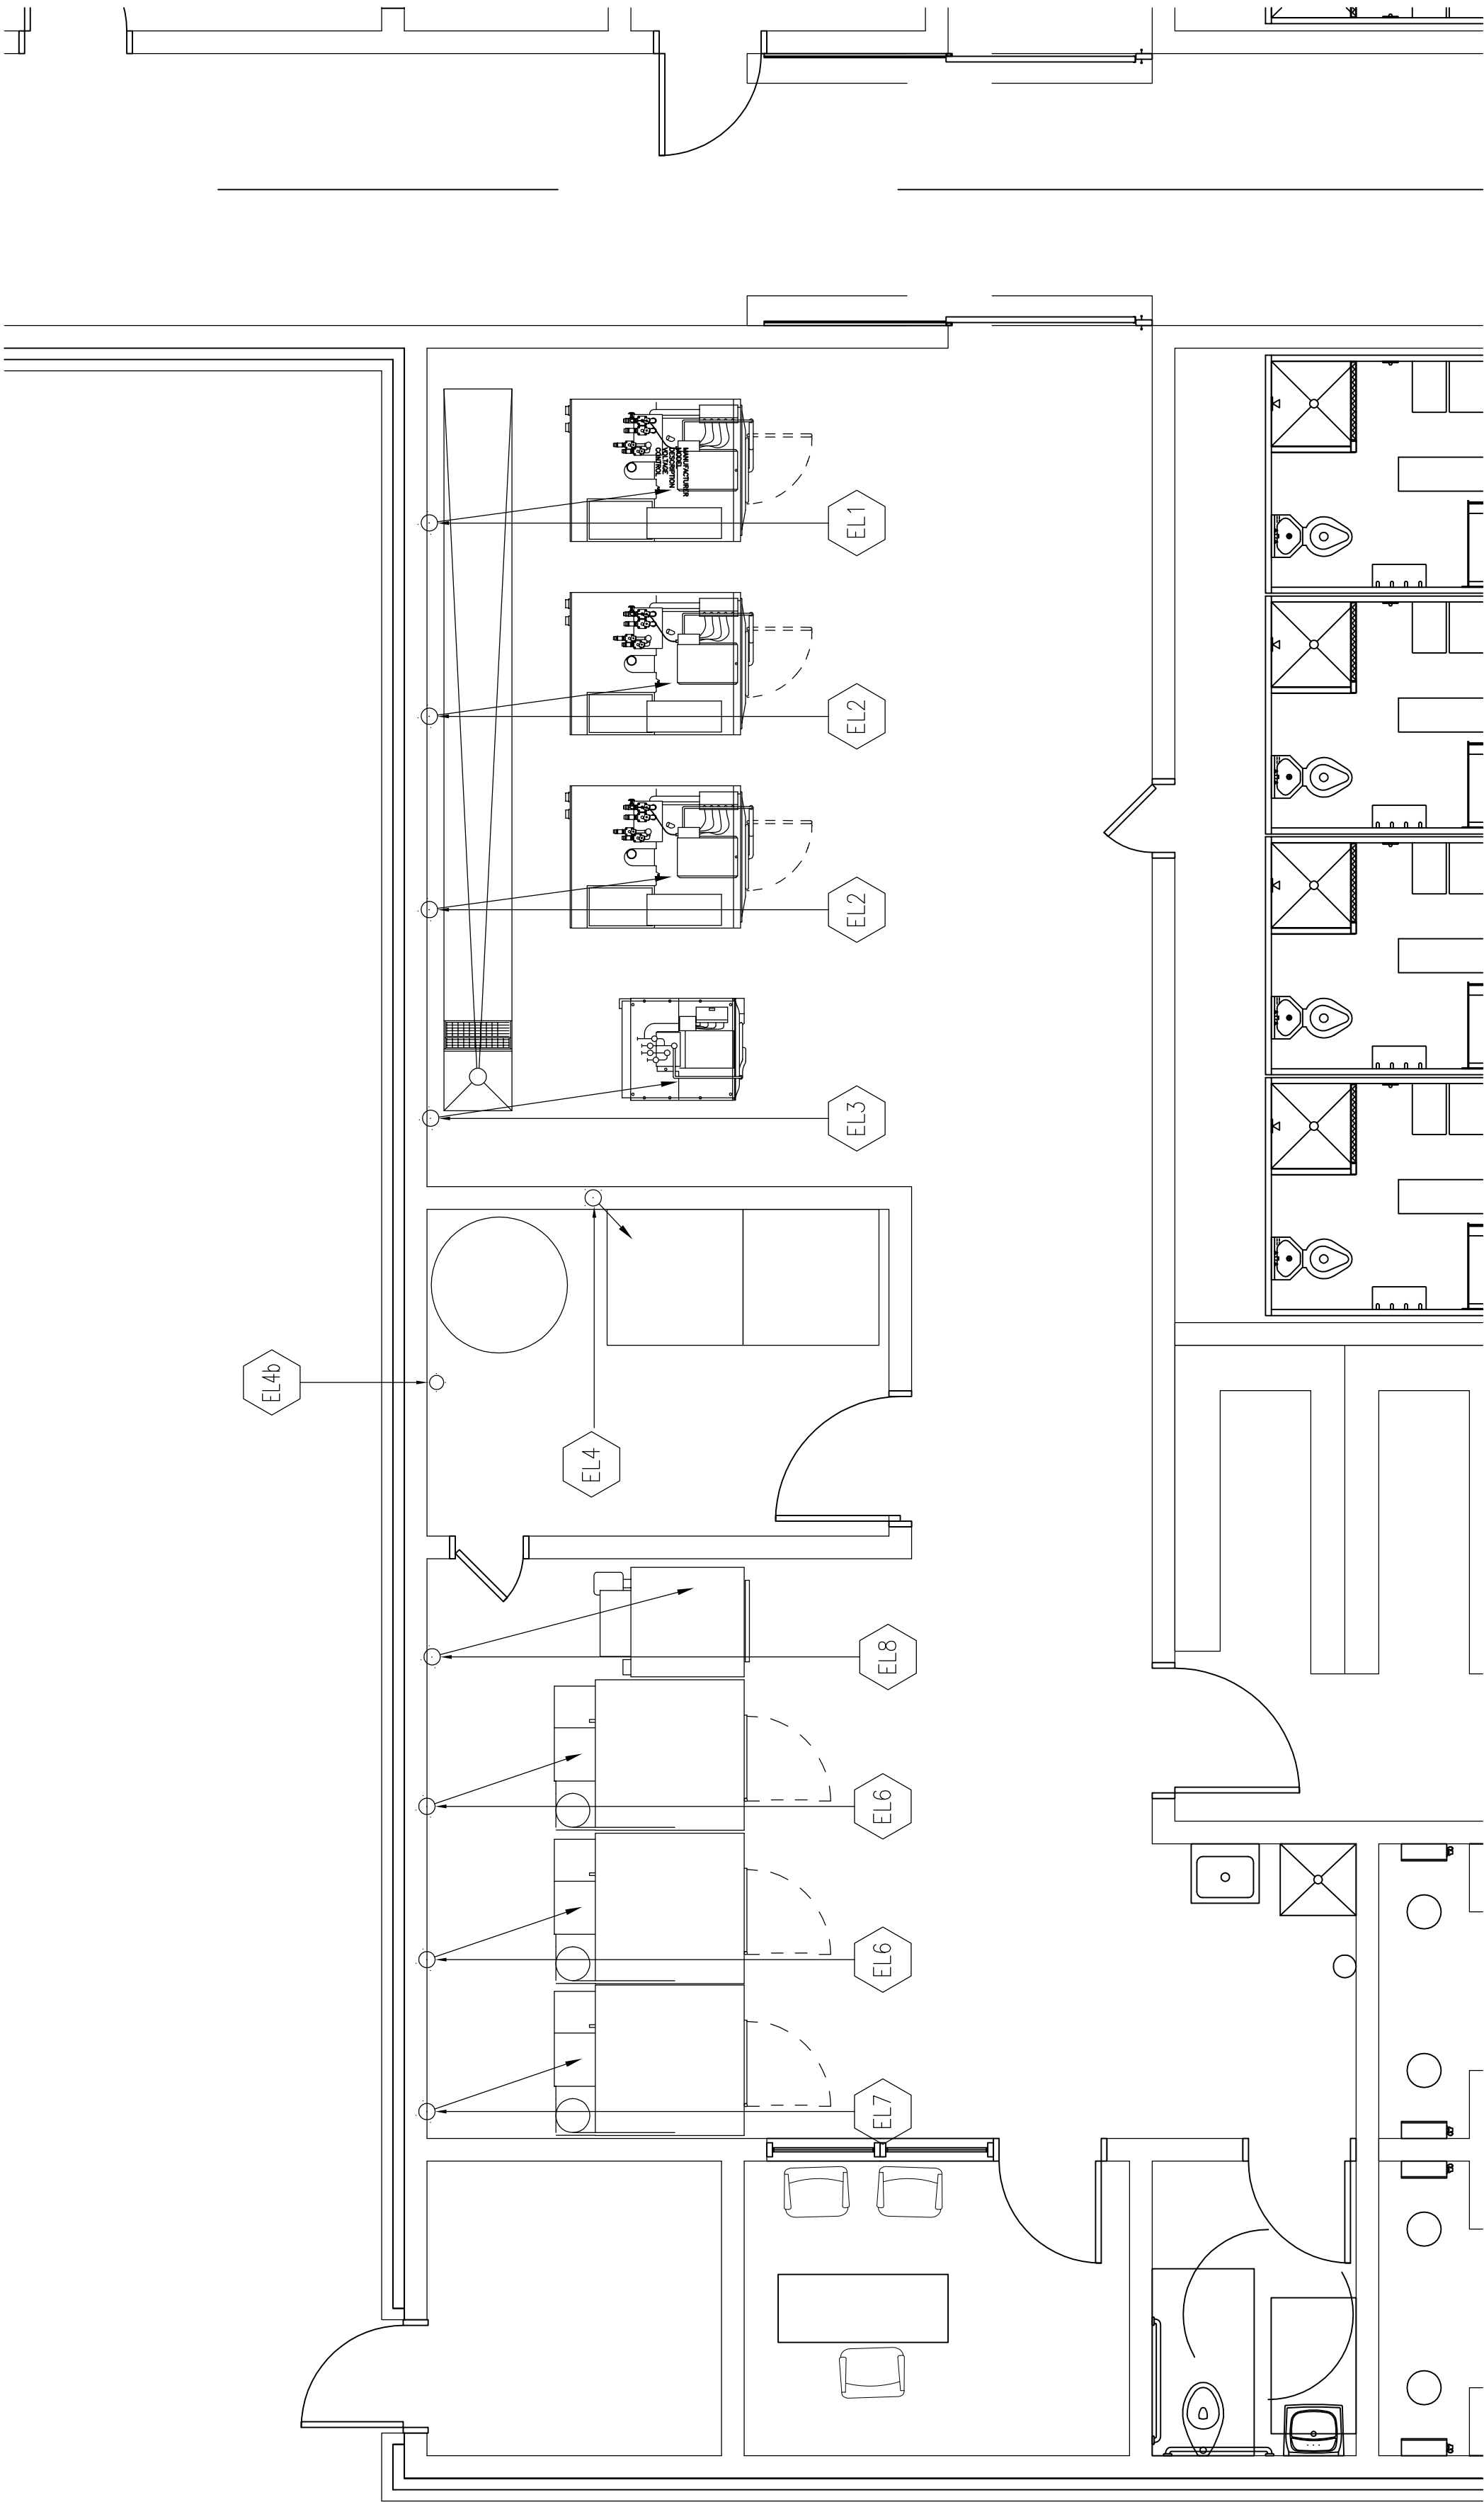

1 LAUNDRY EQUIPMENT ELECTRICAL PLAN
L3.1 SCALE: 1/4" = 1'-0"

ELECTRICAL CONNECTION NOTES:

- EL1 - 10 H.P., 8.0 AMPS, 480V/60/3 PHASE SERVICE OUT OF WALL, 72" AFF, TO DISCONNECT SWITCH, CONNECT TO TERMINALS ON WASHER/EXTRACTOR 72" AFF (TERMINATE FOR FUTURE USE)
- EL2 - 10 H.P., 8.0 AMPS, 480V/60/3 PHASE SERVICE OUT OF WALL, 72" AFF, TO DISCONNECT SWITCH, CONNECT TO TERMINALS ON WASHER/EXTRACTOR 72" AFF
- EL3 - 19.0 AMPS, 208V/60/3 PHASE SERVICE OUT OF WALL, 72" AFF, TO DISCONNECT SWITCH, CONNECT TO TERMINALS ON WASHER/EXTRACTOR (30 AMP, 3 POLE CIRCUIT BREAKER FOR 3 PHASE SERVICE REQUIRED)
- EL4 - 60.0 AMPS, 208V/60/1 PHASE SERVICE OUT OF WALL, 72" AFF, CONNECT TO TERMINALS ON OZONE GENERATOR SYSTEM
- EL4b - NOTE: PROVIDE (2) 5.0 AMP 120V/60/1 PHASE DUPLEX RECPT. AND (3) 10.0 AMP 120V/60/1 PHASE DUPLEX RECPT. FOR CHEMICAL PUMPS, 72" AFF
- EL6 - 6.7 AMPS, 480V/60/3 PHASE SERVICE OUT OF WALL, 72" AFF, TO DISCONNECT SWITCH, CONNECT TO TERMINALS ON DRYER
- EL7 - 6.7 AMPS, 480V/60/3 PHASE SERVICE OUT OF WALL, 72" AFF, TO DISCONNECT SWITCH, CONNECT TO TERMINALS ON DRYER
- EL8 - 34 H.P., (21) 1/3 H.P., 6.3 AMPS, 208V/60/3 PHASE SERVICE OUT OF WALL, 72" AFF, TO DISCONNECT SWITCH, CONNECT TO TERMINALS ON DRYER
- EL10 - 1/2 H.P., 15.0 AMPS, 120V/60/1 PHASE RECPT., FLUSH W/ WALL, 24" AFF.
- EL11 - 1/3 H.P., 15.0 AMPS, 120V/60/1 PHASE RECPT., FLUSH W/ WALL, 24" AFF.

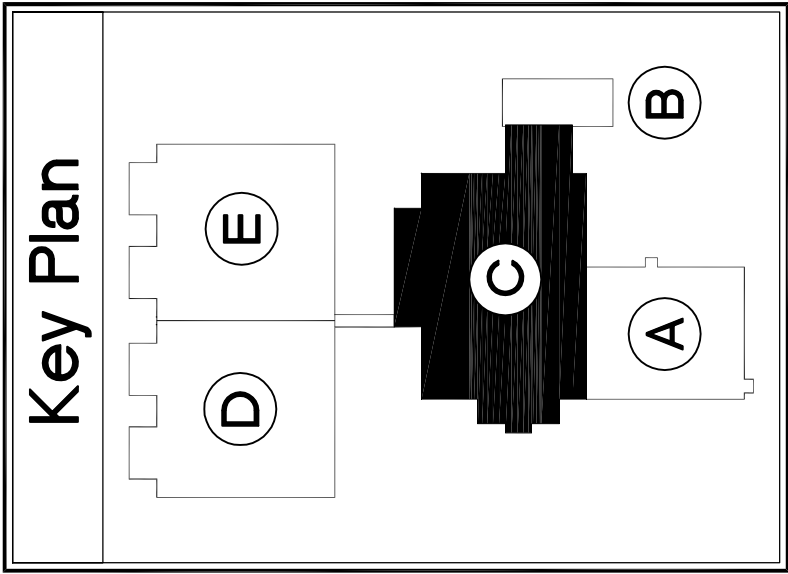

CAMACHO ASSOCIATES, INC.
FOOD FACILITIES DESIGNERS/CONSULTANTS
ATLANTA, GEORGIA (770) 582-1144

IT IS THE INTENT OF THIS DRAWING TO SHOW ELECTRICAL CONNECTION POINTS. FOR FINAL ROUGH-IN DRAWINGS, SEE CONTRACTORS DETAIL SHOP DRAWINGS. ALLOWANCES SHALL BE MADE FOR TRIM, FITTINGS AND ACCESSORIES.