



Spencer Bristol Engineering, Inc.  
5000 Iris Oak Parkway NW, Suite 400  
Atlanta, Georgia 30328  
Tel. 770.444.6228 Fax 770.444.6224  
SBE Project No. 000586

STAMP

Precision Planning, Inc.

planners, engineers, architects & surveyors

P.O. Box 2210  
400 Pike Boulevard  
Lawrenceville, GA 30046-2210  
(770) 338-8000 or (770) 962-8000  
(Fax) (770) 822-5990

PROJECT

JACKSON COUNTY JAIL  
555 GENERAL JACKSON DRIVE  
JEFFERSON, GEORGIA 30549

SHEET TITLE

MECHANICAL  
PLAN - AREA "D"  
MEZZANINE

DESIGN  
CDL  
ECH  
CHECKED  
CDL

RELEASE

DATE  
10-31-07




NO. DESCRIPTION  
12/21/07

MECHANICAL / ELECTRICAL BID PACKAGE RELEASE

MECH./ELEC. BID PACKAGE ADDENDUM #1

M.P.E. COORDINATION  
02-29-08

FILE NUMBER  
06086MIS-6  
CAD FILE NAME  
A06136  
PROJ. NUMBER  
10-31-07  
DATE

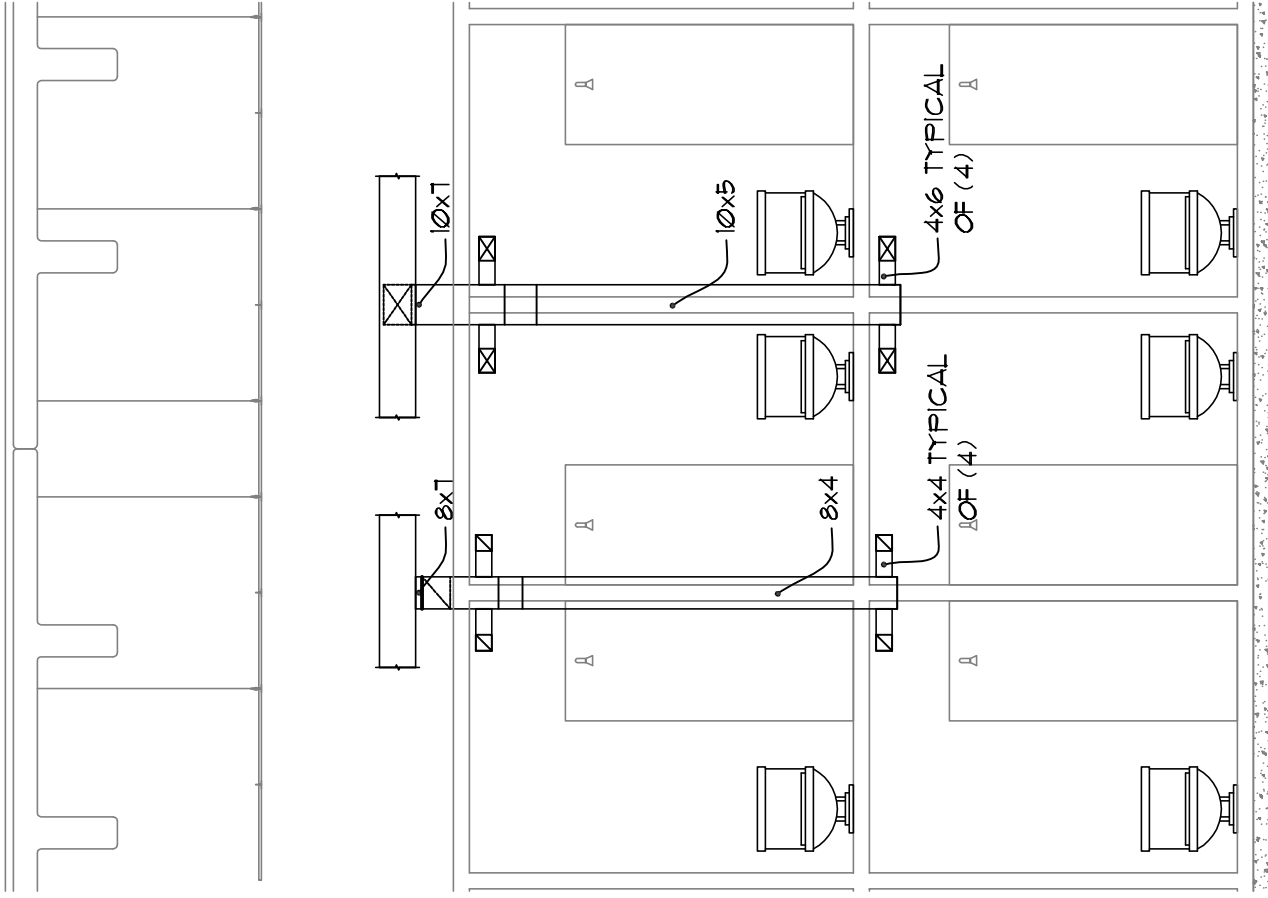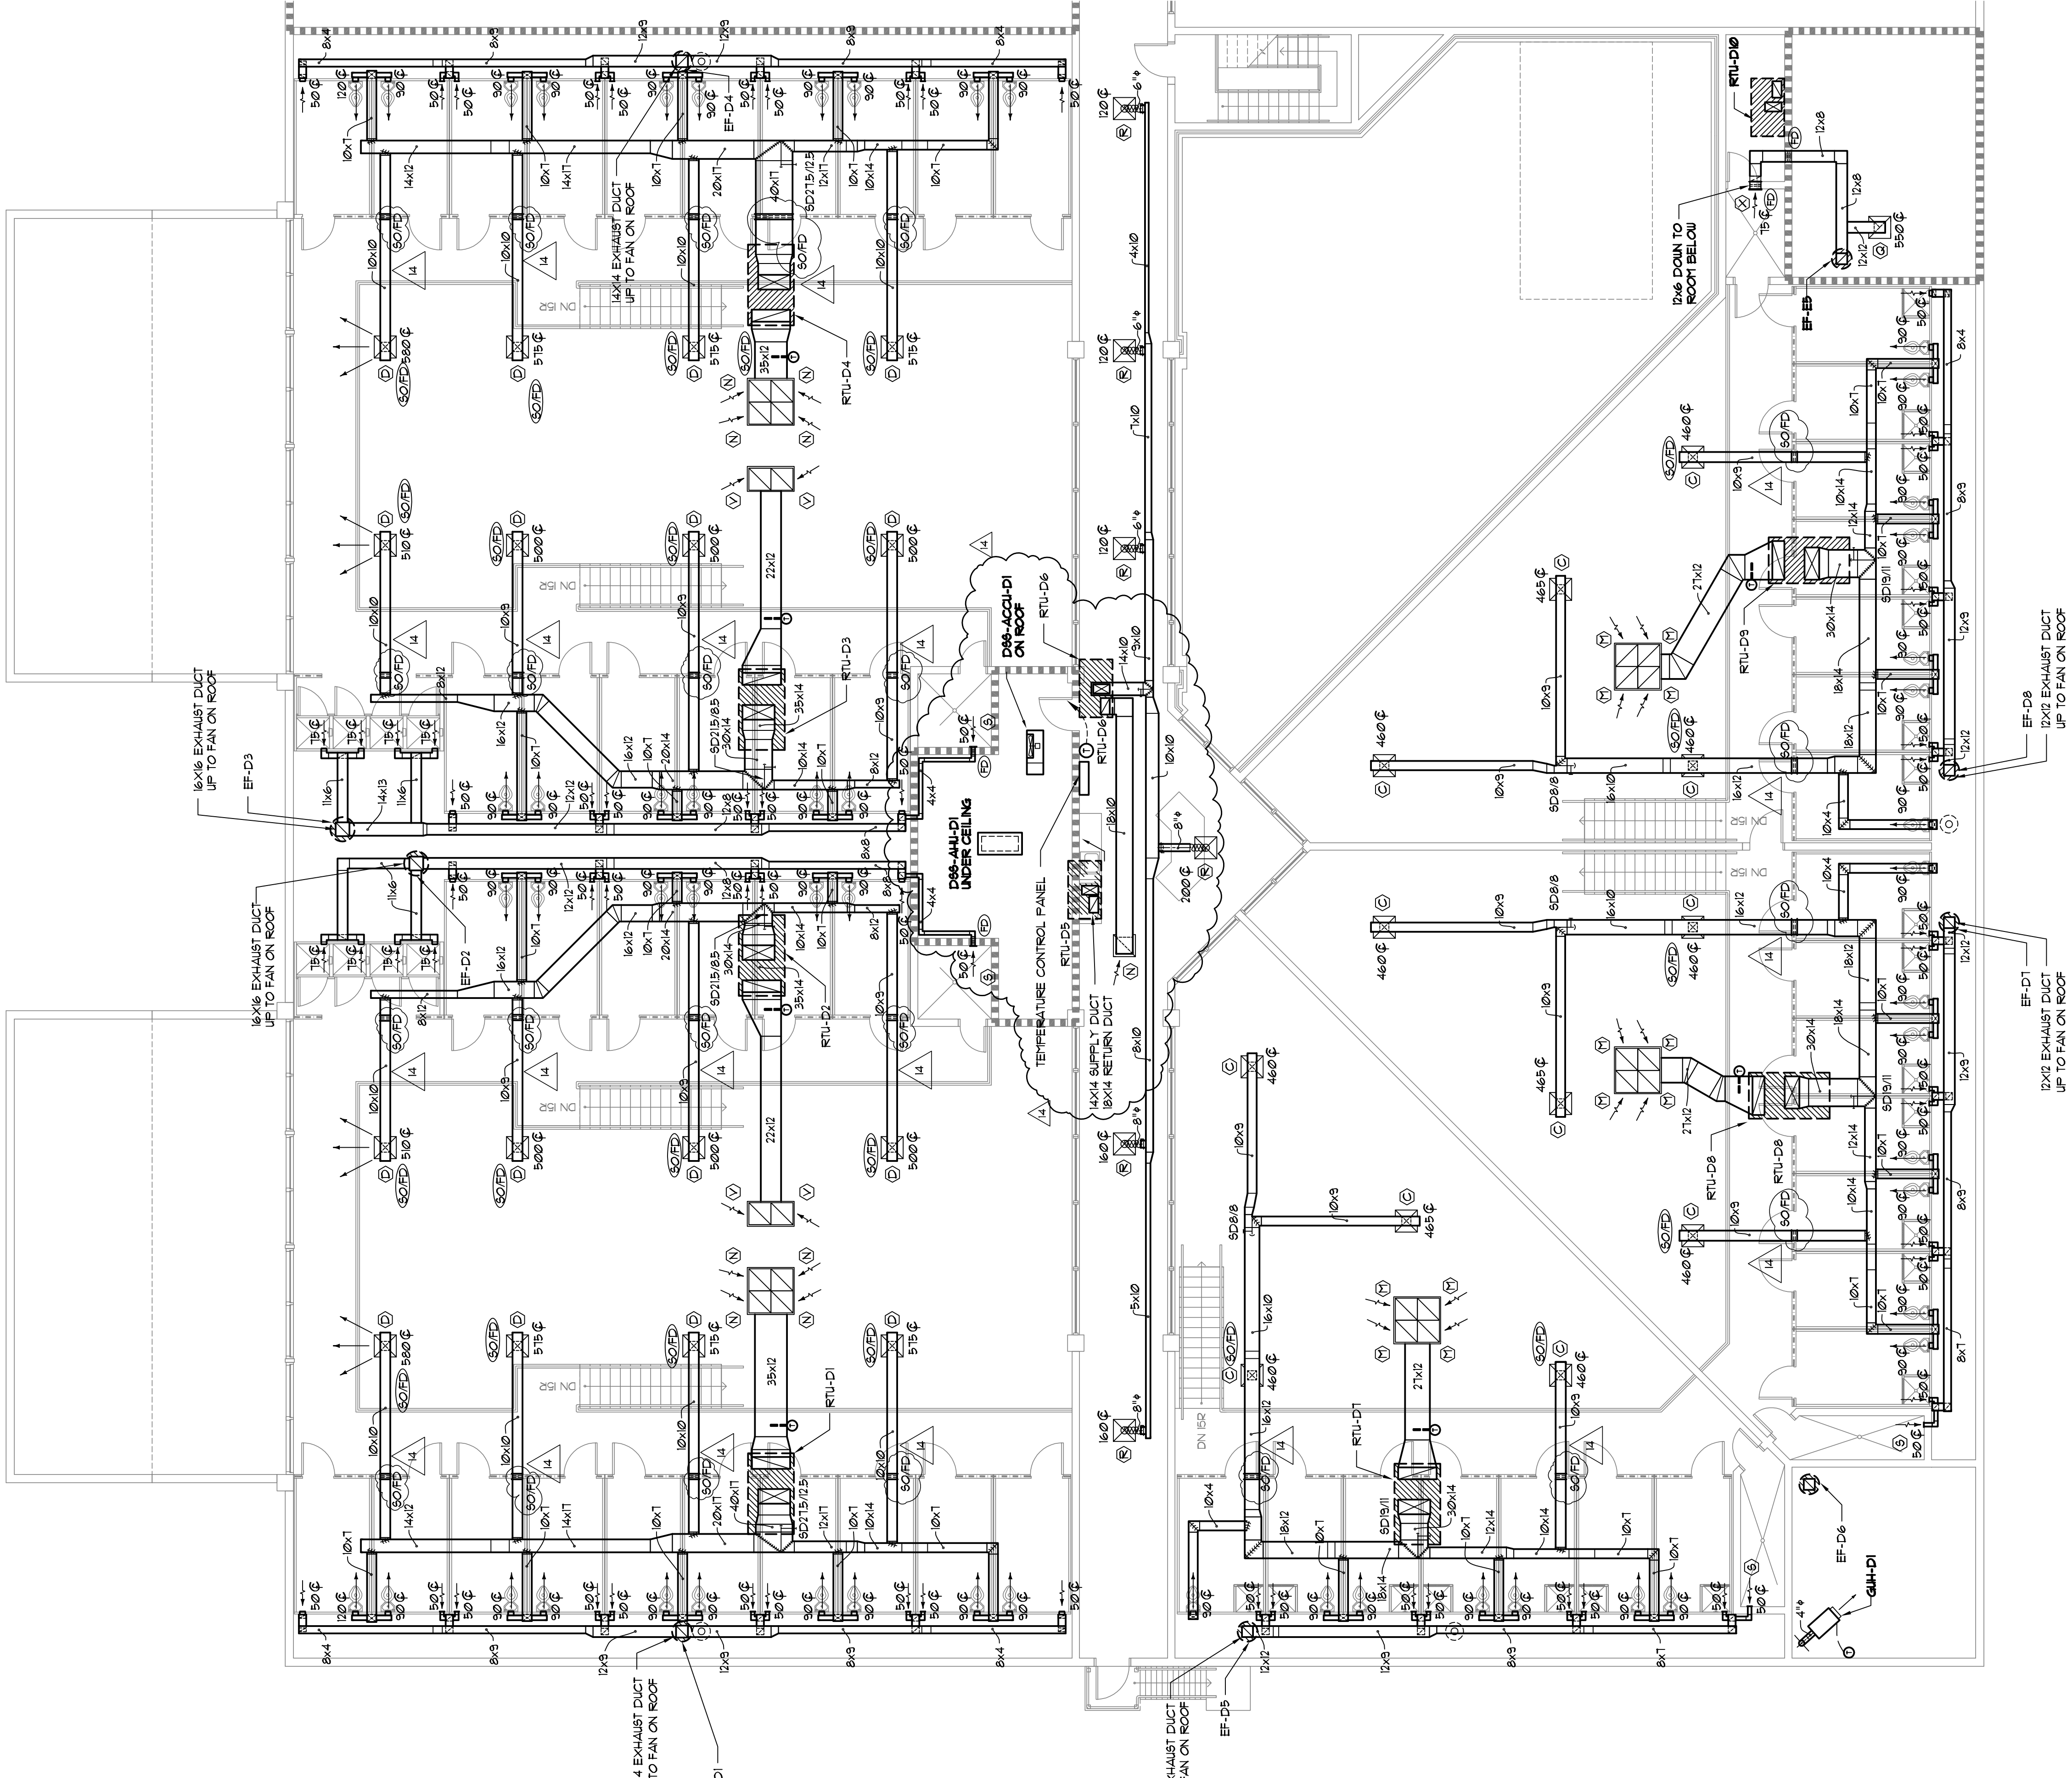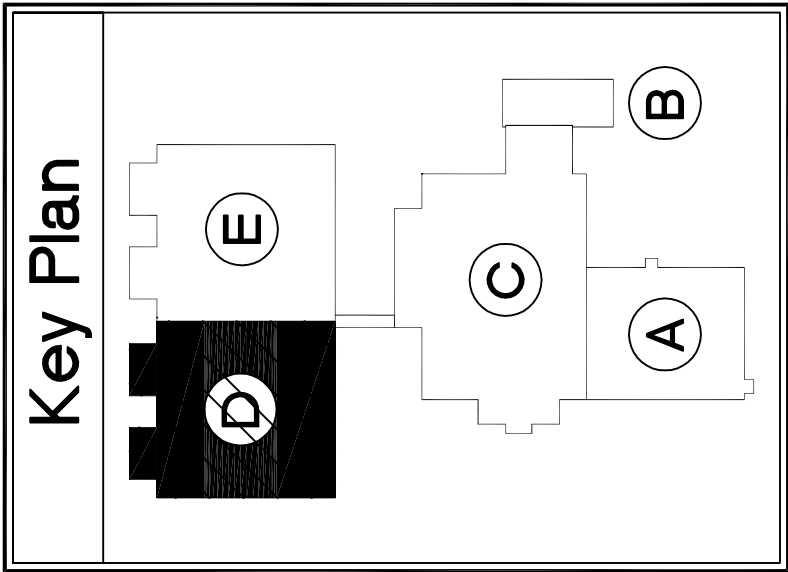

NOTE: THE SUPPLY RISER AND EXHAUST GABLE FOR EACH CELL SHALL BE INTEGRAL TO THE FREE MANUFACTURED CELL MODULE EXACT CONNECTION DETAILING SHALL BE COORDINATED WITH MANUFACTURER COORDINATE CONNECTION SIZE WITH MANUFACTURER

2 TYPICAL CELL BLOCK DUCT RISER  
SCALE 1/4" = 1'-0"

1 MECHANICAL PLAN - Area 'D' - Mezzanine  
SCALE 1/8" = 1'-0"