



PRECISION PLANNING, INC.
P.O. Box 2210
400 Pike Boulevard
Lawrenceville, GA 30046-2210
(770) 338-8000 or (770) 962-8000
(Fax) (770) 822-5990
planners, engineers, architects & surveyors

STAMP

JACKSON COUNTY JAIL
555 GENERAL JACKSON DRIVE
JEFFERSON, GEORGIA 30549

PROJECT

MECHANICAL
PLAN - AREA "E"
MEZZANINE

DESIGN
CDL

DRAWN
ECH

CHECKED
CDL

SHEET TITLE

RELEASE

NO DESCRIPTION

DATE 12/21/07

MECHANICAL / ELECTRICAL BID PACKAGE RELEASE

MECH./ELEC. BID PACKAGE ADDENDUM #1

M.P.E. COORDINATION


02-29-08 1A

FILE NUMBER
06086MIS-6

CAD FILE NAME
A06136

PROJ. NUMBER
10-31-07



DATE
10-31-07

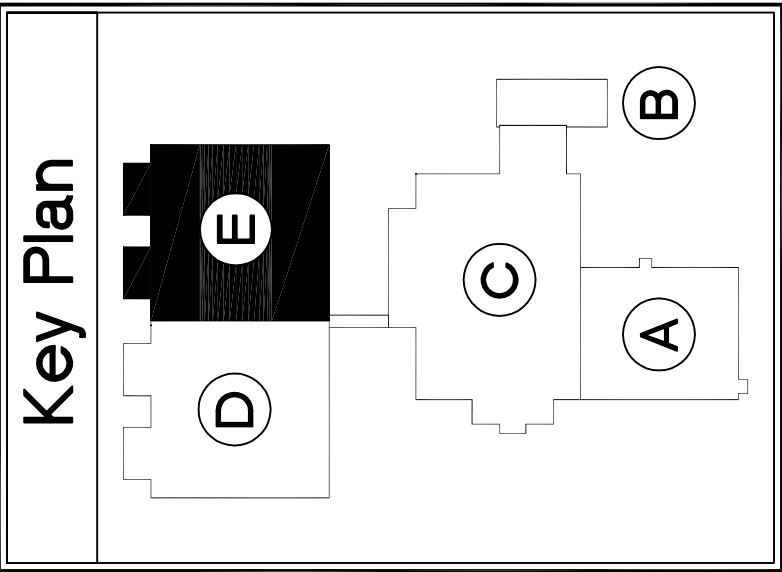

2 TYPICAL CELL BLOCK DUCT RISER

SCALE 1/4" = 1'-0"

NOTE: THE SUPPLY RISER AND EXHAUST RISER FOR EACH CELL SHALL BE INTEGRAL TO THE FREE MANUFACTURED CELL MODULE. EACH CONNECTION SHALL BE MADE IN ACCORDANCE WITH THE COORDINATE CONNECTION SIZE WITH MANUFACTURER.

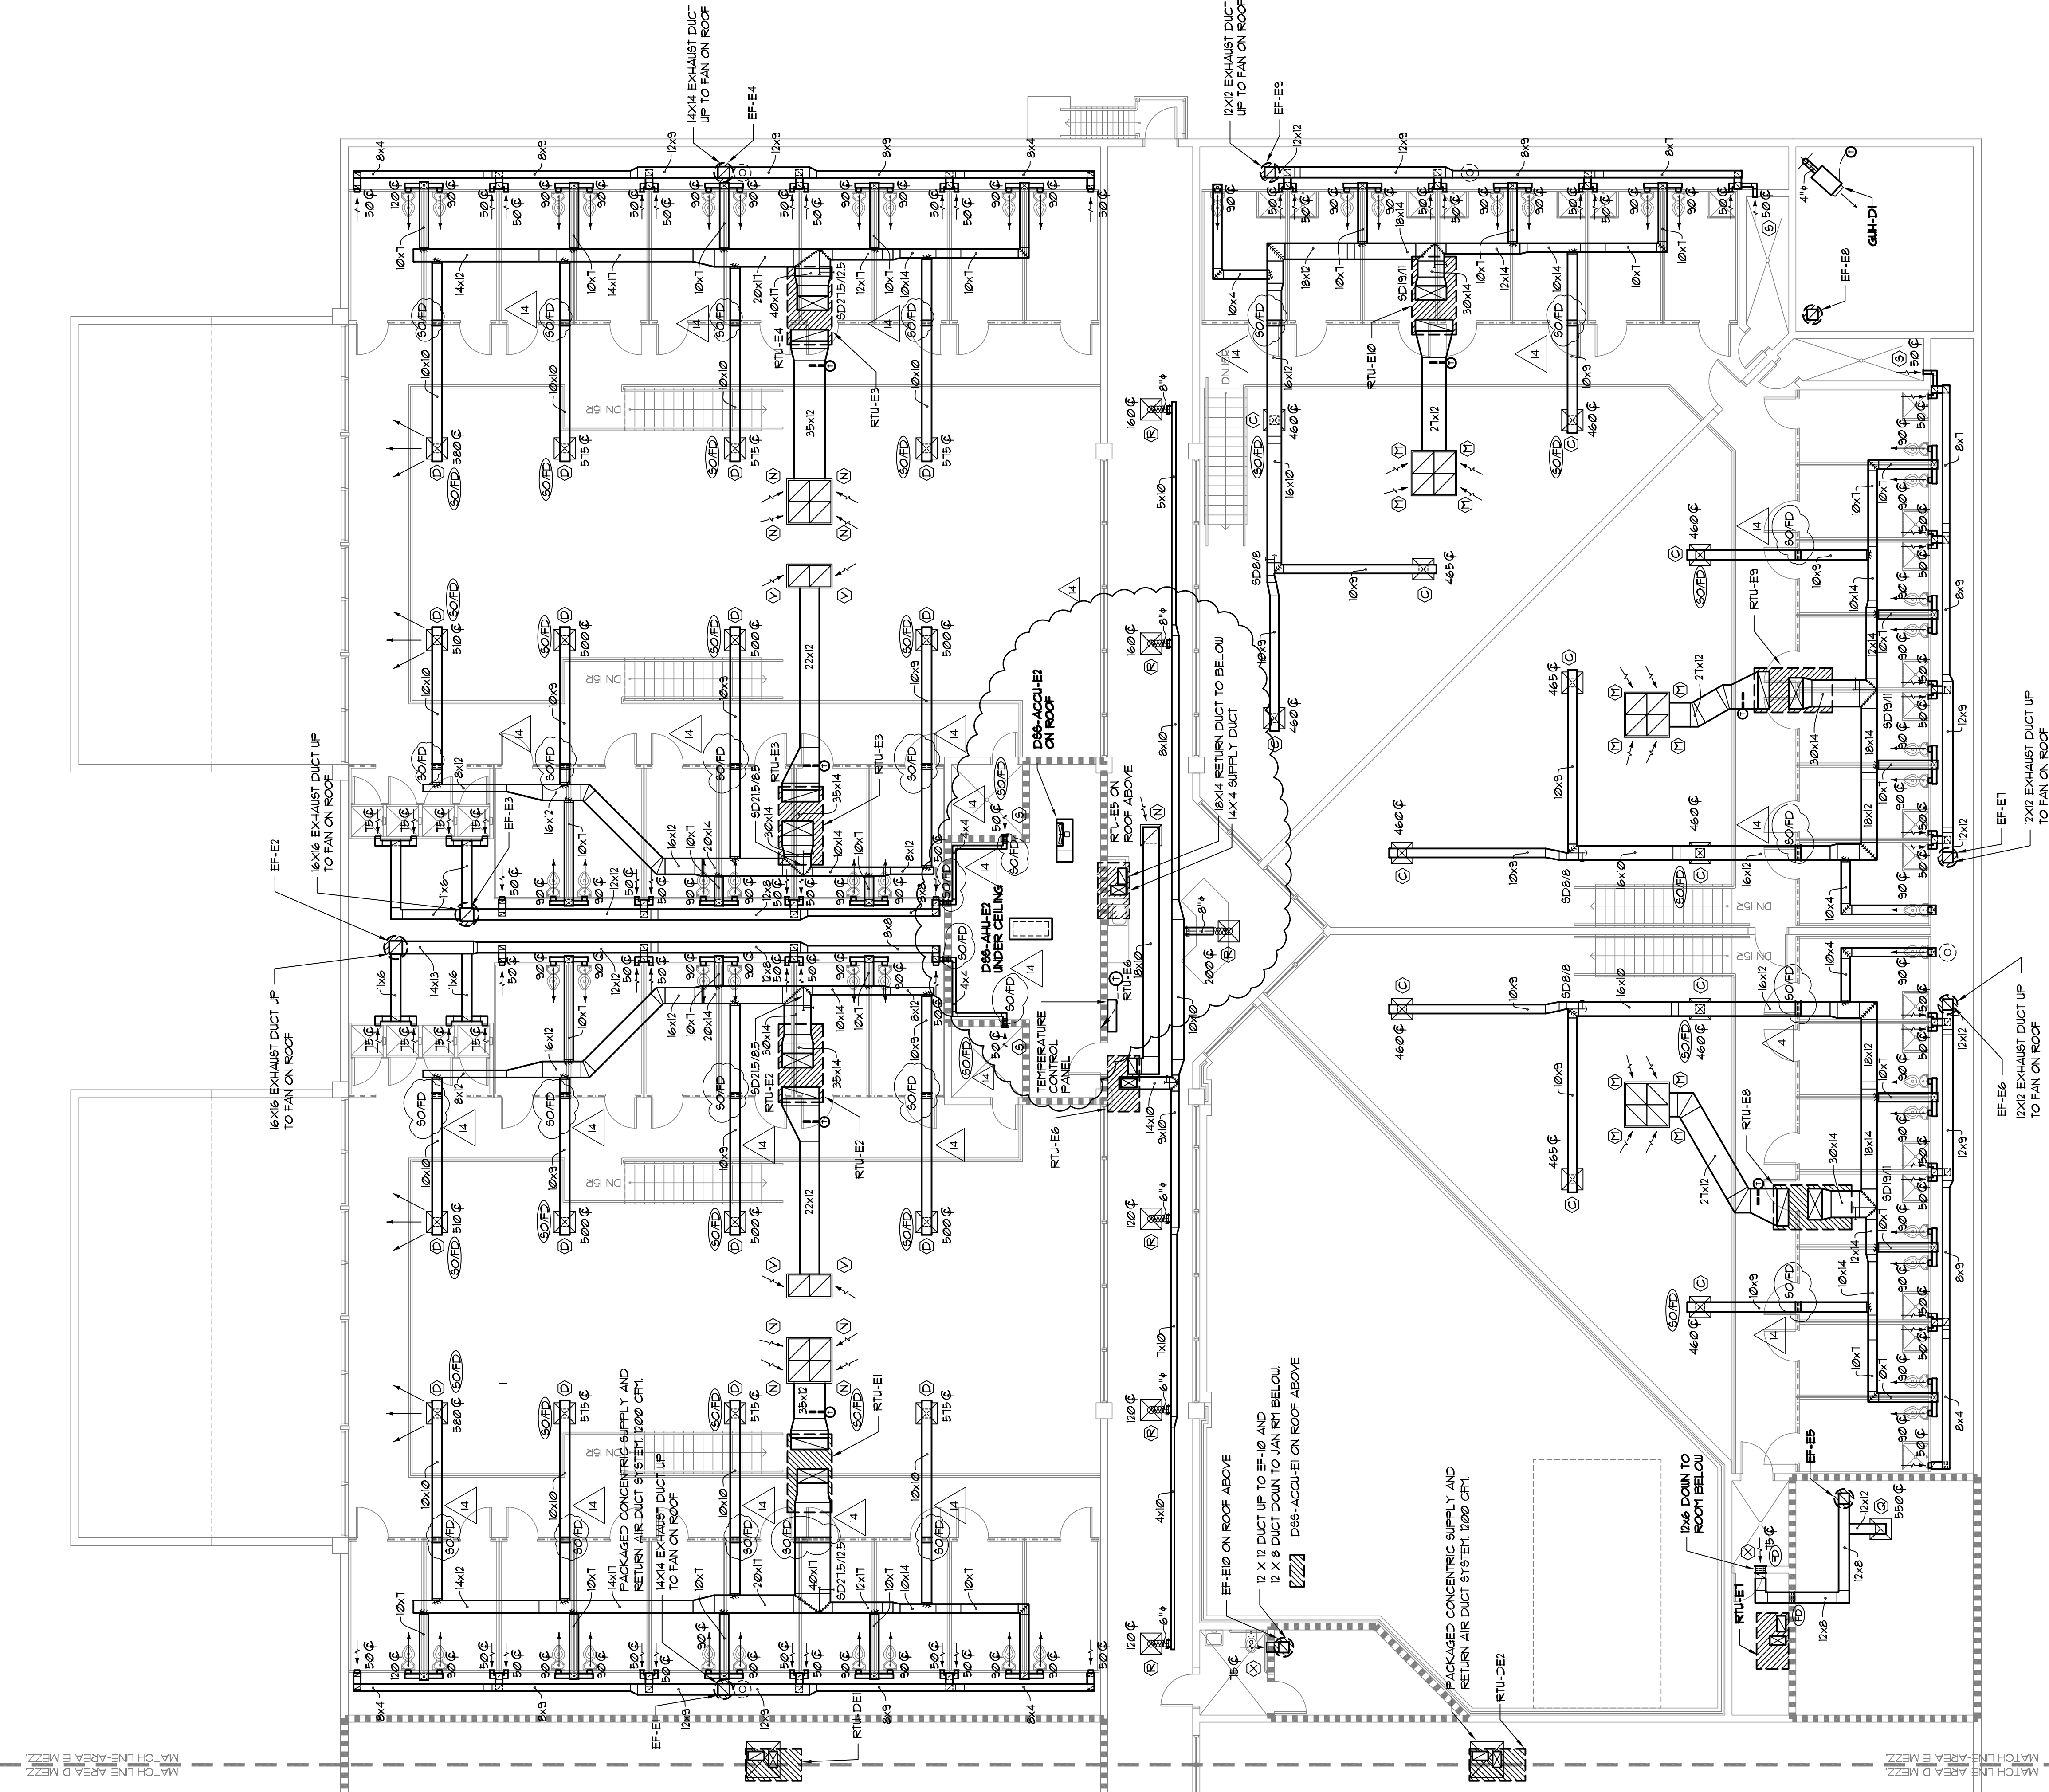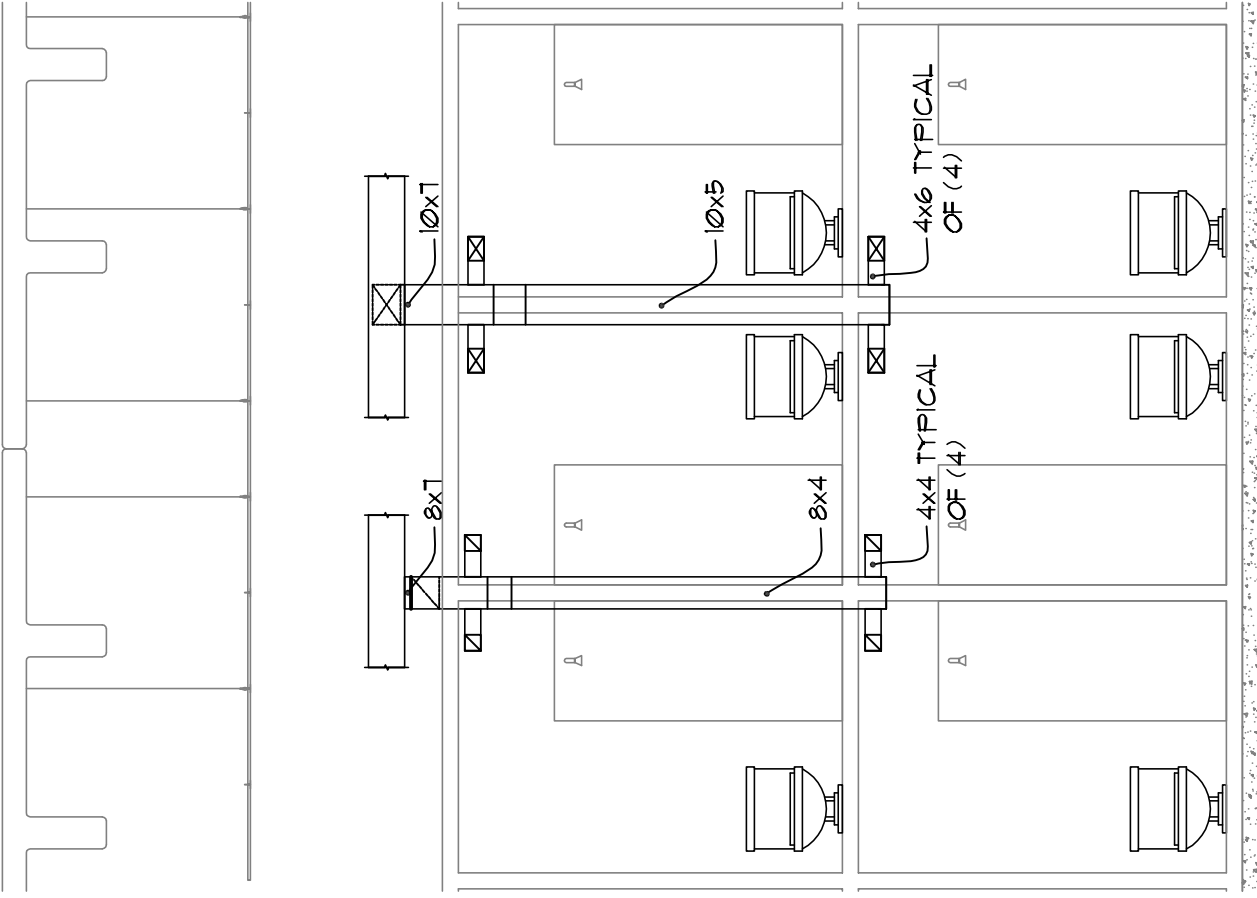

1 MECHANICAL PLAN - Area 'E' - Mezzanine

SCALE 1/8" = 1'-0"