



Spencer Bristol Engineering, Inc.  
3000 U.S. 90A Parkway NW, Suite 400  
Atlanta, Georgia 30328  
Tel. 770.444.6228 Fax 770.444.6224  
SHE Project No. 000086

PROJECT

JACKSON COUNTY JAIL  
555 GENERAL JACKSON DRIVE  
JEFFERSON, GEORGIA 30549

SHEET TITLE

PLAN - AREA "E"  
LOWER LEVEL

RELEASE

MECHANICAL / ELECTRICAL BID PACKAGE RELEASE  
MECH./ELEC. BID PACKAGE ADDENDUM #1  
M.P.E. COORDINATION  
02-29-08  
12/21/07  
10-31-07

FILE NUMBER

06086M13-4

CAD FILE NAME

A06136

PROJ. NUMBER

06086M13-4

DATE

10-31-07

DATE

12/21/07

NO. DESCRIPTION

MECHANICAL / ELECTRICAL BID PACKAGE RELEASE

DESIGN

CDL

DRAWN

ECH



CHECKED

CDL

STAMP

Precision Planning, Inc.

Planners, engineers, architects & surveyors  
P.O. Box 2210  
400 Pike Boulevard  
Lawrenceville, GA 30046-2210  
(770) 338-8000 or (770) 962-8000  
(Fax) (770) 822-5990

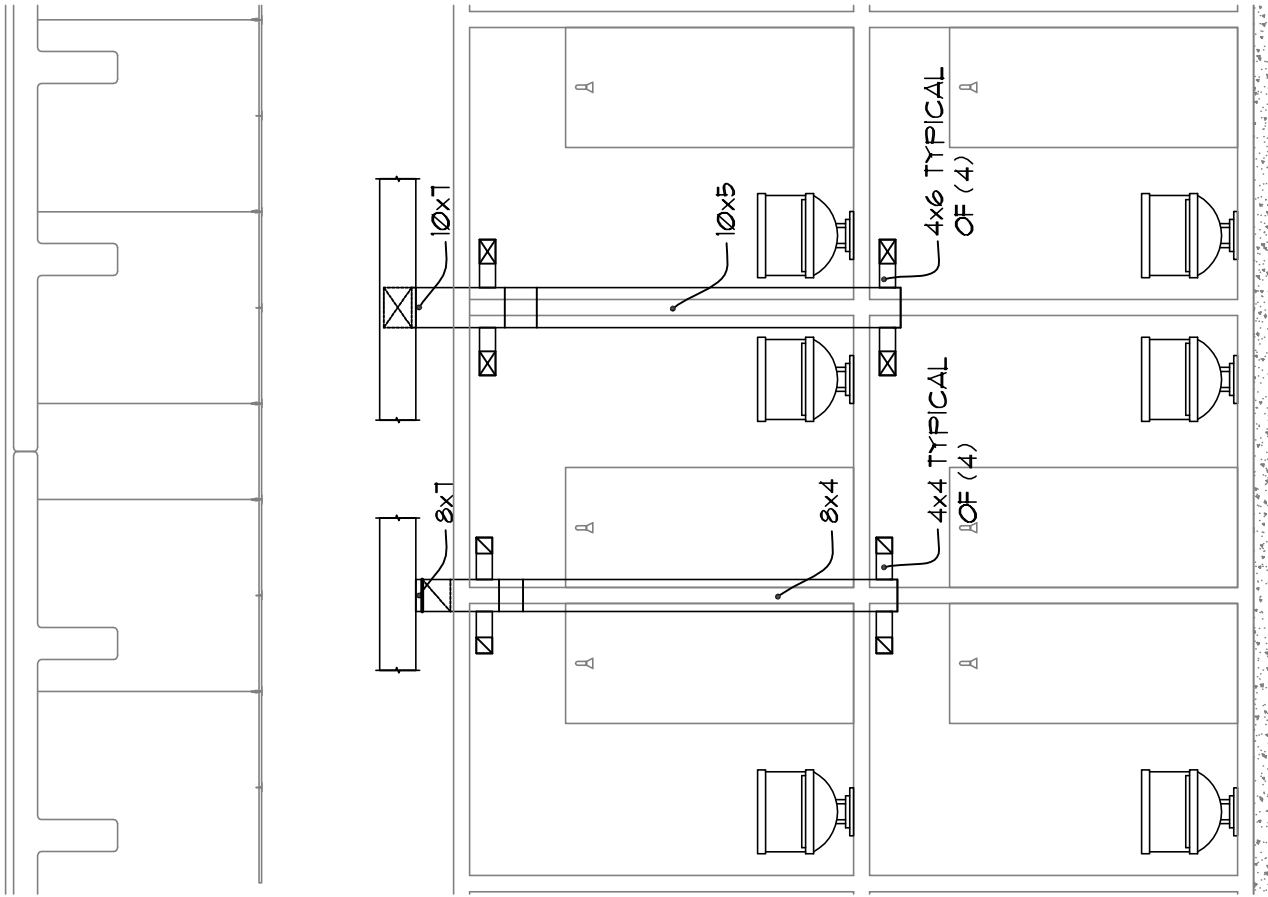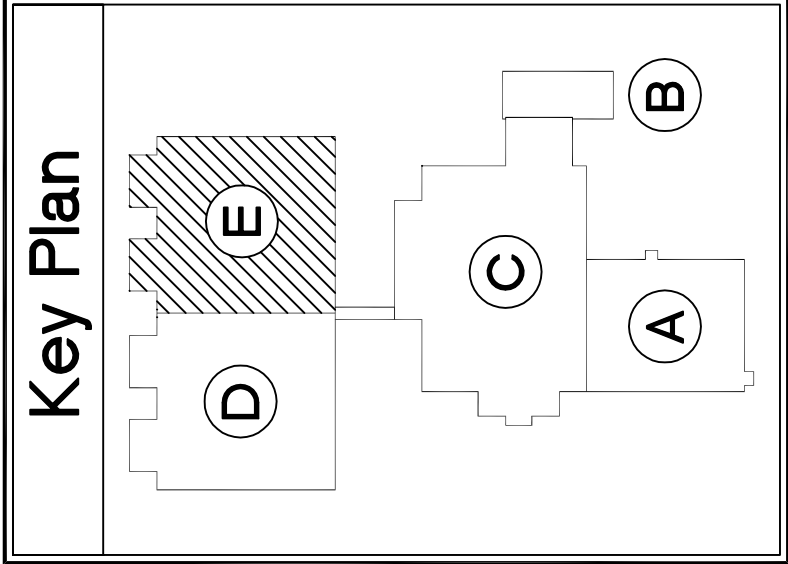

2 TYPICAL CELL BLOCK DUCT RISER  
SCALE 1/4" = 1'-0"

1 MECHANICAL PLAN - Area "E" - Lower level  
SCALE 1/8" = 1'-0"

