

[illegible]

SHEET TITLE		
GER	JBL	JBL
CHECKED	DRAWN	DESIGN
ELECTRICAL PLAN		
AREA 'D'		

PROJECT



Precision Planning, Inc.
planners, engineers, architects & surveyors
P.O. Box 2210
400 Pike Boulevard
Lawrenceville, GA 30046-2210
(770) 338-8000 or (770) 962-8000
(Fax) (770) 822-5990



PRECISION PLANNING, INC.
..ALL RIGHTS RESERVED.


PROVIDE IN EACH CONDUIT NOT OTHERWISE NOTED, TWO #12 AND ONE #16 GROUND.
THIS INCLUDES ALL SWITCH, LEGS, LIGHTING AND RECEPTACLE CONDUITS.
UNLESS OTHERWISE INDICATED, EXTEND 3/4" FROM EACH TELEPHONE OUTLET AND
STUB UP ABOVE AN ACCESSIBLE CEILING.

UNLESS OTHERWISE NOTICED, EXTEND 3/4" FROM EACH COMPUTER OUTLET AND
STUB UP ABOVE AN ACCESSIBLE CEILING.

UNLESS OTHERWISE NOTICED, EXTEND 1" FROM EACH COMBINATION TELEDATA
OUTLET AND STUB UP ABOVE AN ACCESSIBLE CEILING.

UNLESS OTHERWISE NOTICED, EXTEND 1" FROM EACH TELEVISION (CATV)
OUTLET AND STUB UP ABOVE AN ACCESSIBLE CEILING.

% ALL DEVICES ON EMERGENCY SHALL BE RED TINT STAINLESS STEEL COVERPLATE.
ALL COVERPLATES BECOMING AREA SHALL HAVE A RED LETTER "R" DESIGNATION.
FOR THE SECURE AREA DESIGNATIONS.

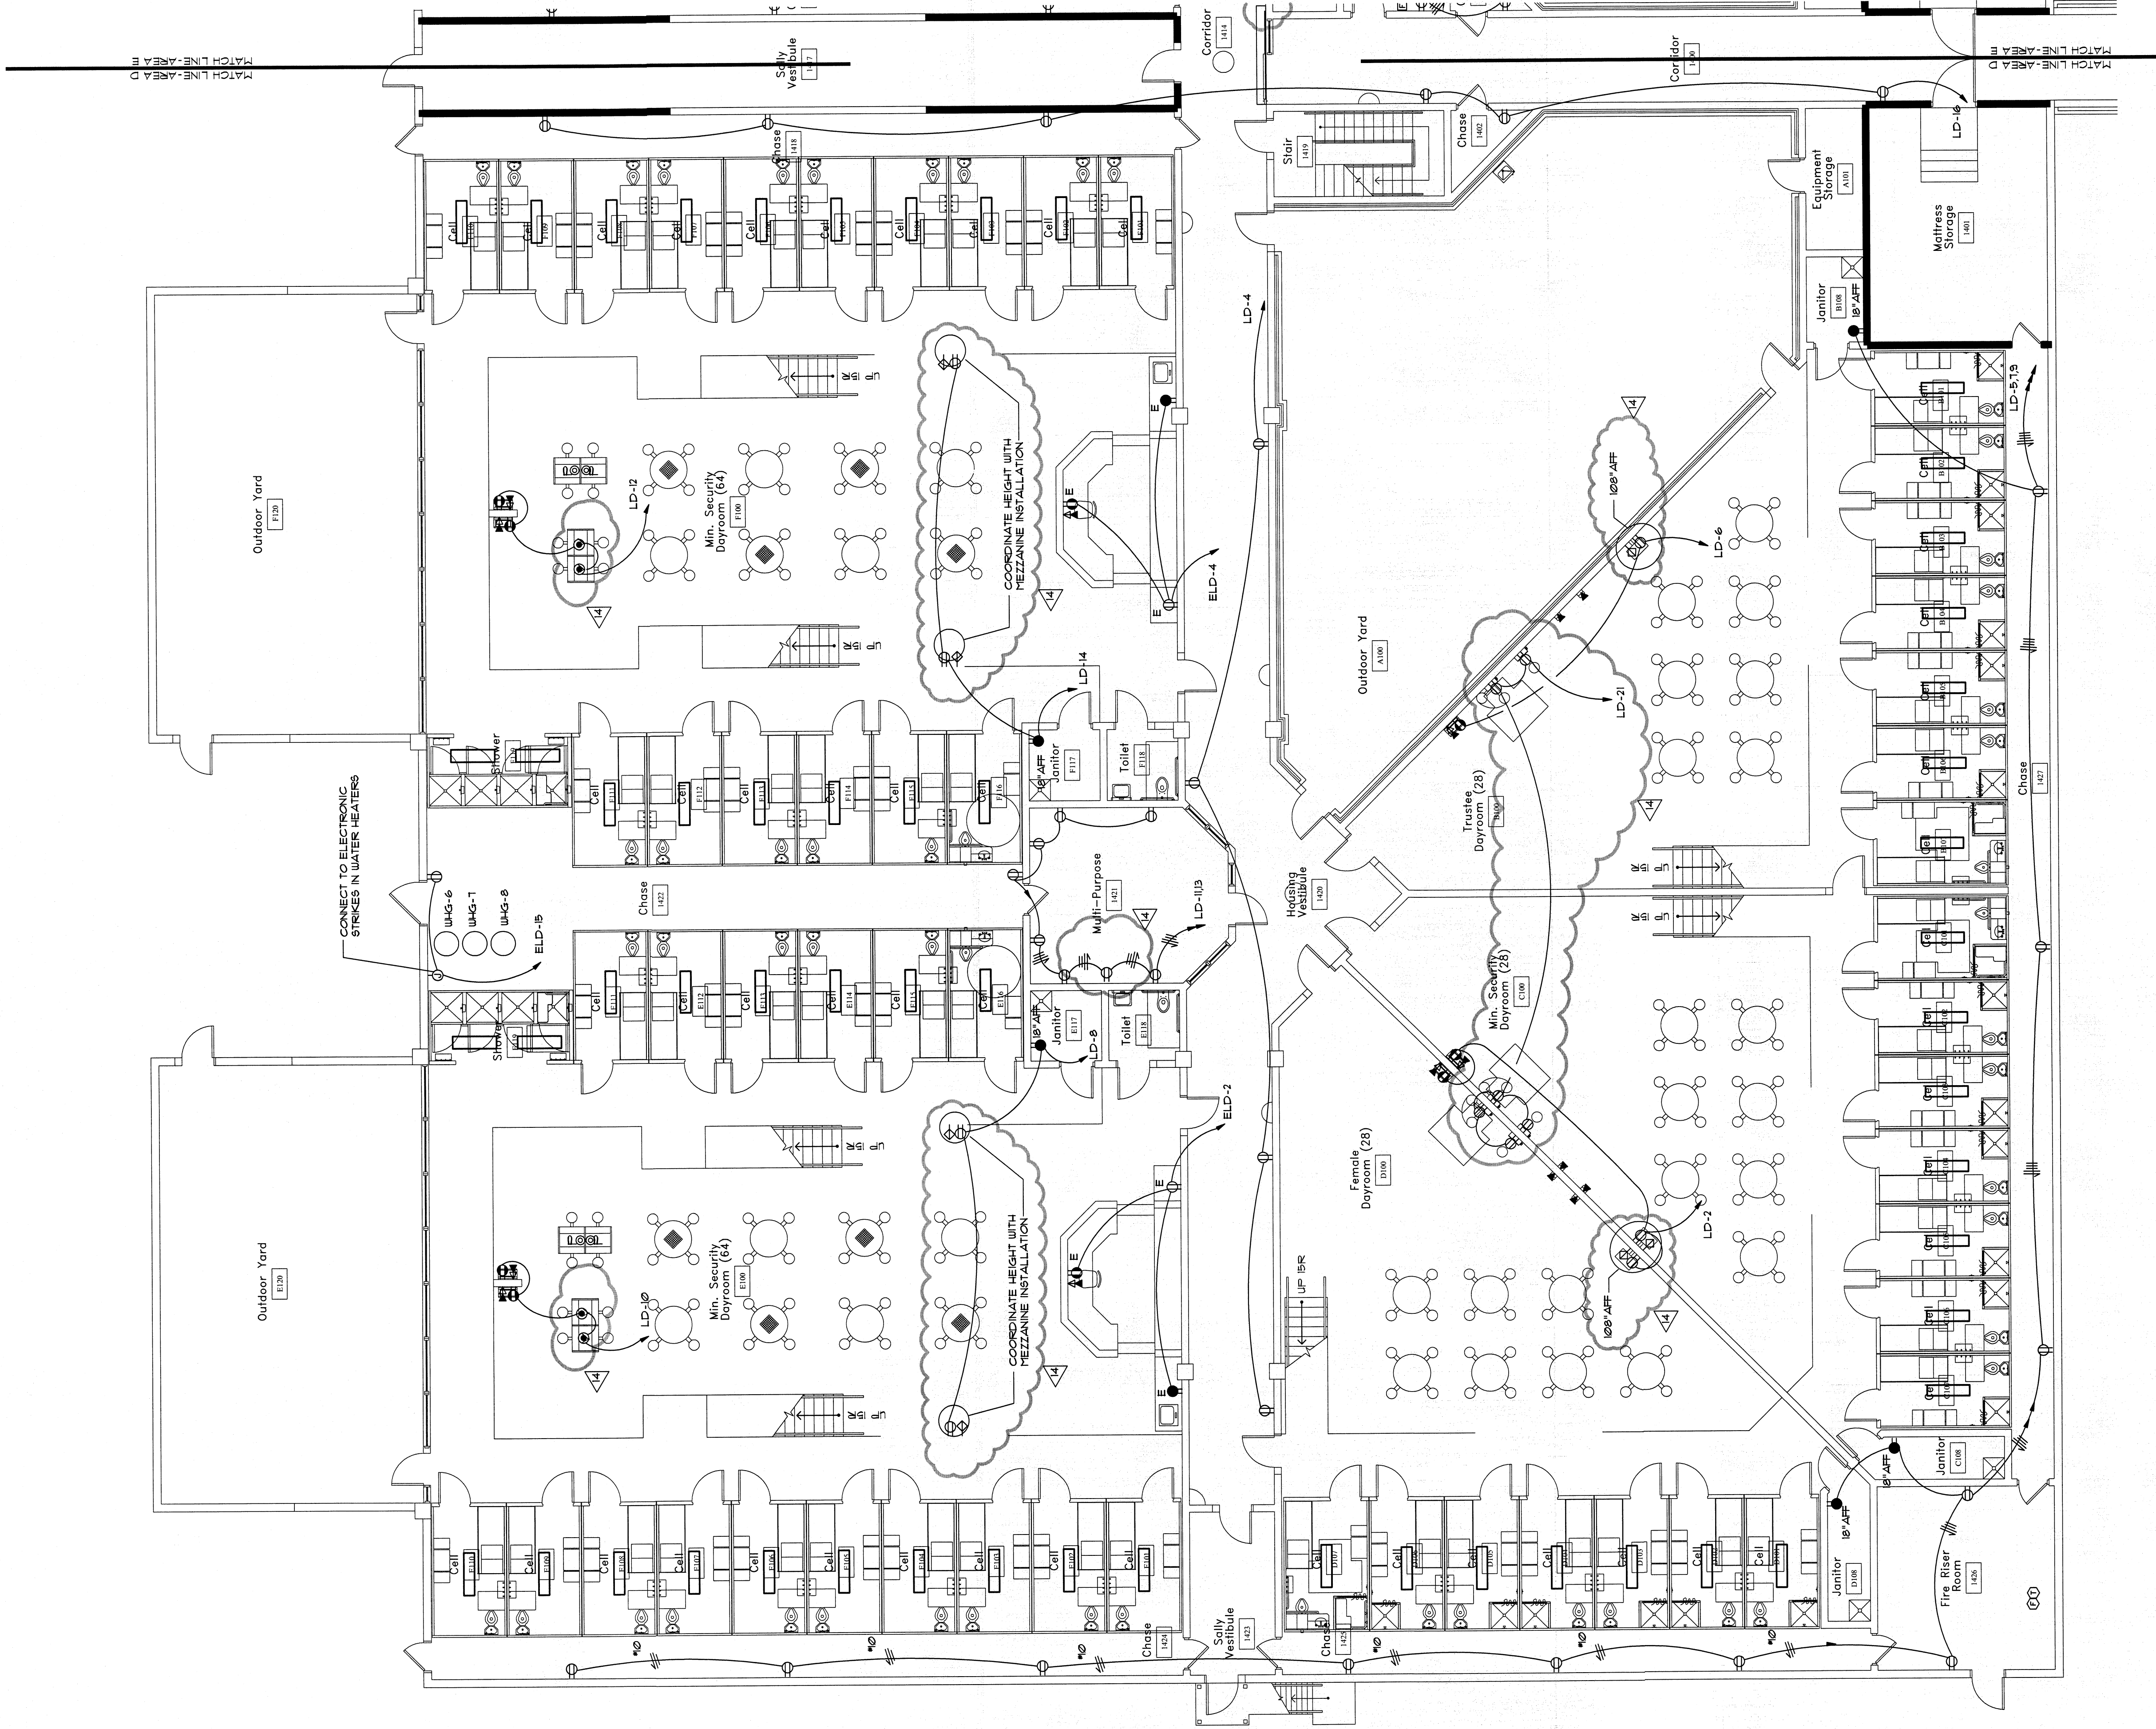

Electrical Plan Area 'D'

SCALE 1/8" = 1'-0"

E33

Job No. 1000

Job North