


E1.1	
FILE NUMBER	
CAD FILE NAME	
PROJECT	
PROJECT NUMBER	
DATE	10-31-07
DATE	12/12/07
NO DESCRIPTION	MECHANICAL / ELECTRICAL BID PACKAGE RELEASE
RELEASE	
SHEET TITLE	ELECTRICAL SITE PLAN
JBL	DESIGN
JBL	DRAWN
GER	CHECKED
PROJECT	
JACKSON COUNTY JAIL 555 GENERAL JACKSON DRIVE JEFFERSON, GEORGIA 30549	
Precision Planning, Inc. P.O. Box 2210 Lawrenceville, GA 30046-2210 (770) 338-8000 or (770) 962-8000 (Fax) (770) 822-5990 Planners, engineers, architects & surveyors	
STAMP	
Professional Engineer No. 7090 Gerald E. Roberts	
PRECISION PLANNING, INC. ALL RIGHTS RESERVED. © 2008	

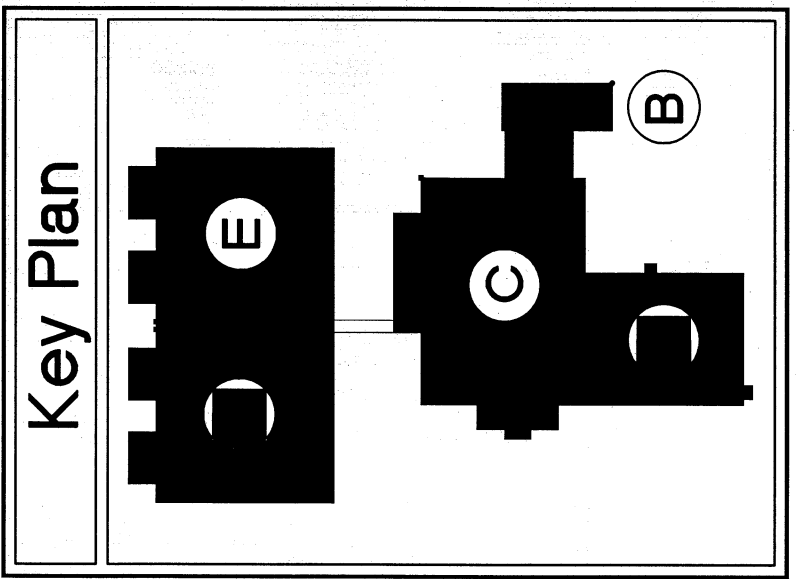

ROBERTS CONSULTING ENGINEERS
455 EAST PACES FERRY ROAD, N.E.
SUITE 300
ATLANTA, GEORGIA 30305
TELEPHONE (404) 237-8632
FACSIMILE (404) 237-4701

Electrical Site Plan
Scale: 1" = 30'-0"

