


E2.3		FILE NUMBER CAD FILE NAME P.O.J. NUMBER DATE	
A06186		10-31-07	
RELEASE		NO DESCRIPTION	
12/21/07		MECHANICAL / ELECTRICAL BID PACKAGE RELEASE	
02/29/08		M.P.E. COORDINATION	
SHEET TITLE		AREA 'D' LIGHTING PLAN	
JBL		DESIGN	
JBL		DRAWN	
GER		CHECKED	
PROJECT		JACKSON COUNTY JAIL 555 GERRARD JACSON DRIVE JEFFERSON, GEORGIA 30549	
Precision Planning, Inc. Planners, engineers, architects & surveyors P.O. Box 2210 400 Pike Boulevard Lawrenceville, GA 30046-2210 (770) 339-8000 or (770) 962-8000 (Fax) (770) 822-5990		STAMP 2/12/08 GREGORY C. ROBERTS PROFESSIONAL No. 70990 STATE OF GEORGIA	
PRECISION PLANNING, INC. ALL RIGHTS RESERVED. © 2008 THIS DOCUMENT IS THE PROPERTY OF PRECISION PLANNING, INC. AND IS NOT TO BE REPRODUCED OR TRANSMITTED IN ANY FORM OR BY ANY MEANS, ELECTRONIC OR MECHANICAL, WITHOUT PERMISSION FROM PRECISION PLANNING, INC.		PRECISION PLANNING, INC. ALL RIGHTS RESERVED. © 2008 THIS DOCUMENT IS THE PROPERTY OF PRECISION PLANNING, INC. AND IS NOT TO BE REPRODUCED OR TRANSMITTED IN ANY FORM OR BY ANY MEANS, ELECTRONIC OR MECHANICAL, WITHOUT PERMISSION FROM PRECISION PLANNING, INC.	

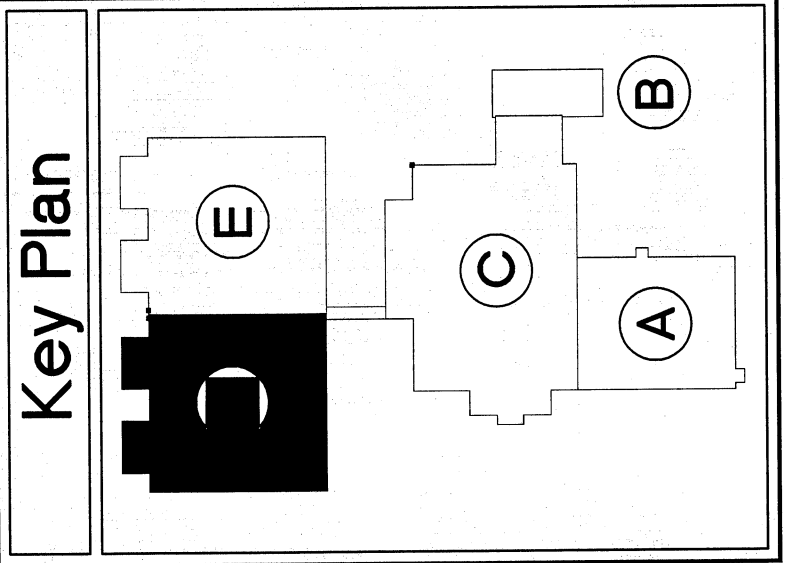


ROBERTS
CONSULTING
ENGINEERS

451 EAST PACES FERRY ROAD, N.E.
SUITE 300
ATLANTA, GA 30306
TELEPHONE (404) 257-8632
FACSIMILE (404) 257-4161

JBL 2007-024

- LEGEND NOTES: (APPLY THIS SHEET ONLY)
1. EXTEND CIRCUIT THROUGH THE LIGHTING CONTROL PANEL, FURNISHED UNDER DIVISION 17, PROVIDE A HOT LEG TO SERVE NIGHT LIGHTING, WHICH SHOULD OPERATE CONTINUOUSLY.
 2. EXTEND CIRCUIT THROUGH THE LIGHTING CONTROL PANEL, FURNISHED UNDER DIVISION 17, PROVIDE DUAL SWITCHING FOR NIGHT LIGHTING TO OPERATE WHEN MAIN CIRCUIT IS OFF.
 3. EXTEND CIRCUIT THROUGH THE OUTSIDE LIGHTING CONTACTOR, CONTROLLED BY PHOTOCONTROL.
 4. EXTEND CIRCUIT THROUGH THE LIGHTING CONTROL PANEL, FURNISHED UNDER DIVISION 17.

- NOTES:
1. PROVIDE IN EACH CONDUIT, NOT OTHERWISE NOTED, TWO #2 AND ONE #12 GROUND. THIS INCLUDES ALL SWITCH LEGS, LIGHTING AND RECEPTACLE CONDUITS.
 2. FOR EXTERIOR LIGHTING FIXTURES MARKED 'O' SEE SHEET E11 FOR SCHEDULE.

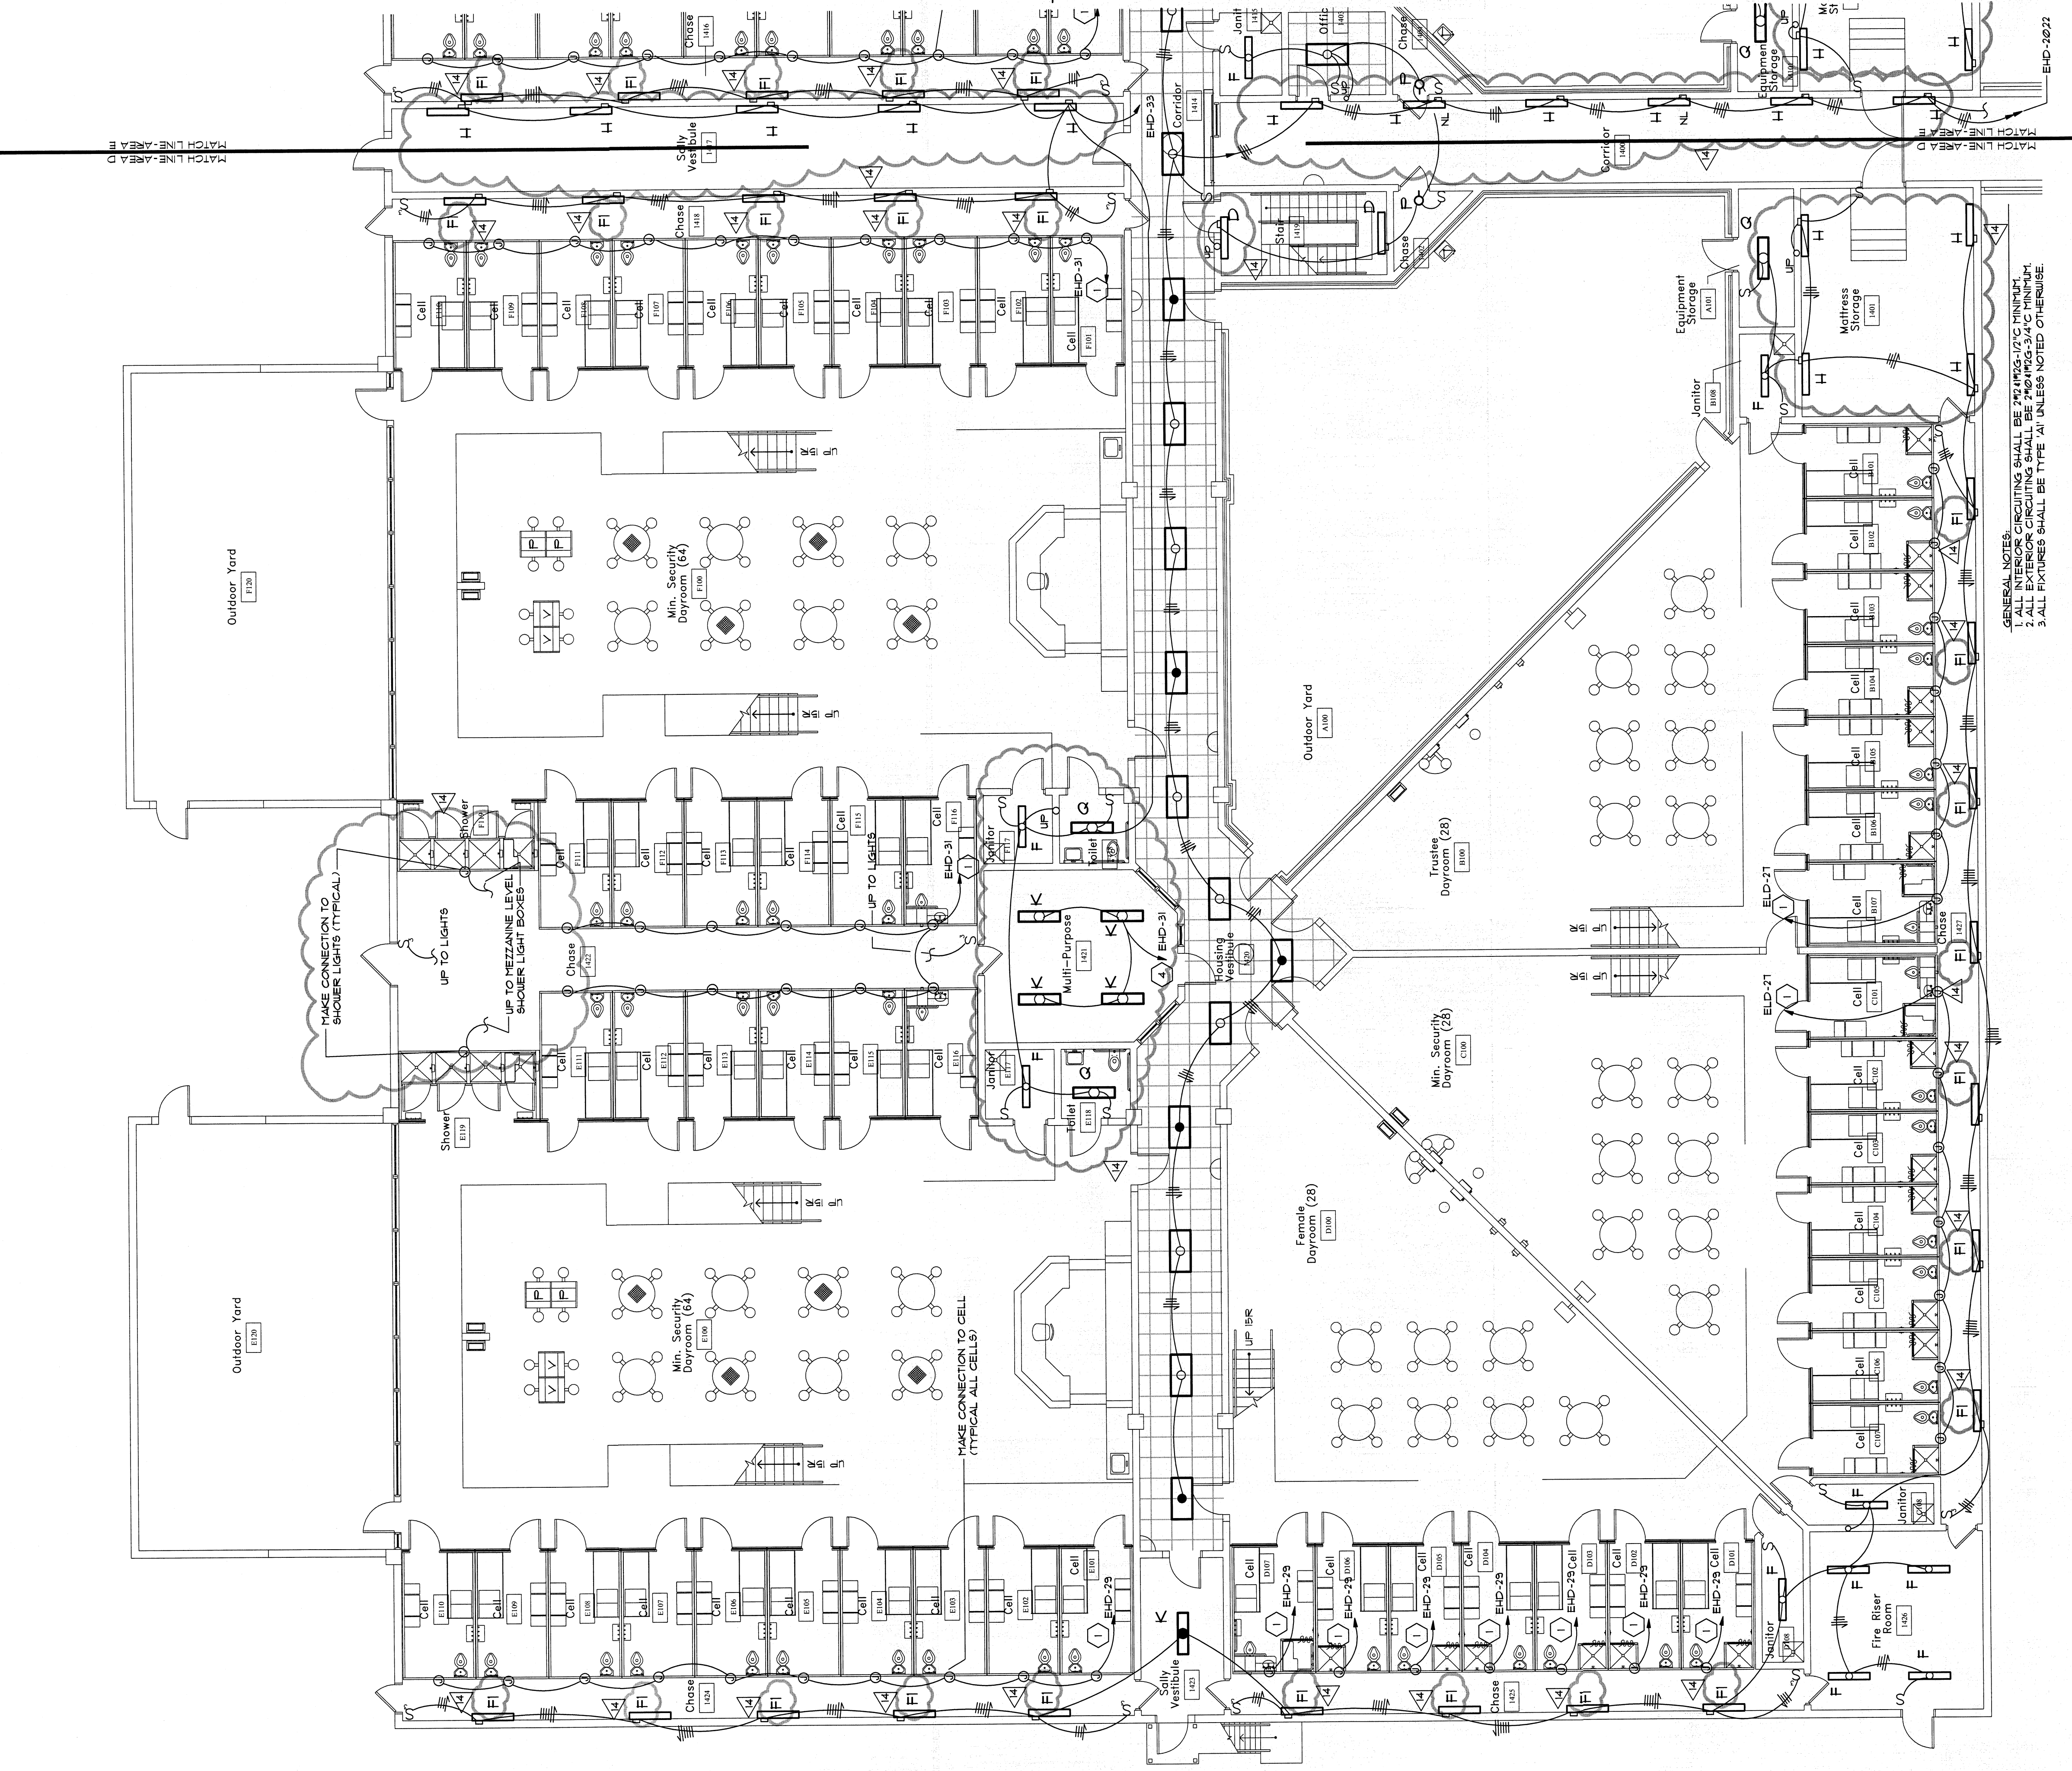

E2.3 SCALE 1/8" = 1'-0"

Lighting Plan Area 'D'

Job North

GENERAL NOTES:
1. ALL INTERIOR CIRCUITS SHALL BE 75/100/175V MINIMUM
2. ALL EXTERIOR CIRCUITS SHALL BE 120/240V MINIMUM
3. ALL FIXTURES SHALL BE TYPE 'A' UNLESS NOTED OTHERWISE