



E2.6		FILE NUMBER CAD FILE NAME A06106 PROJ. NUMBER DATE 10-31-07	
RELEASE		DATE NO DESCRIPTION 12/21/07 MECHANICAL / ELECTRICAL BID PACKAGE RELEASE 02/29/08 M.P.E. COORDINATION	
SHEET TITLE LIGHTING PLAN AREA 'E' MEZZANINE		JBL DESIGN JBL DRAWN JBL CHECKED GER	
PROJECT JACKSON COUNTY JAIL 555 GENERAL JACKSON DRIVE JEFFERSON, GEORGIA 30549		PRECISION PLANNING, Inc. P.O. Box 2210 400 Pike Boulevard Lawrenceville, GA 30046-2210 (770) 338-8000 or (770) 962-8000 (Fax) (770) 822-5990 planners, engineers, architects & surveyors	
STAMP 2.12.07 PRECISION PLANNING, Inc. P.O. Box 2210 400 Pike Boulevard Lawrenceville, GA 30046-2210 (770) 338-8000 or (770) 962-8000 (Fax) (770) 822-5990 planners, engineers, architects & surveyors		STAMP 2.12.07 PRECISION PLANNING, Inc. P.O. Box 2210 400 Pike Boulevard Lawrenceville, GA 30046-2210 (770) 338-8000 or (770) 962-8000 (Fax) (770) 822-5990 planners, engineers, architects & surveyors	

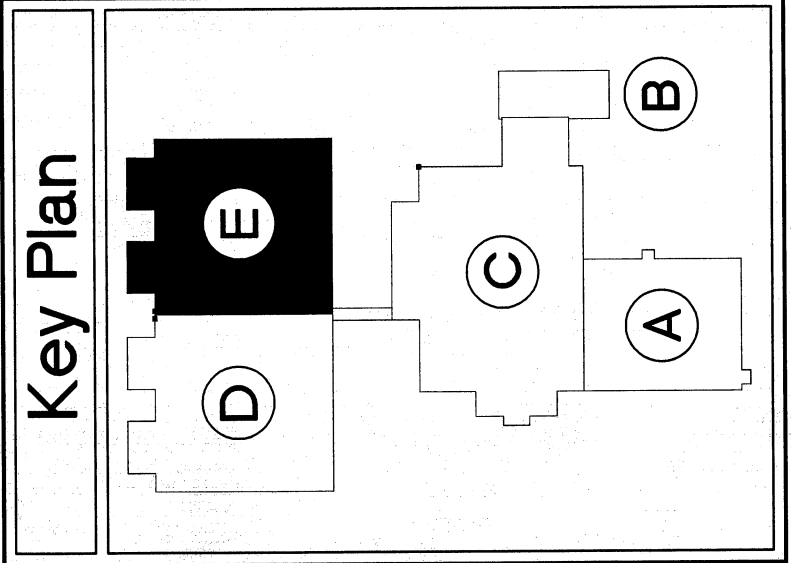

ROBERDS CONSULTING ENGINEERS
455 EAST PACES FERRELL ROAD, N.E.
SUITE 800
ATLANTA, GEORGIA 30326
TELEPHONE (404) 237-8632
FACSIMILE (404) 237-4161

- LEGEND NOTES: (APPLY THIS SHEET ONLY)**
- 1. EXTEND CIRCUIT THROUGH THE LIGHTING CONTROL PANEL, FURNISHED UNDER DIVISION 11, PROVIDE A HOT LEG TO SERVE NIGHT LIGHTING, WHICH SHOULD OPERATE CONTINUOUSLY.
 - 2. EXTEND CIRCUIT THROUGH THE LIGHTING CONTROL PANEL, FURNISHED UNDER DIVISION 11, PROVIDE DUAL SWITCHING FOR NIGHT LIGHTING TO OPERATE WHEN MAIN CIRCUIT IS OFF.
 - 3. EXTEND CIRCUIT THROUGH THE OUTSIDE LIGHTING CONTACTOR, CONTROLLED BY PHOTOCONTROL.
 - 4. EXTEND CIRCUIT THROUGH THE LIGHTING CONTROL PANEL, FURNISHED UNDER DIVISION 11.
- NOTES:**
- 1. PROVIDE IN EACH CONDUIT NOT OTHERWISE NOTED TWO #12 AND ONE #12 GROUND. THIS INCLUDES ALL SWITCH LEGS, LIGHTING AND RECEPTACLE CONDUITS.
 - 2. FOR EXTERIOR LIGHTING FIXTURES MARKED 'O' SEE SHEET E11 FOR SCHEDULE.

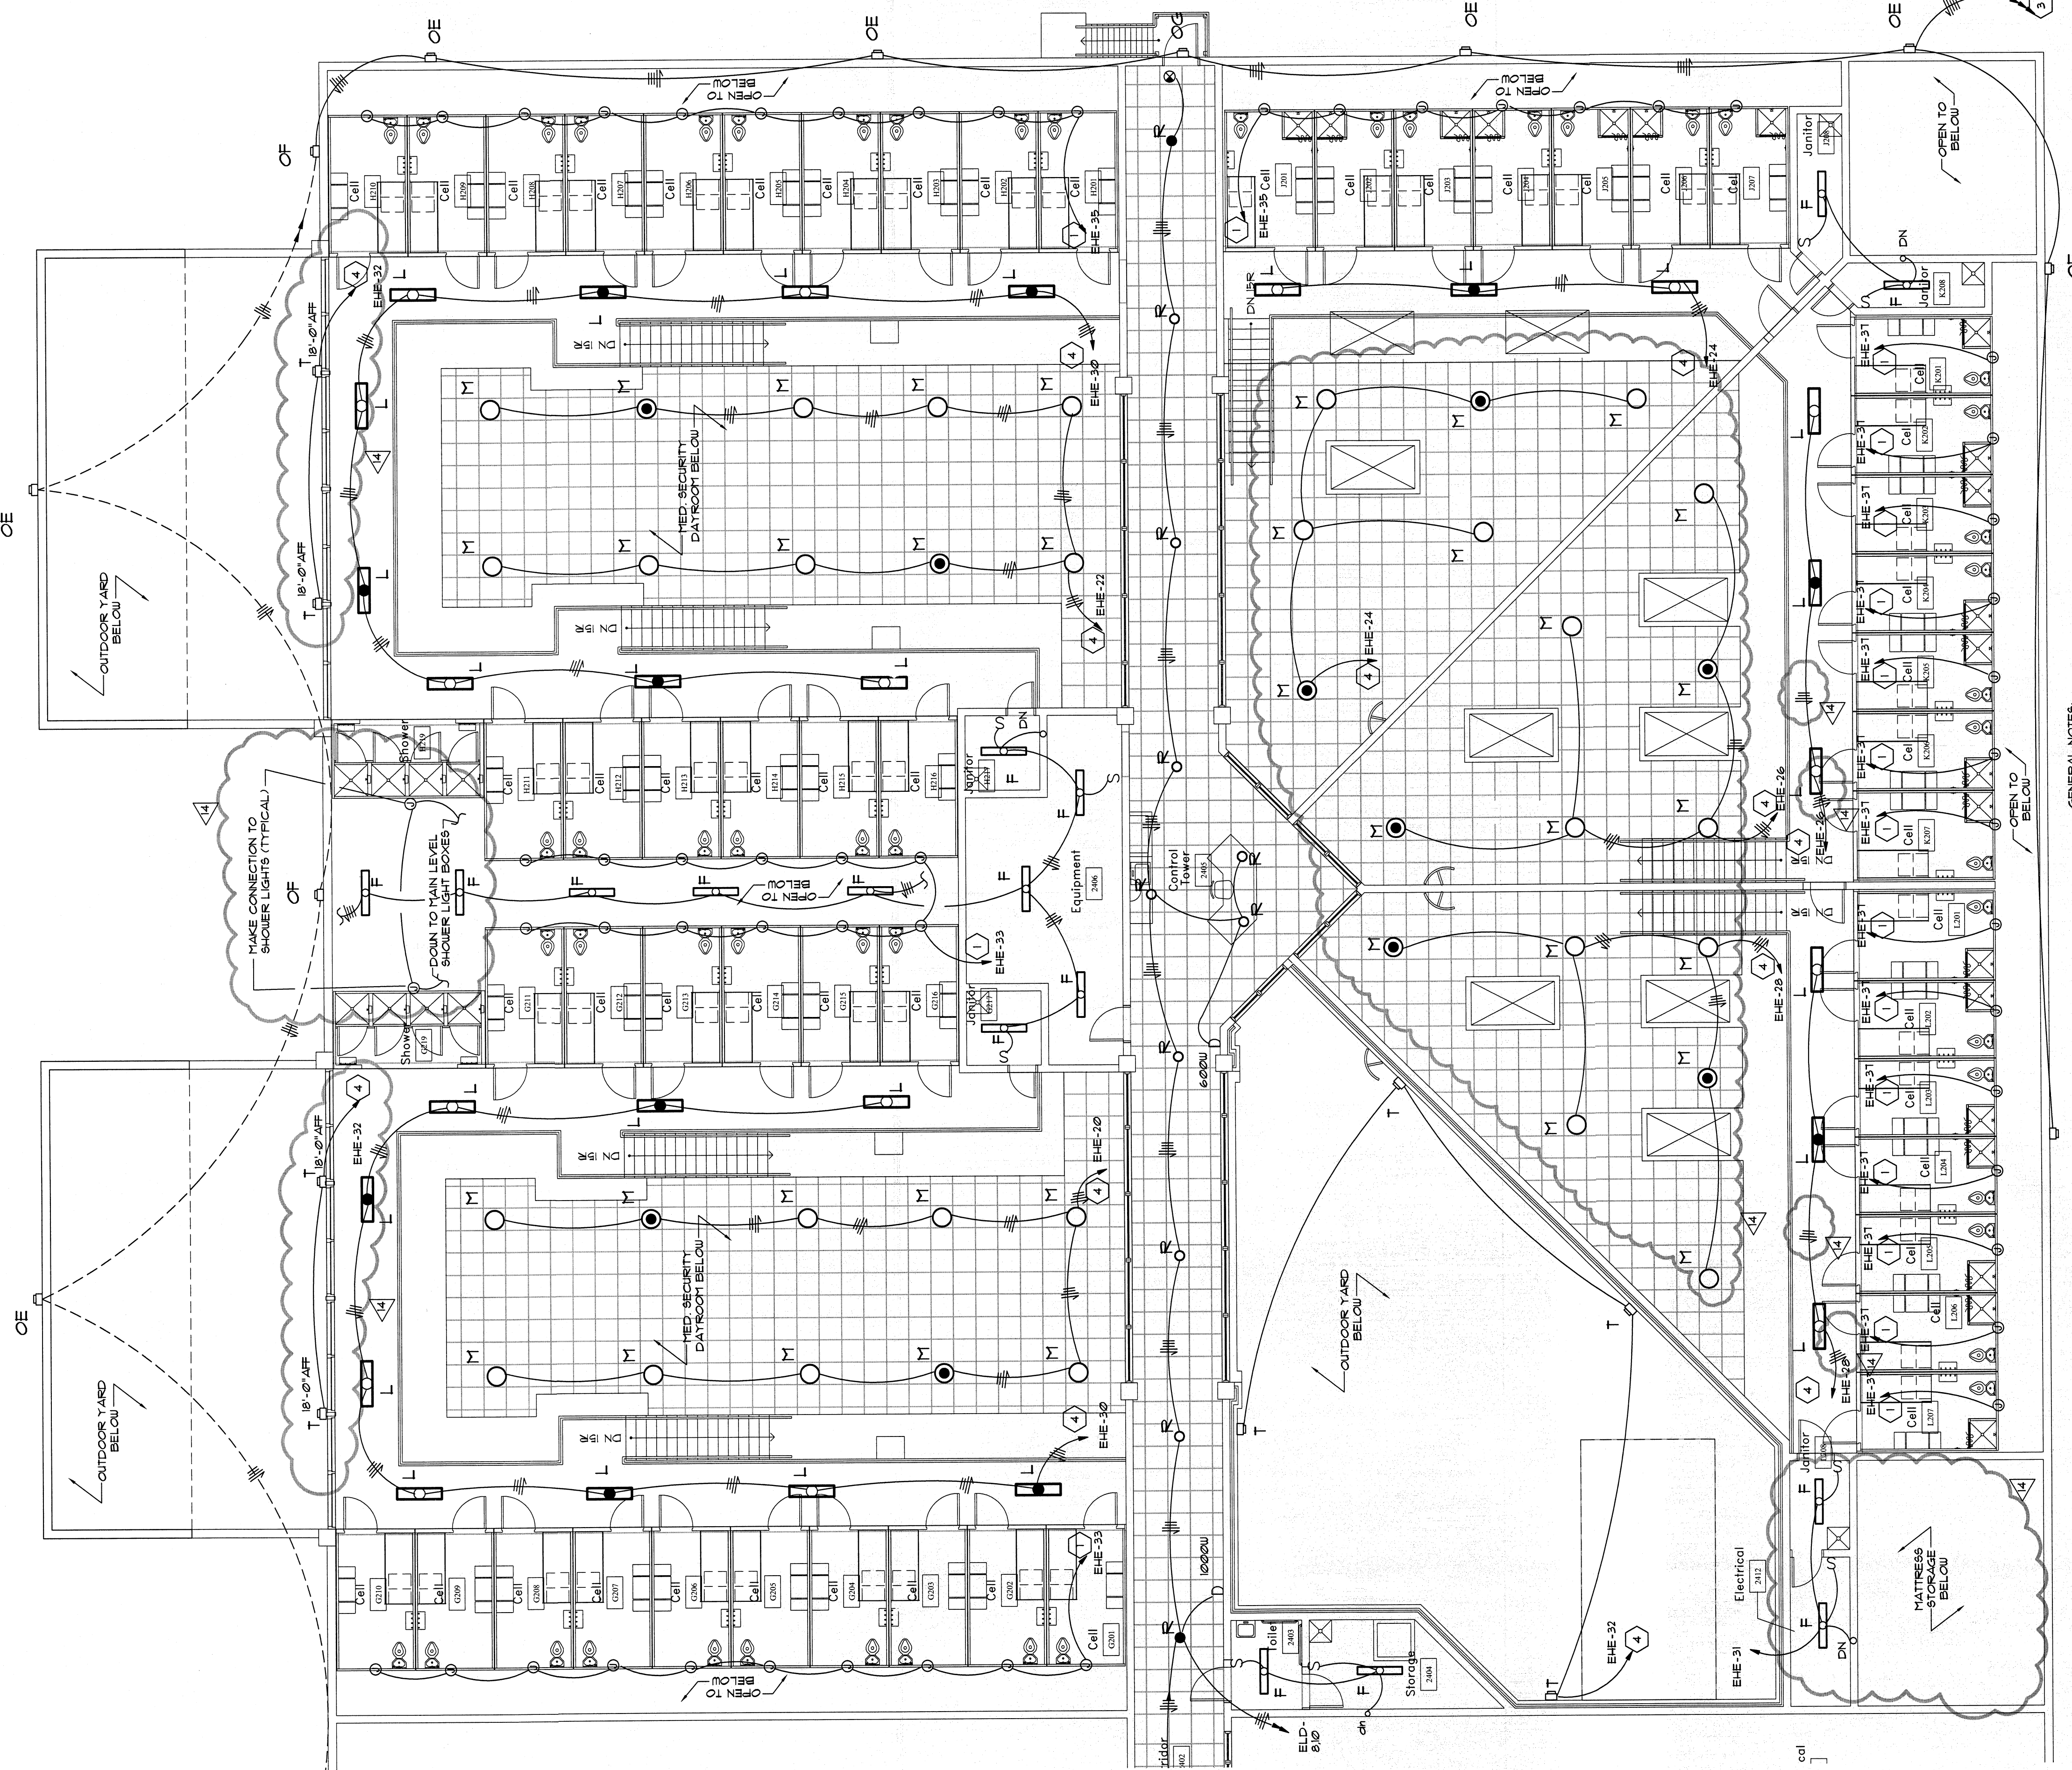

Lighting Plan Area 'E' - Mezzanine
SCALE 1/8" = 1'-0"
E2.6

GENERAL NOTES:
1. ALL EXTERIOR CIRCUITING SHALL BE 90% RMC, 1/2" MINIMUM.
2. ALL EXTERIOR CIRCUITING SHALL BE 1/2" MINIMUM.
3. ALL FIXTURES SHALL BE TYPE 'A' UNLESS NOTED OTHERWISE.