



E2.1	
FILE NUMBER C02421	CAD FILE NAME A06136
PROJ. NUMBER A06136	DATE 10-31-07
RELEASE DATE 12/2/07 DESCRIPTION M.P.E. COORDINATION	
SHEET TITLE AREAS 'A' & 'B' LIGHTING PLAN	
DESIGN JBL	DRAWN JBL
CHECKED GFR	
PROJECT JACKSON COUNTY JAIL 555 GENERAL JACKSON DRIVE JEFFERSON, GEORGIA 30549	
Precision Planning, Inc. Planners, engineers, architects & surveyors P.O. Box 2210 400 Pike Boulevard Lawrenceville, GA 30046-2210 (770) 962-8000 or (770) 962-8000 (Fax) (770) 822-5990	
STAMP GERALD E. ROBBINS PROFESSIONAL NO. 7090 STATE OF GEORGIA PLANNING ENGINEER	
PRECISION PLANNING, INC. ALL RIGHTS RESERVED. © 2008	

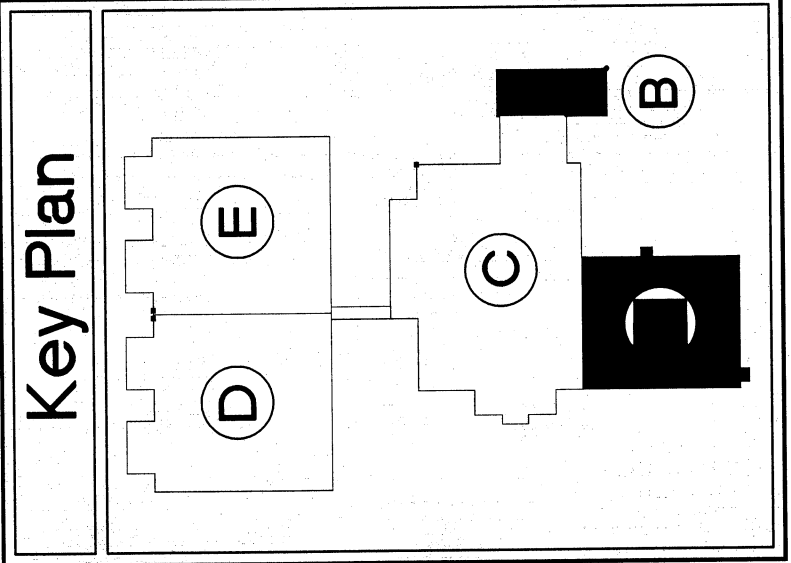


ROBERDS CONSULTING ENGINEERS
SUITE 300
455 EAST PACES FERRY ROAD, N.E.
ATLANTA, GEORGIA 30305
TELEPHONE (404) 527-8632
FACSIMILE (404) 527-4741
2007-024 JBL

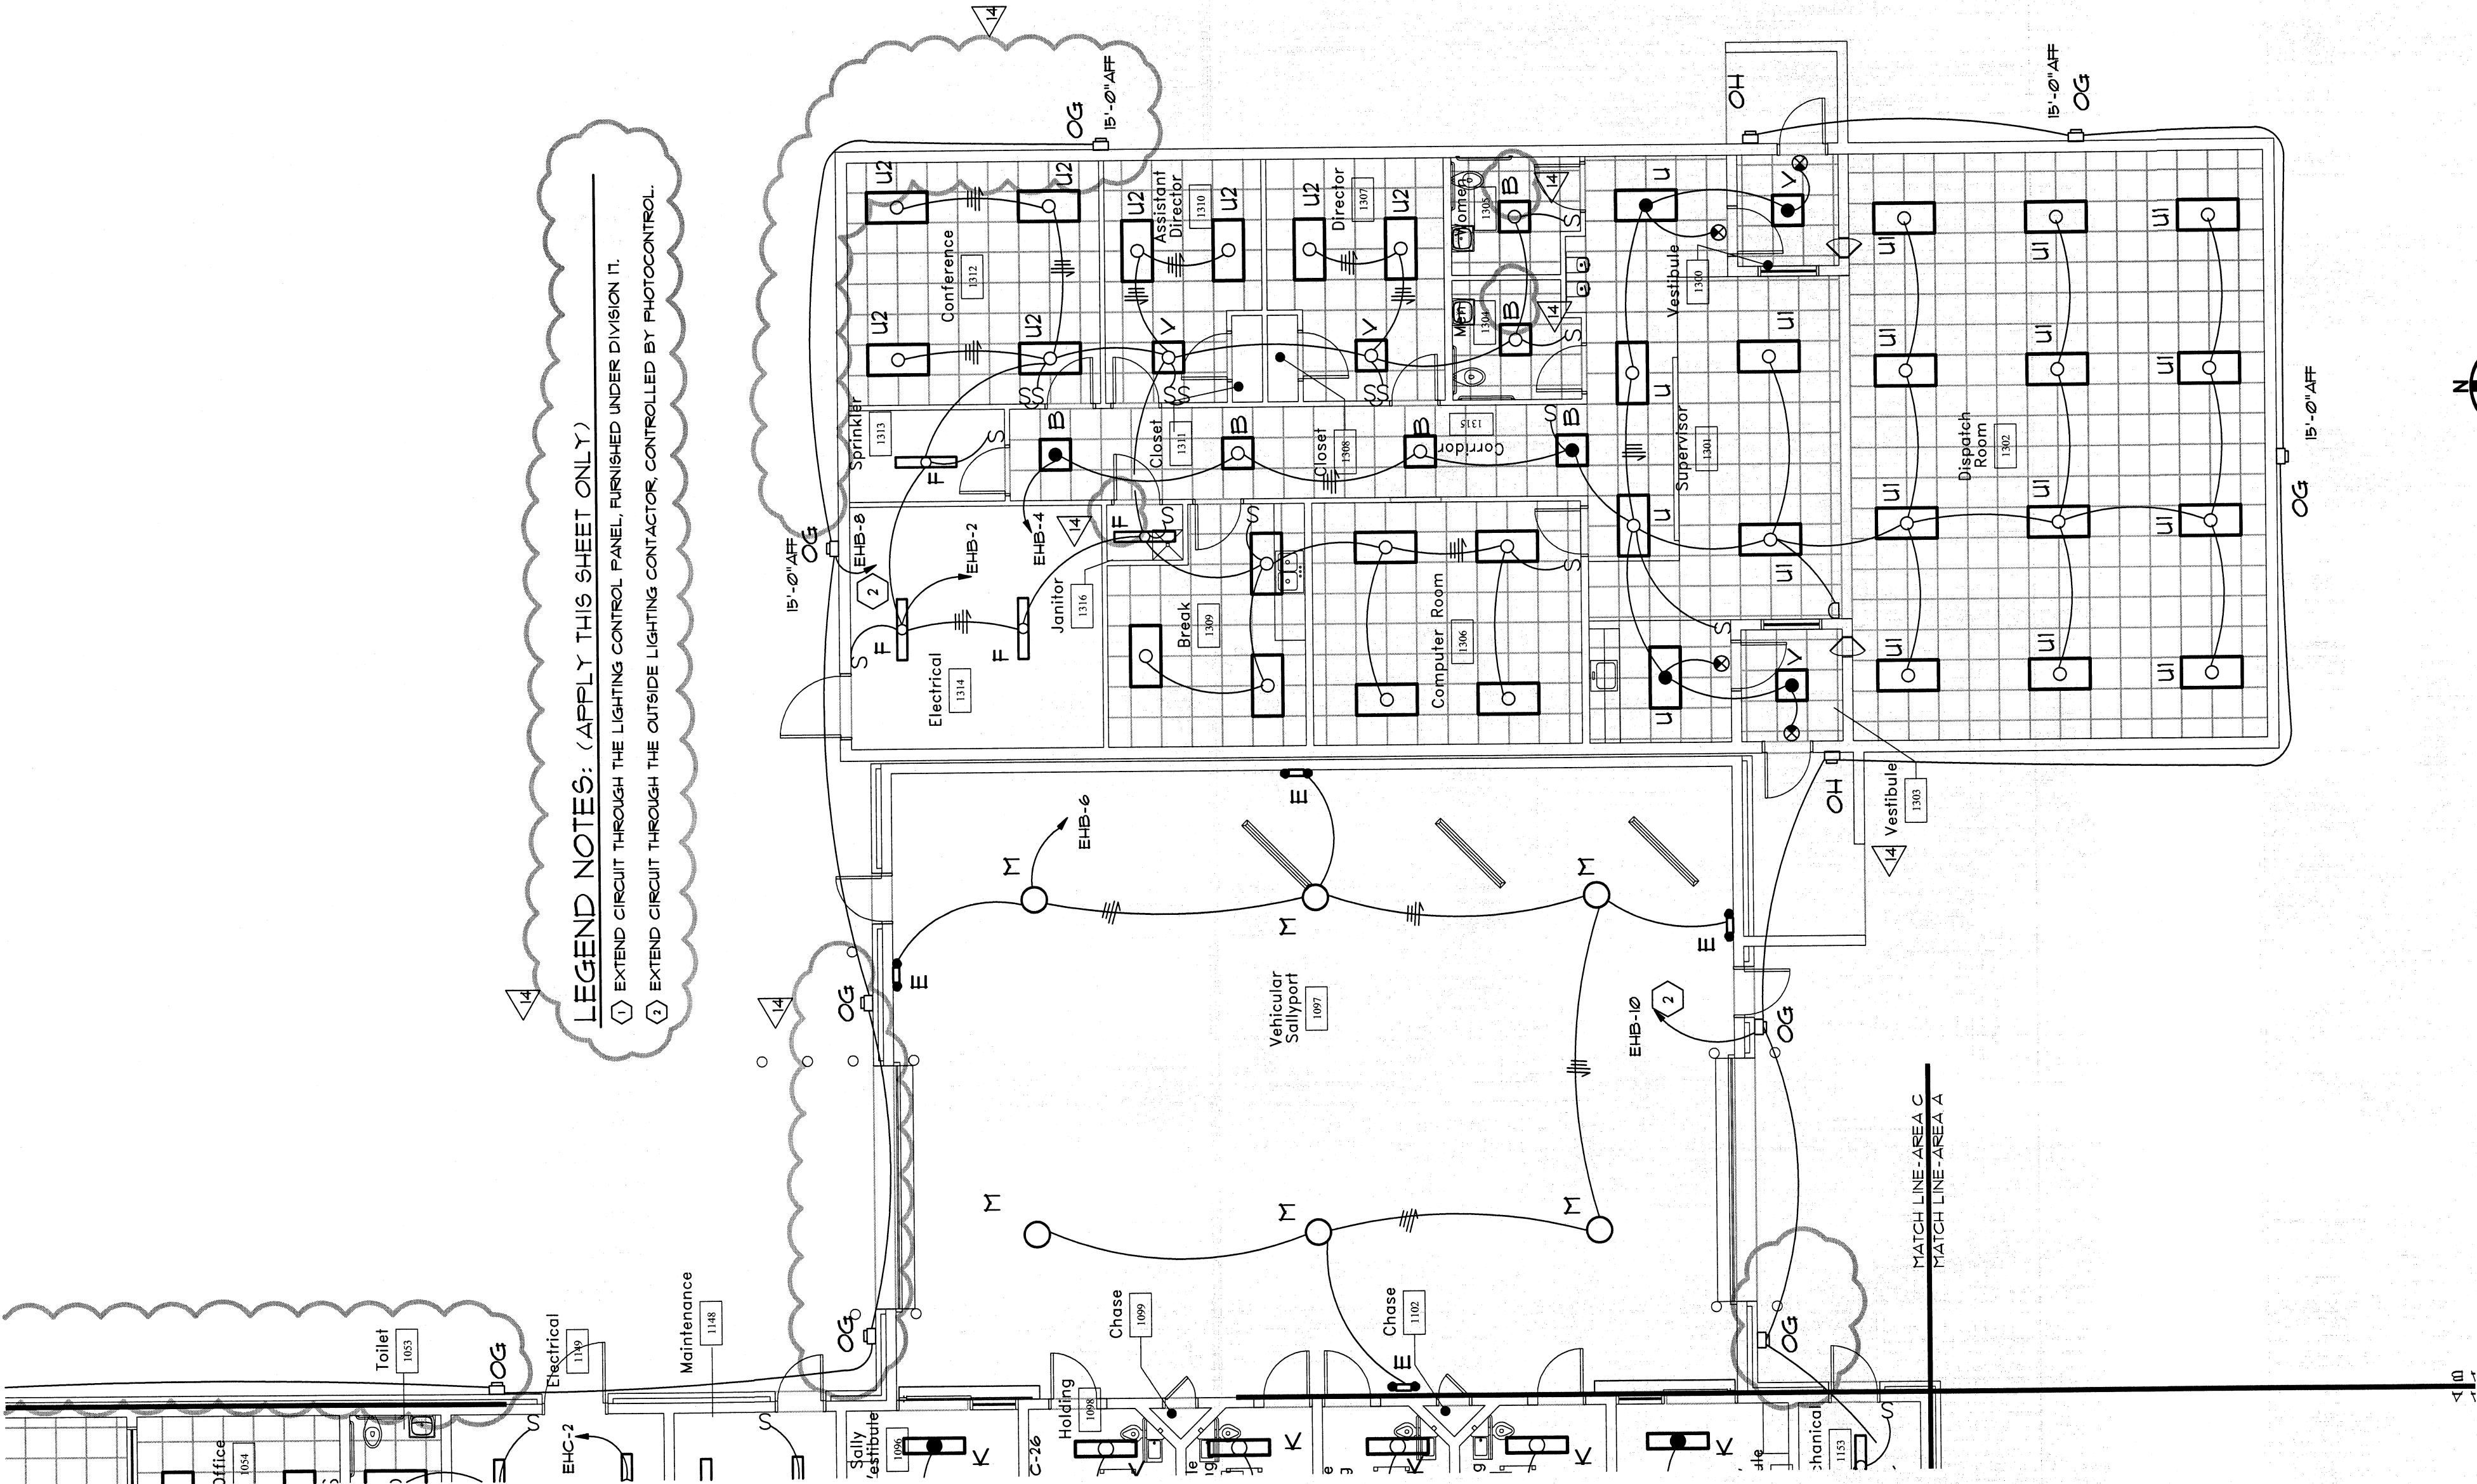

Job North

Lighting Plan Area 'B'

SCALE 1/8" = 1'-0"

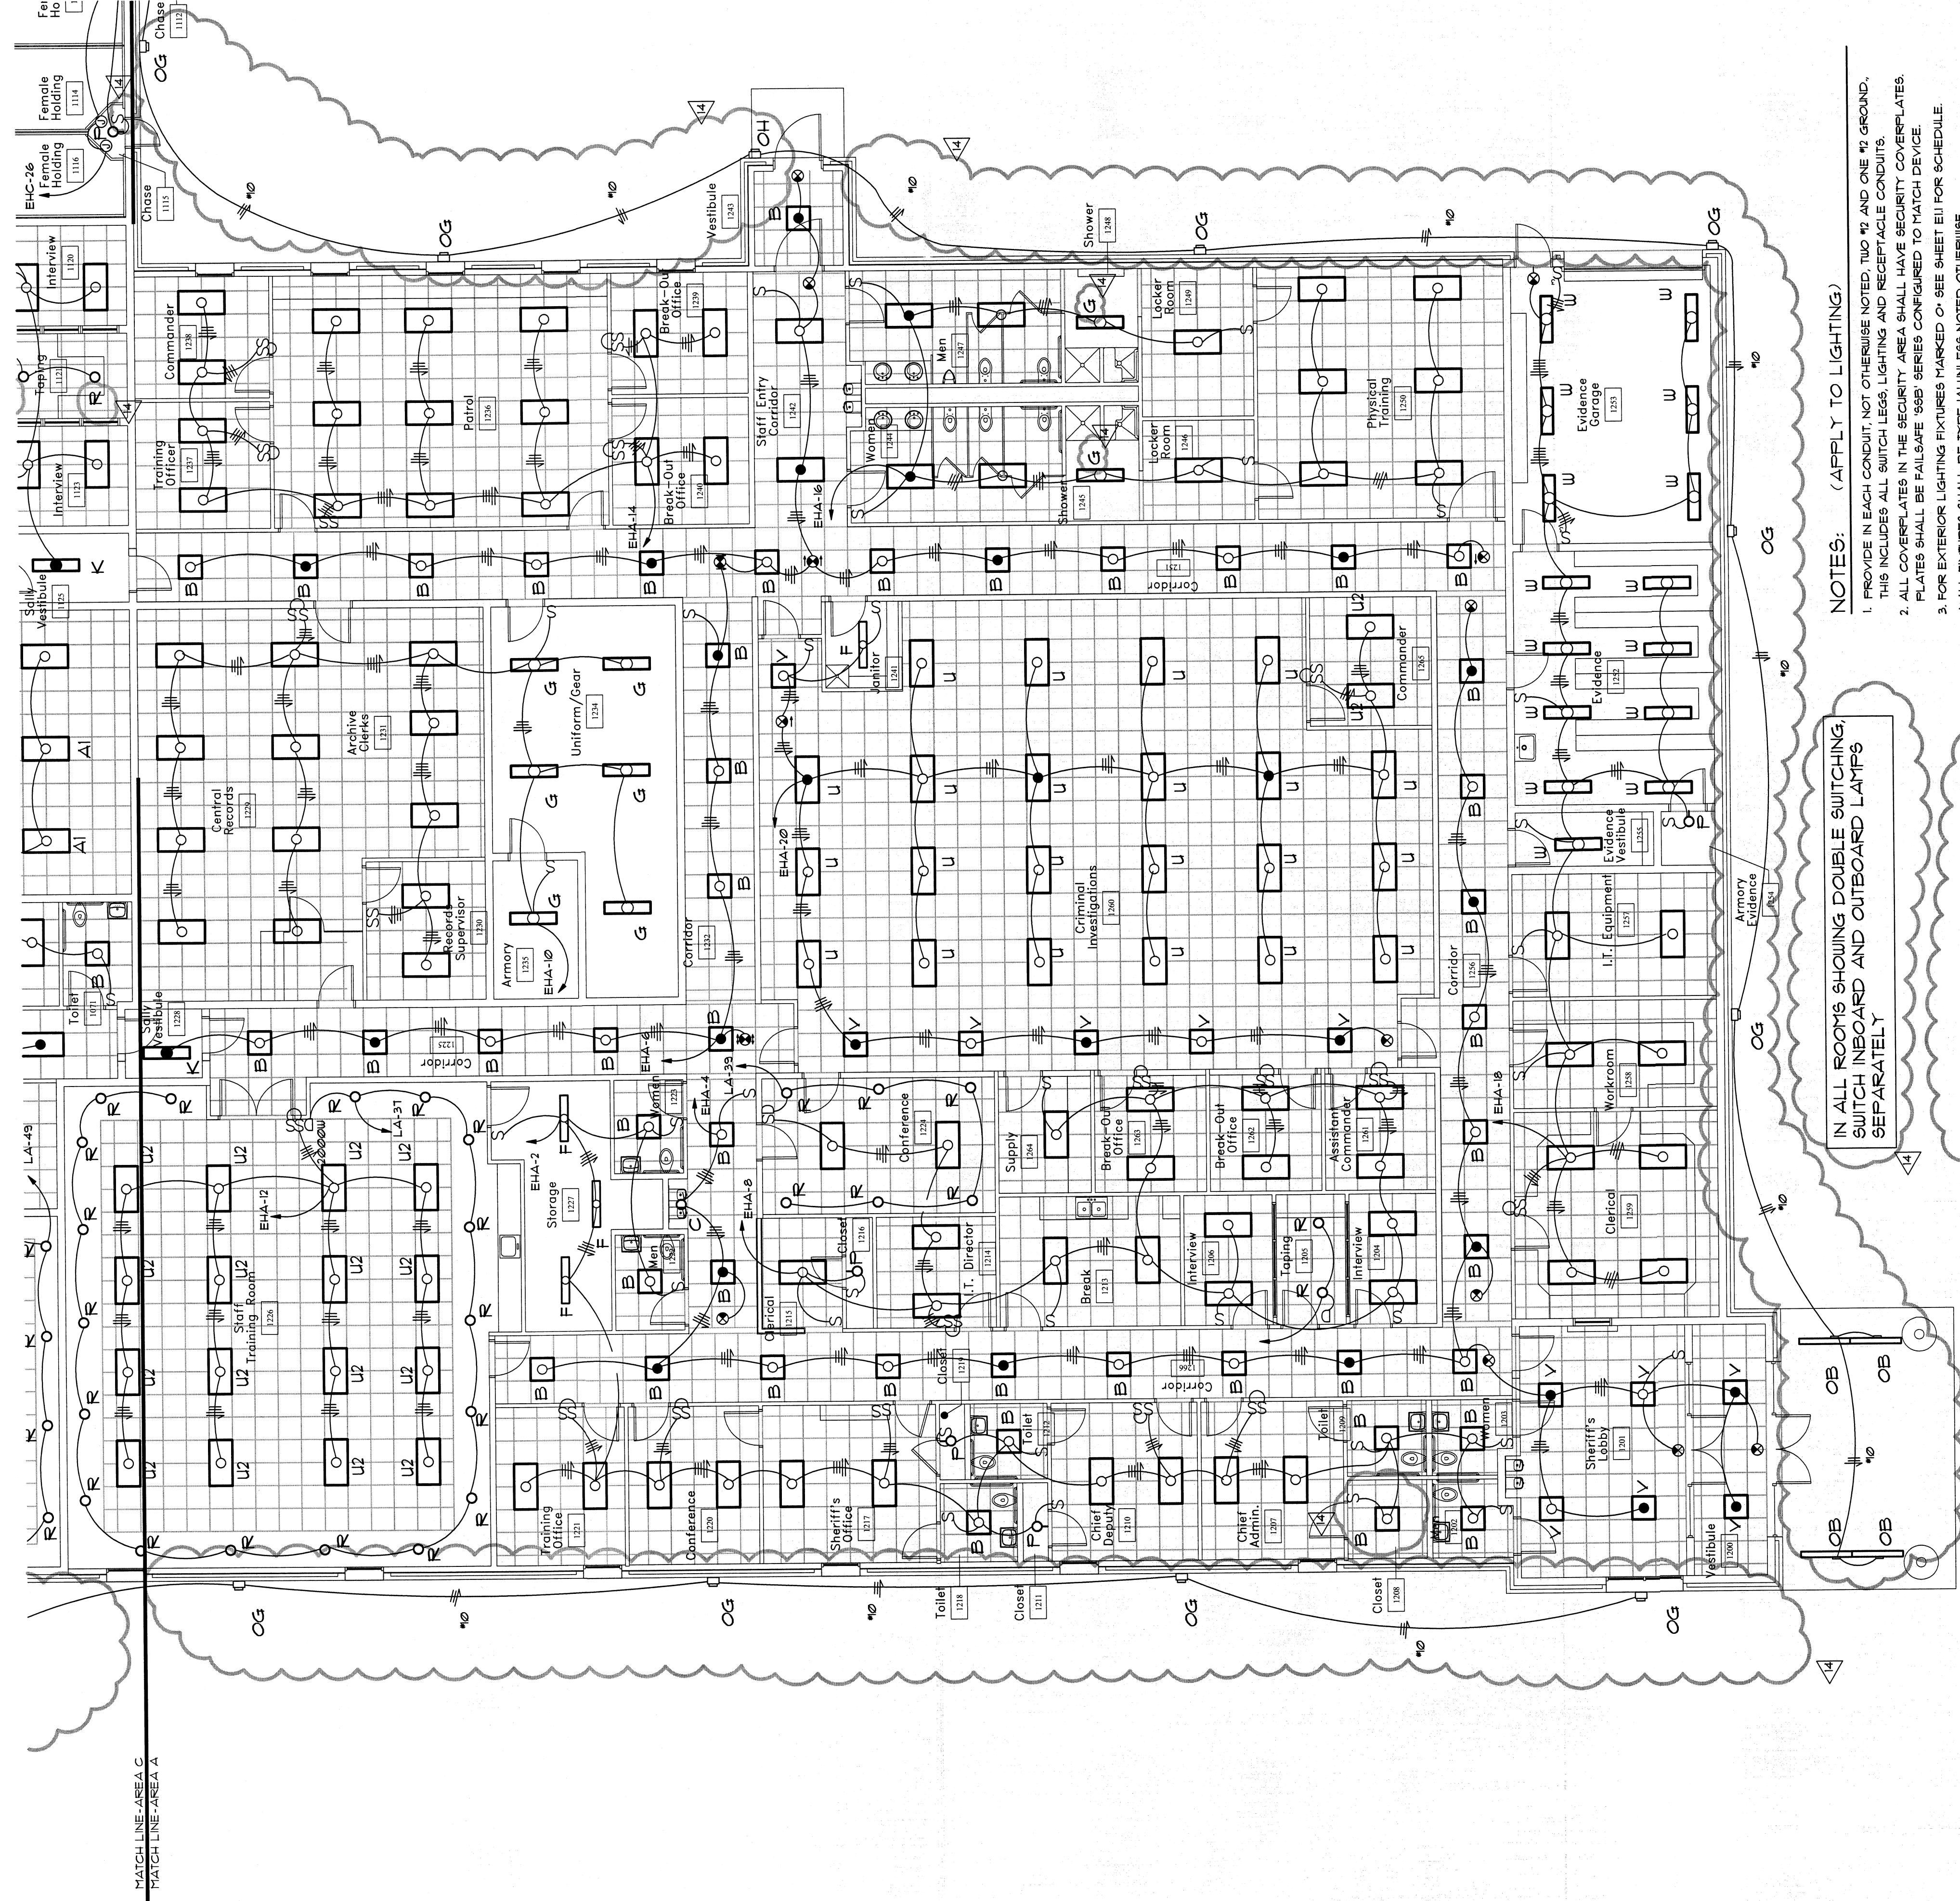

NOTES: (APPLY TO LIGHTING)

1. PROVIDE IN EACH CIRCUIT NOT OTHERWISE NOTED TWO "A" AND ONE "B" GROUND.
2. THIS INCLUDES ALL SWITCH LEGS, LIGHTING AND RECEPTACLE CIRCUITS.
3. ALL COVERPLATES IN THE SECURITY AREA SHALL HAVE SECURITY COVERPLATES.
4. PLATES SHALL BE FAIRSAFE 9680 SERIES CONFIGURED TO MATCH DEVICE.
5. FOR EXTERIOR LIGHTING FIXTURES MARKED "O" SEE SHEET E11 FOR SCHEDULE.
6. ALL FIXTURES SHALL BE TYPE "A" UNLESS NOTED OTHERWISE.
7. ALL EMERGENCY EXIT SIGNS SHALL BE TYPE "X".
8. SEE ARCHITECTURAL SHEETS FOR MOUNTING LOCATIONS OF ALL EXTERIOR WALL FIXTURES.

IN ALL ROOMS SHOWING DOUBLE SWITCHING, SWITCH INBOARD AND OUTBOARD LAMPS SEPARATELY

REFER TO ARCHITECTURAL FOR MOUNTING HEIGHTS AND LOCATIONS OF TYPE "OH" AND "OG" FIXTURES

Job North

Lighting Plan Area 'A'

SCALE 1/8" = 1'-0"