


DRAWING NO.	DESCRIPTION
ES000	TITLE SHEET
ES010.0	DRAWING INDEX
ES020.0	SECURITY ELECTRONICS RISER DIAGRAM
ES020.1	BACKBOX REQUIREMENTS
ES040.0	ETHERNET NETWORK CONNECTION RISER
ES050.0	PLC DEVICENET RISER
ES101.0	SEC1 CABINET LAYOUT – FRONT
ES101.1	SEC1 CABINET LAYOUT – REAR
ES101.2	SEC1 EM POWER DISTRIBUTION
ES101.3	SEC1 EM POWER DISTRIBUTION
ES101.4	SEC1 TERMINAL BLOCK DETAILS
ES101.5	SEC1 TERMINAL BLOCK DETAILS
ES101.6	SEC1 TERMINAL BLOCK DETAILS
ES101.7	SEC1 TERMINAL BLOCK DETAILS
ES101.8	SEC1 TERMINAL BLOCK DETAILS
ES101.9	SEC1 TERMINAL BLOCK DETAILS
ES102.0	SEC2 CABINET LAYOUT – FRONT
ES102.1	SEC2 CABINET LAYOUT – REAR
ES102.2	SEC2 EM POWER DISTRIBUTION
ES102.3	SEC2 EM POWER DISTRIBUTION
ES102.4	SEC2 TERMINAL BLOCK DETAILS
ES102.5	SEC2 TERMINAL BLOCK DETAILS
ES102.6	SEC2 TERMINAL BLOCK DETAILS
ES103.0	SEC3 CABINET LAYOUT – FRONT
ES103.1	SEC3 CABINET LAYOUT – REAR
ES103.2	SEC3 EM POWER DISTRIBUTION
ES103.3	SEC3 EM POWER DISTRIBUTION
ES103.4	SEC3 TERMINAL BLOCK DETAILS
ES103.5	SEC3 TERMINAL BLOCK DETAILS
ES103.6	SEC3 TERMINAL BLOCK DETAILS
ES151.0	UCP-1 PANEL LAYOUT
ES151.1	UCP-2 PANEL LAYOUT
ES151.2	UCP-3 PANEL LAYOUT
ES200.0	SYSTEM SERIAL COMMUNICATION DETAILS
ES200.1	LOOP DETECTOR CONTROLLER PANEL LAYOUT
ES200.2	DRIVE-UP GATE BOLLARD DETAIL
ES210.0	AUDIO HEADEND WIRING DIAGRAM
ES210.1	MASTER STATION WIRING DIAGRAM
ES210.2	INTERCOM STATION WIRING DIAGRAM
ES210.3	SALLYPORT COVERT MICROPHONE WIRING DETAIL
ES220.0	CCTV HEADEND INTERCONNECTION DIAGRAM
ES900.0	RRBRINKS 57700 SLIDER DOOR WIRING DETAIL

DETAIL NO.	DESCRIPTION
ACC_0005_03	HID PROX CARD READER WIRING DETAIL
ACC_0005_02	HID KEYPAD/PROX READER WIRING DETAIL
CCTV_0003_01	PELCO RECESSED MINI-DOME DETAIL
CCTV_0003_02	PELCO SURFACE MINI-DOME DETAIL
CCTV_0005_01	PELCO PTZ-DOME WIRING DETAIL
CCTV_0011_02	BOSCH VIDEO KEYBOARD HOOK-UP DETAIL
CCTV_0017_01	KALATEL COVERT CAMERA WIRING DETAIL
CCTV_0030_01	BOSCH SIGNAL DISTRIBUTION WIRING DETAIL
CCTV_0037_01	PELCO IWM24 PTZ ARM WIRING DETAIL
CMDR_0001_01	COMMANDER MODULAR PLATE WIRING DETAIL
ICOM_0002_01	LOWELL 8C10W-25 PAGE SPEAKER WIRING DETAIL
ICOM_0003_03	DUKANE 7A1060 VISITATION HANDSET WIRING DETAIL
ICOM_0009_01	DUKANE 5A30 PAGE HORN WIRING DETAIL
LOCK_0001_03	MONITOR ONLY DOOR WIRING DETAIL
LOCK_0002_03	OVERHEAD DOOR WIRING DETAIL
LRRB_0008_01	RRBRINKS 5020M LOCK WIRING DETAIL
LSCT_0002_01	SECURITRON MUNL-24 LOCK WIRING DETAIL
MISC_0001_01	UPS/FIRE ALARM N.O. DRY CONTACT INPUT WIRING DETAIL
MISC_0002_01	PHONE N.O. DRY CONTACT OUTPUT WIRING DETAIL
MISC_0007_01	HONEYWELL MOTION DETECTOR WIRING DETAIL
MISC_0010_02	ADEMCO 269 DURESS PUSHBUTTON WIRING DETAIL
MISC_0011_01	KANTECH T-REX REQUEST TO EXIT WIRING DETAIL
PB_0001_03	WATCHTOUR/DOOR RELEASE PUSHBUTTON WIRING DETAIL
PB_0003_05	AB 800-T DURESS PUSHBUTTON WIRING DETAIL
UTIL_0001_01	UTILITY CONTACTOR WIRING DETAIL
VMS_0005_01	VISITATION ENCLOSURE RECOMMENDED MOUNTING DETAIL
VMS_0005_02	VISITATION MOUNTING HOLE PATTERN DETAIL
VMS_1000_06	VISITATION ENCLOSURE WIRING DIAGRAM

The information hereon is property of Stanley Security Solutions, Integrator.com Division and shall not be transmitted, copied, or used for purposes other than that for which it was intended.



14670 Cumberland Road
Noblesville, Indiana 46060
Phone: (317) 776-3500 Fax: (317) 776-3510
www.integrator.com

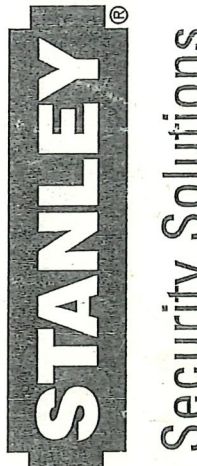

TITLE	
JACKSON COUNTY JAIL	
JEFFERSON, GA	
DRAWING INDEX	
JOB #:	JOB DATE:
V.1666	2/25/2008
APPROVAL:	APPROVAL DATE:
JB	
DESIGN:	
BRANDEN FRY	
SOFTWARE:	
CHRIS MARLOW	
PROJECT MANAGER:	
JASON BRYAN	
REVISIONS	
DESCRIPTION	BY/DATE
1	
2	
3	
4	
5	
6	
FILENAME:JCGA-ES010.0	
DWG NO.	
ES010.0	

BACKBOX REQUIREMENTS		
SYMBOL	UNIT	BACKBOX
	TOUCH SCREEN CONTROL STATION	SINGLE GANG 3-1/2" DEEP BOX BY DIVISION 16 EQUIPMENT LOCATED ON MILLWORK
	SECURITY MANAGEMENT SERVER/ACCESS COMPUTER	SINGLE GANG 3-1/2" DEEP MASONRY
	DOORS, MONITORED/CONTROLLED	IN DOOR FRAME, BY OTHERS
	DOORS, MONITORED ONLY	IN DOOR FRAME, BY OTHERS
	PROXIMITY READER PROXIMITY/KEYPAD COMBINATION READER	SINGLE GANG 3-1/2" DEEP MASONRY BOX BY DIVISION 16
	EXIT PUSHBUTTON	SINGLE GANG 3-1/2" DEEP MASONRY BOX BY DIVISION 16
	DOOR RELEASE PUSHBUTTON	SINGLE GANG 3-1/2" DEEP MASONRY BOX BY DIVISION 16
	DURESS PUSHBUTTON, UNDER-COUNTER	SINGLE GANG 3-1/2" DEEP BOX BY DIVISION 16 EQUIPMENT LOCATED IN MILLWORK
	DURESS PUSHBUTTON, WALL-MOUNT	SINGLE GANG 3-1/2" DEEP MASONRY BOX BY DIVISION 16
	VISITATION HANDSET (PAIR)	2 GANG 3-1/2" DEEP (PER HANDSET) BY DIVISION 16
	MOTION DETECTOR	SINGLE GANG 3-1/2" DEEP MASONRY BOX BY DIVISION 16
	WATCHTOUR PUSHBUTTON	SINGLE GANG 3-1/2" DEEP MASONRY BOX BY DIVISION 16
	REQUEST TO EXIT MOTION DETECTOR	SINGLE GANG 3-1/2" DEEP MASONRY BOX BY DIVISION 16 MOUNT BACKBOX HORIZONTAL ABOVE THE DOOR FRAME
	INTERCOM STATIONS- WALL MOUNTED	2 GANG 3-1/2" DEEP MASONRY BOX BY DIVISION 16
	INTERCOM STATIONS- FRAME MOUNTED	2 GANG 3-1/2" DEEP IN FRAME BY DIVISION 11
	COVERT MICROPHONE	SINGLE GANG BOX BY DIVISION 16 120VAC UPS POWER BY DIVISION 16
	PAGING SPEAKER AND PAGING HORN	SPECIAL BY DIVISION 17
	DVD RECORDER	SINGLE GANG 3-1/2" DEEP MASONRY EQUIPMENT LOCATED ON MILLWORK/DESK
	CCTV MONITOR	SINGLE GANG 3-1/2" DEEP MASONRY EQUIPMENT LOCATED ON MILLWORK/DESK OR CEILING-MOUNT
	CCTV CONTROL KEYBOARD	SINGLE GANG 3-1/2" DEEP MASONRY EQUIPMENT LOCATED ON MILLWORK/DESK
	DVR REMOTE VIEWING COMPUTER	SINGLE GANG 3-1/2" DEEP MASONRY EQUIPMENT LOCATED ON MILLWORK/DESK
	VIDEO VISITATION STATION	2 GANG 3-1/2" DEEP MASONRY BOX BY DIVISION 16
	BUILDING-MOUNTED EXTERIOR PAN-TILT-ZOOM CAMERA	TWO SINGLE GANG BOX BY DIVISION 16 + HOUSING BY DIVISION 17
	BOLLARD-MOUNTED EXTERIOR CAMERA	BOLLARD BY DIVISION 17
	INTERIOR CAMERA WITH DETENTION STYLE HOUSING	4-SQUARE BACK BOX + 3/4" EXTENSION RING BY DIVISION 16 + HOUSING BY DIVISION 17
	EXTERIOR CAMERA WITH WEATHERPROOF HOUSING	TWO SINGLE GANG BOXES BY DIVISION 16
	COVERT CAMERA	SINGLE GANG BOX BY DIVISION 16 120VAC UPS POWER BY DIVISION 16
	LOCAL SHOWER PUSHBUTTON CONTROL - 1128	2 - SINGLE GANG 3-1/2" DEEP MASONRY BOX BY DIVISION 16 COORDINATE EXACT LOCATION WITH THE OWNER

PELCD MINI DOME CAMERA - 24VAC, 3W, INDOOR 	
DISTANCE	WIRE TYPES
<200'	(1) WP815 + (2) #18
<700'	(1) WP815 + (2) #16
<750'	(1) WP815 + (2) #12
<800'	(1) WP806 + (2) #12
<1000'	(1) WP806 + (2) #14

PELCD MINI DOME CAMERA - 24VAC, 10W, OUTDOOR 	
DISTANCE	WIRE TYPES
<200'	(1) WP815 + (2) #18
<750'	(1) WP815 + (2) #16
<800'	(1) WP806 + (2) #12
<1000'	(1) WP806 + (2) #14

PELCD SPECTRA PTZ - 120VAC, OUTDOOR 	
DISTANCE	WIRE TYPES
<750'	(1) WP815 + (1) WP360 + (3) #14
<1000'	(1) WP806 + (1) WP360 + (3) #14
NOTE: THE (3) #14 CABLES MUST BE IN A SEPARATE CONDUIT	

The information hereon is property of Stanley Security Solutions, integrator.com Division and shall not be transmitted, copied, or used for purposes other than that for which it was intended.

STANLEY
integrator.com
14670 Cumberland Road
Noblesville, Indiana 46060
Phone: (317) 776-3500 Fax: (317) 776-3510
www.integrator.com

STANLEY
Security Solutions

TITLE	
JACKSON COUNTY JAIL	
JEFFERSON, GA	
BOX REQUIREMENTS	
JOB #:	JOB DATE:
V.1666	2/25/2008
APPROVAL:	APPROVAL DATE:
JB	
DESIGN:	
BRANDEN FRY	
SOFTWARE:	
CHRIS MARLOW	
PROJECT MANAGER:	
JASON BRYAN	
REVISIONS	
DESCRIPTION	BY/DATE
1	
2	
3	
4	
5	
6	
FILENAME: JCGA-ES020.1	
DWG NO.	
ES020.1	

The information herein is property of Stanley Security Solutions, integrator.com Division and shall not be transmitted, copied, or used for purposes other than that for which it was intended.

STANLEY integrator.com
14670 Cumberland Road
Noblesville, Indiana 46060
Phone: (317) 776-3500 Fax: (317) 776-3510
www.integrator.com

STANLEY®
Security Solutions

TITLE
JACKSON COUNTY JAIL

JEFFERSON, GA

ETHERNET RISER

JOB #: V.1666 JOB DATE: 2/25/2008
APPROVAL: JB APPROVAL DATE:

DESIGN: BRANDEN FRY

SOFTWARE: CHRIS MARLOW

PROJECT MANAGER: JASON BRYAN


REVISIONS

DESCRIPTION	BY	DATE
1		
2		
3		
4		
5		
6		

FILENAME: JCGA-ES040.0

DWG NO.

ES040.0

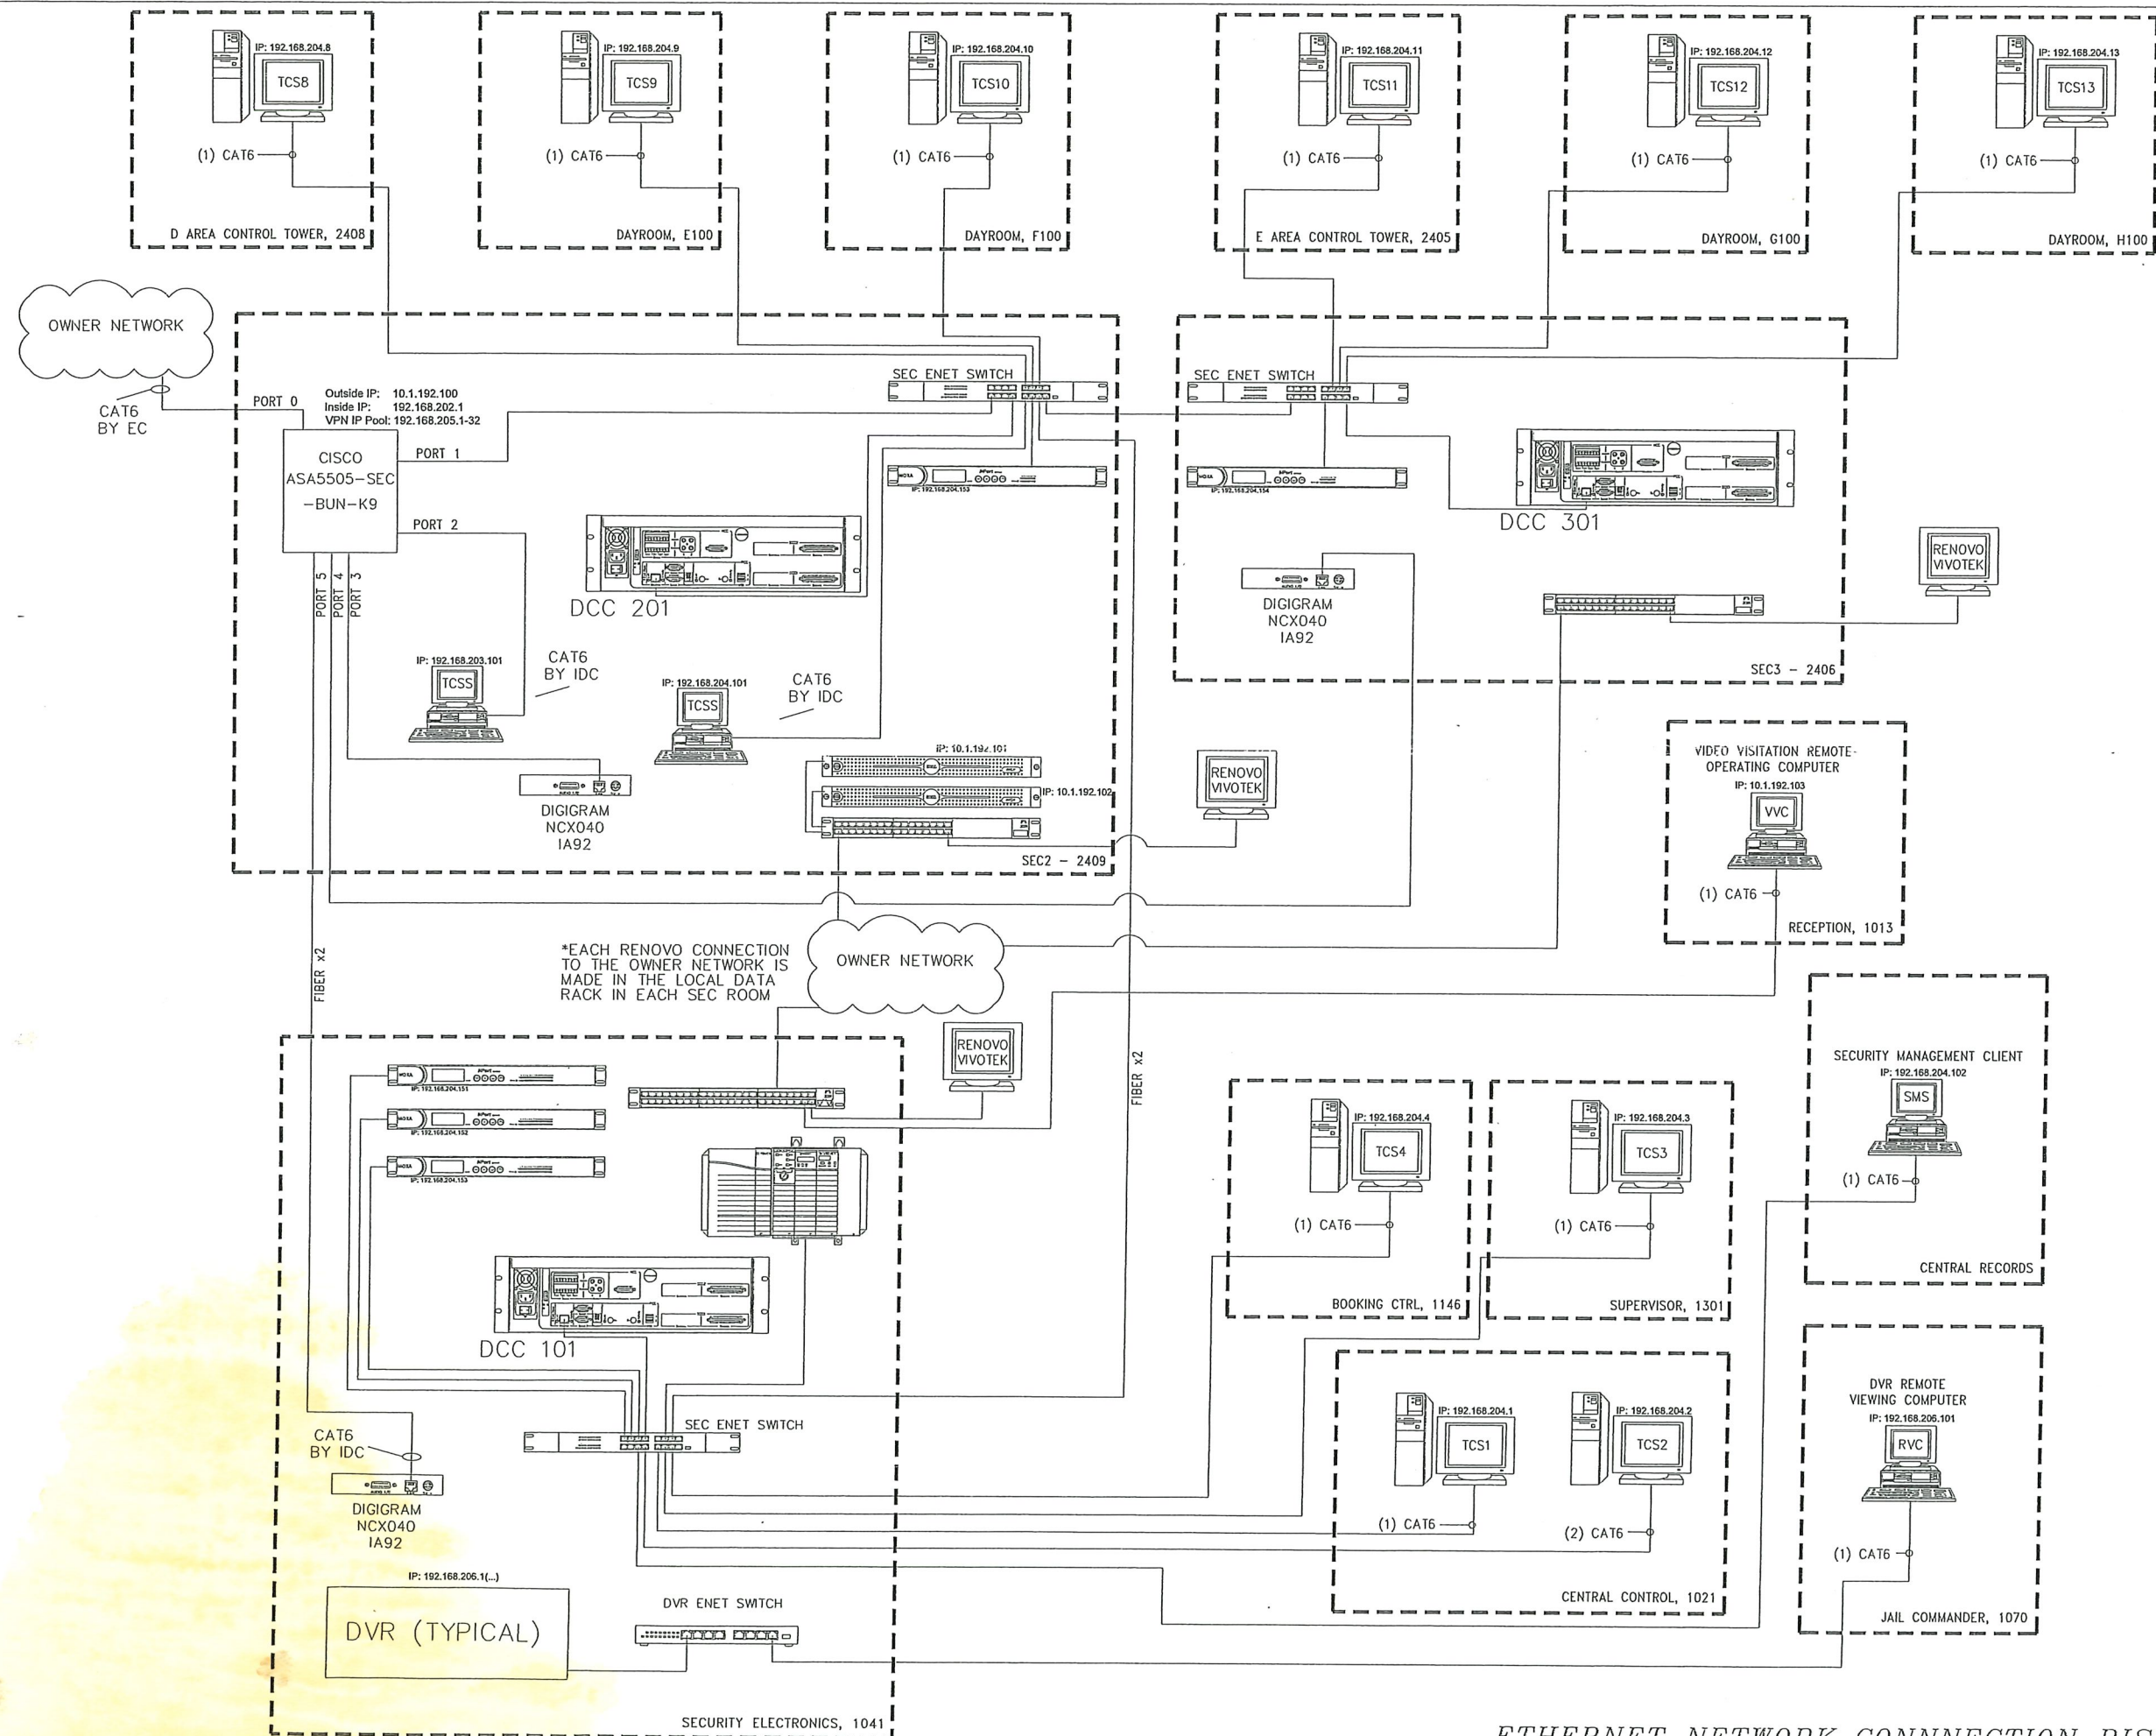

ETHERNET NETWORK CONNNECTION RISER

The information hereon is property of Stanley Security Solutions, Integrator.com Division and shall not be transmitted, copied, or used for purposes other than that for which it was intended.

STANLEY
integrator.com
14670 Cumberland Road
Noblesville, Indiana 46060
Phone: (317) 776-3500 Fax: (317) 776-3510
www.integrator.com

STANLEY
Security Solutions

TITLE
JACKSON COUNTY JAIL
JEFFERSON, GA
PLC DEVICENET RISER

JOB #: V.1666 JOB DATE: 2/25/2008
APPROVAL: JB APPROVAL DATE:

DESIGN: BRANDEN FRY

SOFTWARE: CHRIS MARLOW

PROJECT MANAGER: JASON BRYAN


REVISIONS

DESCRIPTION	BY	DATE
1		
2		
3		
4		
5		
6		

FILENAME: JCGA-ES050.0


DWG NO.

ES050.0

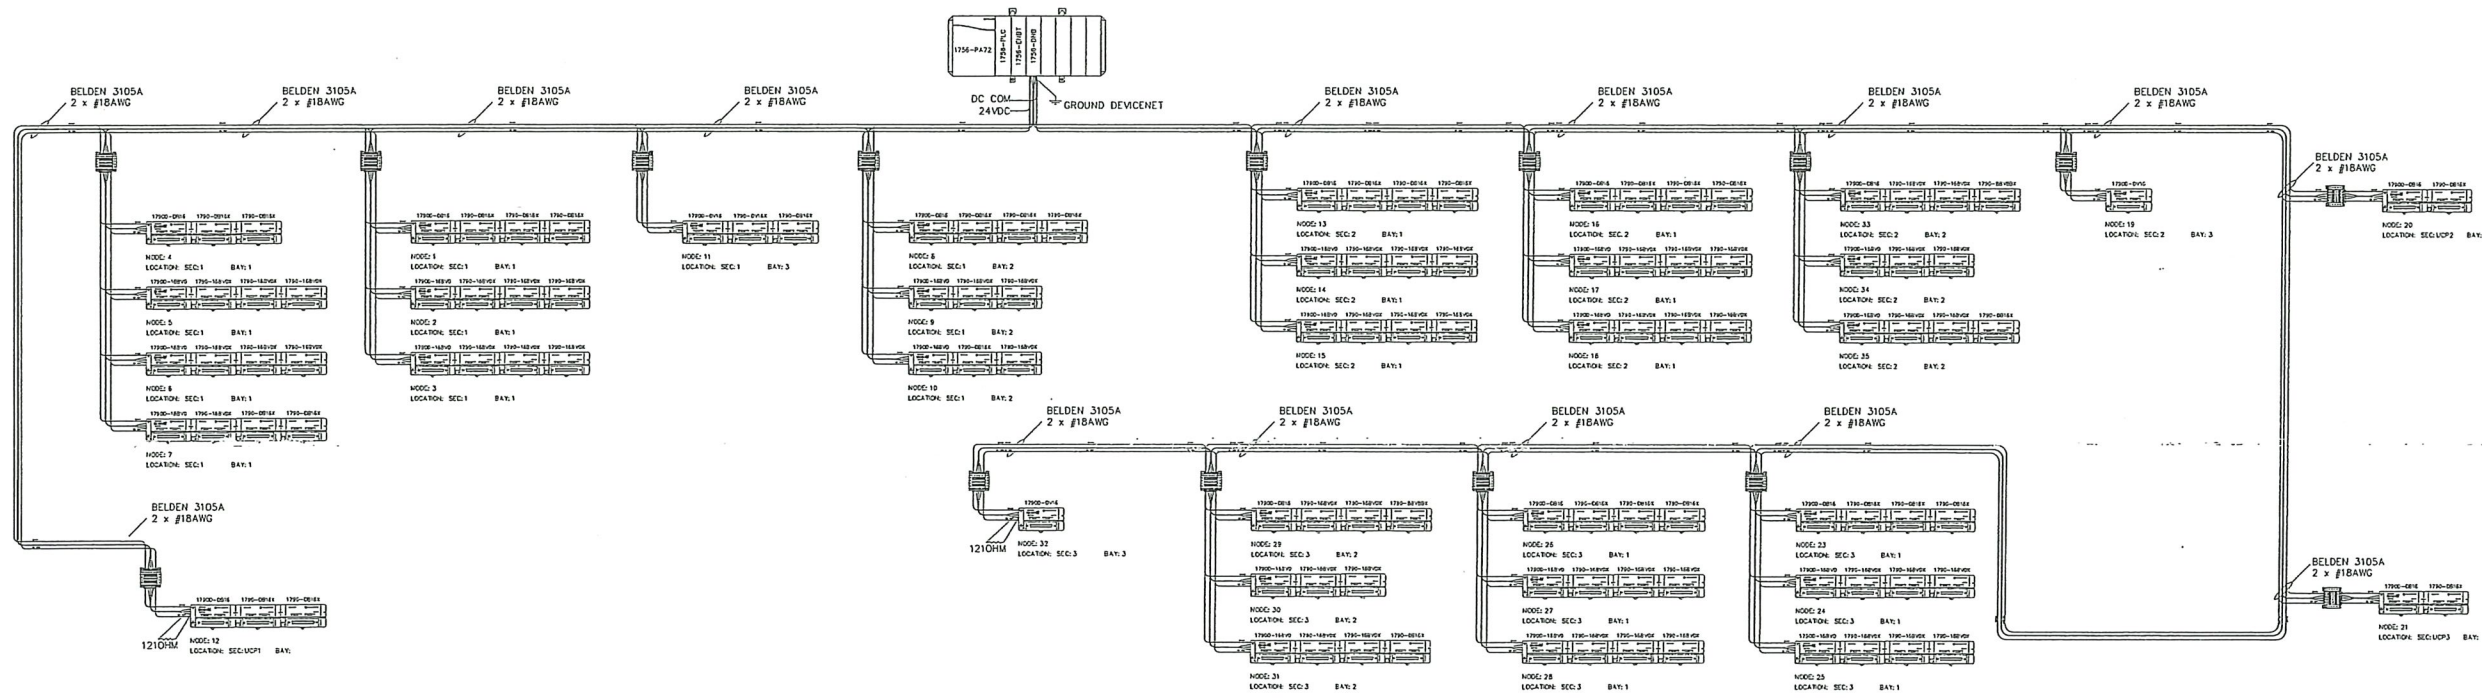

NOTES:

1. ALL WIRING BY INTEGRATOR.COM UNLESS OTHERWISE NOTED. FOR WIRING BY THE ELECTRICAL CONTRACTOR (E.C.), THE E.C. IS RESPONSIBLE FOR COMPLYING WITH ALL APPLICABLE WIRING AND INSTALLATION CODES, INCLUDING THE USE OF PLenum RATED WIRE AND CABLE WHERE IT MAY BE NECESSARY.
2. COMMUNICATIONS CABLES ARE TO BE RUN WITHOUT BREAKS, SPICES, TERMINALS, OR ANY OTHER INTERRUPTION BETWEEN AND WITHIN CABINETS. THIS IS WITHOUT EXCEPTION.

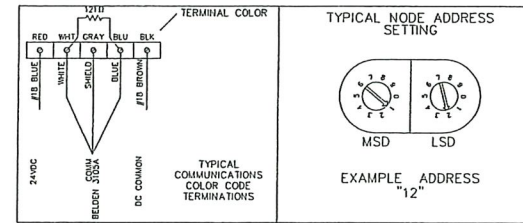

PLC DEVICENET RISER

The information hereon is property of Stanley Security Solutions, Integrator.com Division and shall not be transmitted, copied, or used for purposes other than that for which it was intended.

STANLEY
integrator.com
14670 Cumberland Road
Noblesville, Indiana 46060
Phone: (317) 776-3500 Fax: (317) 776-3510
www.integrator.com

STANLEY
Security Solutions

TITLE
JACKSON COUNTY JAIL

JEFFERSON, GA

CABINET LAYOUT

JOB #: V.1666
JOB DATE: 2/25/2008
APPROVAL: JB
APPROVAL DATE:


DESIGN: BRANDEN FRY
SOFTWARE: CHRIS MARLOW
PROJECT MANAGER: JASON BRYAN

REVISIONS	
DESCRIPTION	BY/DATE
1	
2	
3	
4	
5	
6	

FILENAME: JCGA-101.0.DWG

DWG NO.

ES101.0

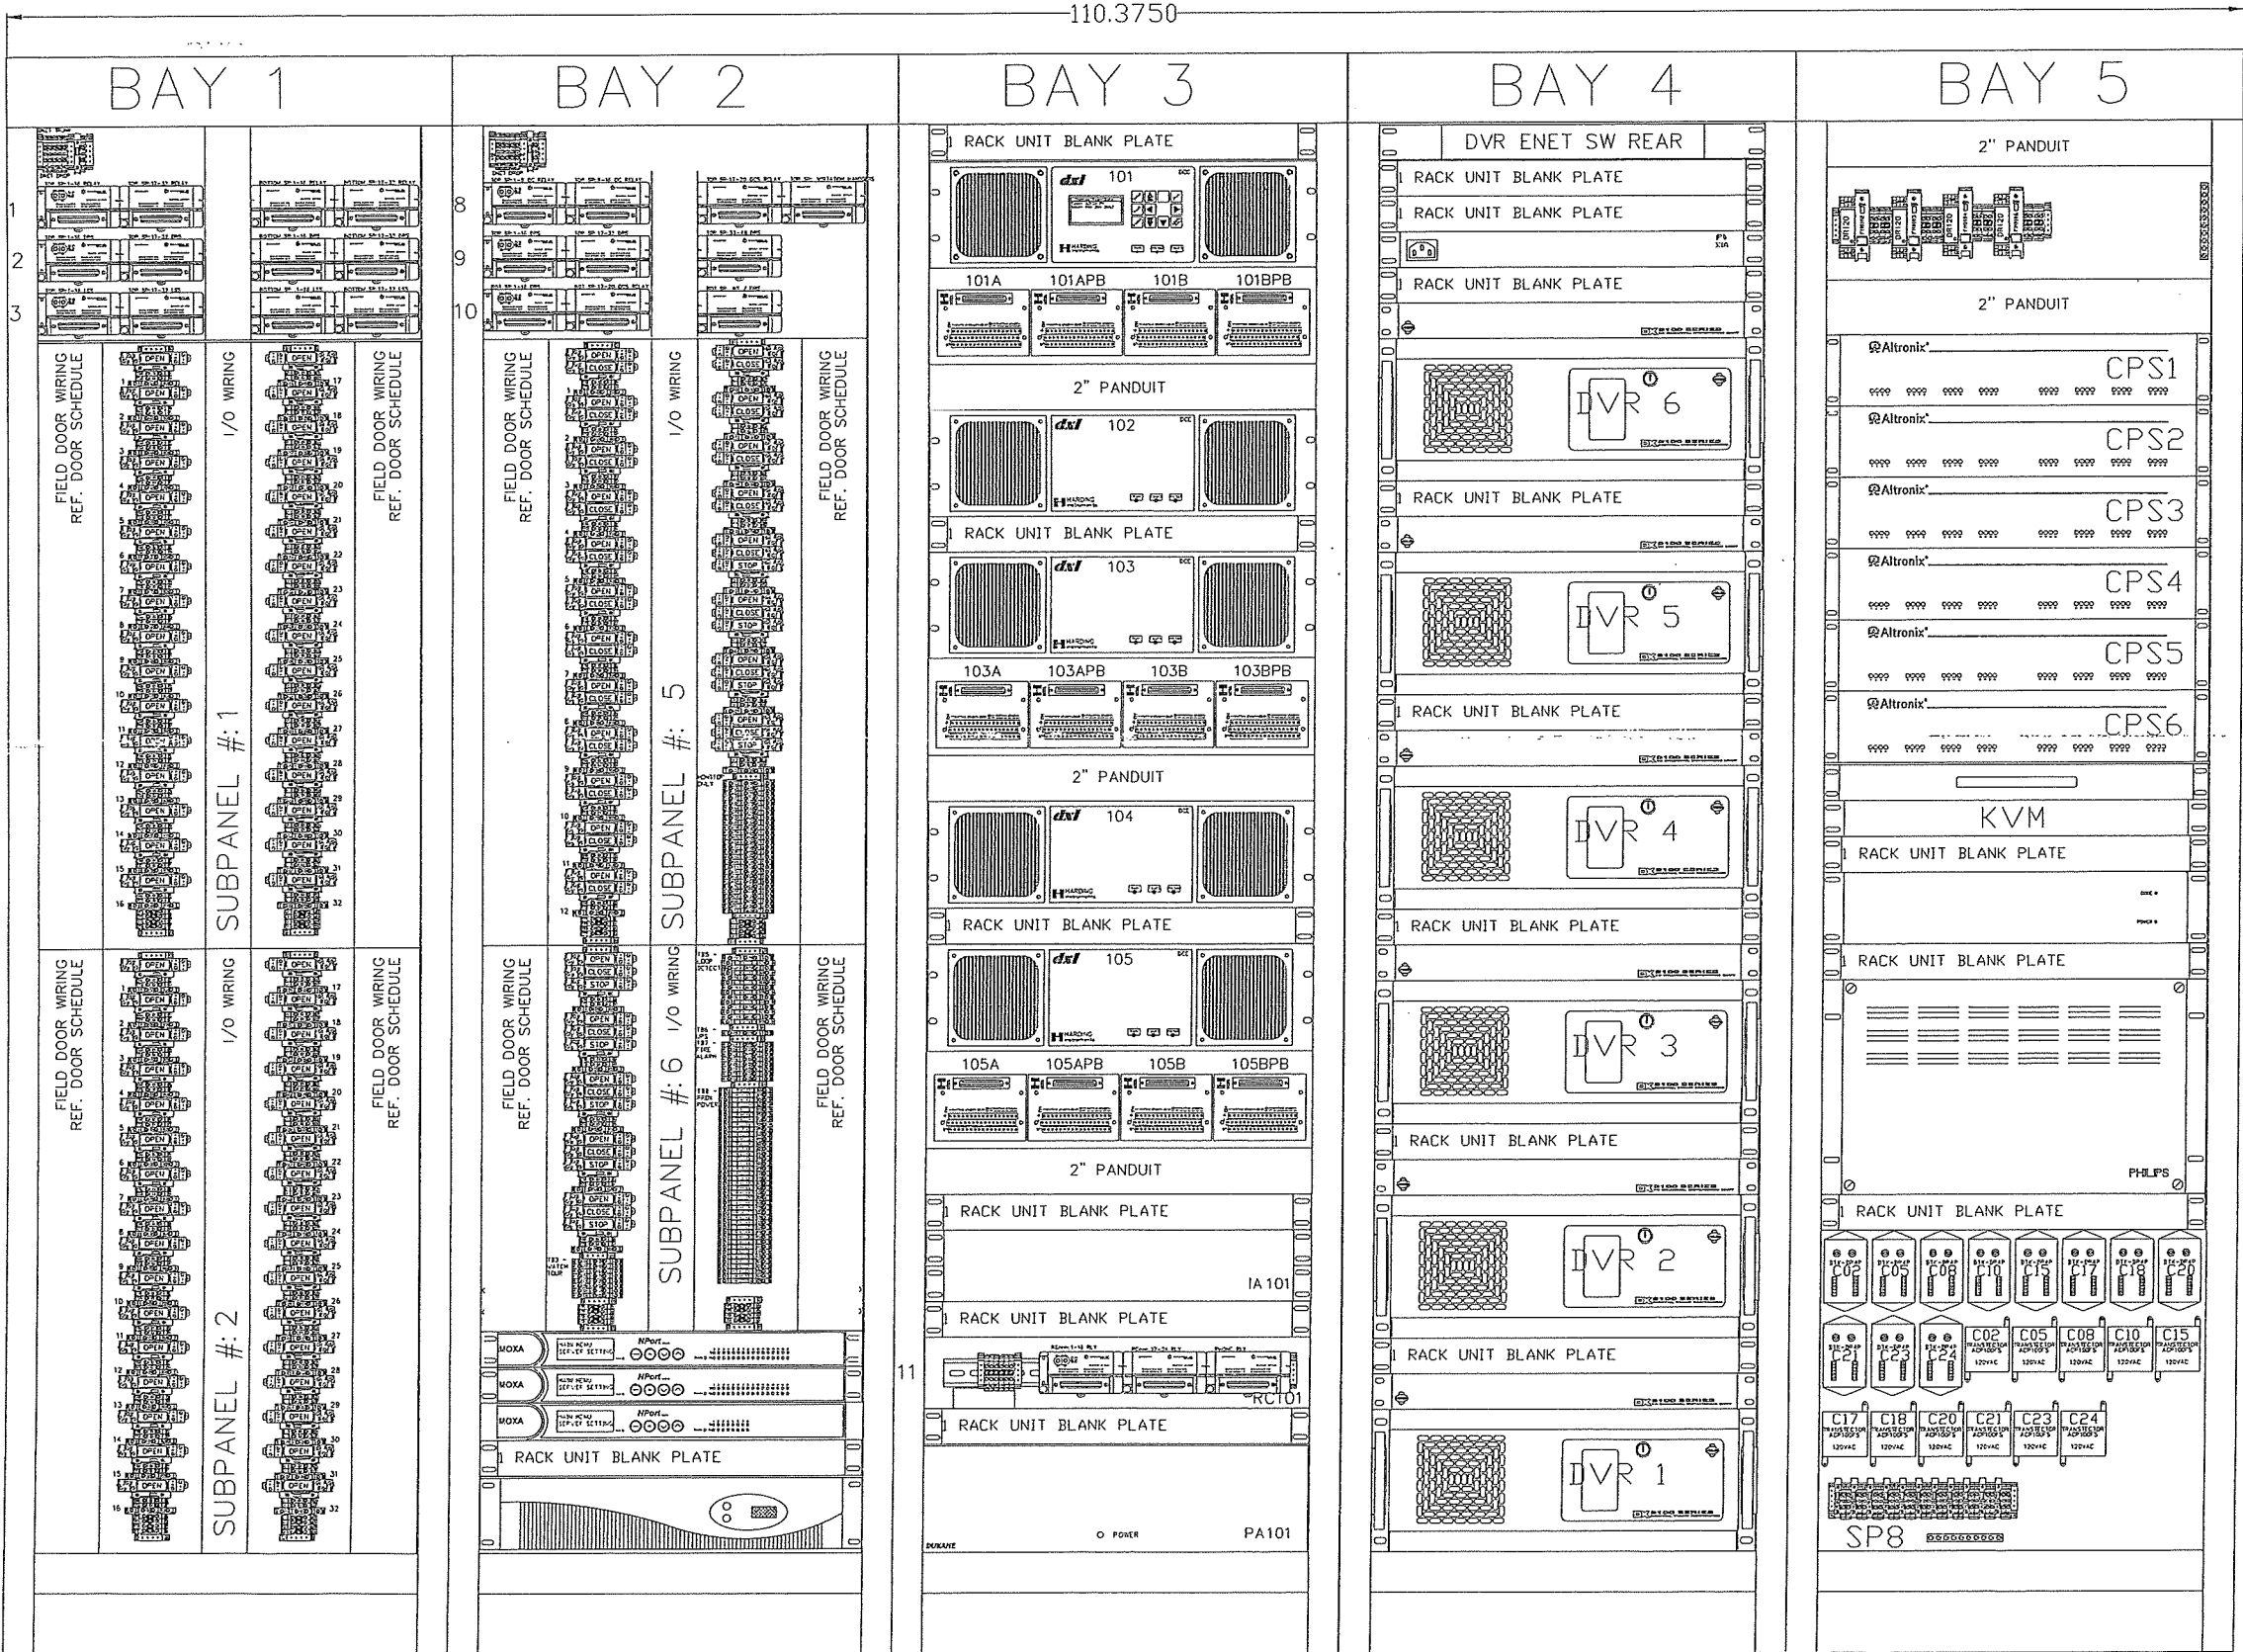

The information hereon is property of Stanley Security Solutions, Integrator.com Division and shall not be transmitted, copied, or used for purposes other than that for which it was intended.

STANLEY
integrator.com
14670 Cumberland Road
Noblesville, Indiana 46060
Phone: (317) 776-3500 Fax: (317) 776-3510
www.integrator.com

STANLEY
Security Solutions

TITLE
JACKSON COUNTY JAIL
JEFFERSON, GA
CABINET LAYOUT

JOB #: V.1666
APPROVAL: JB
DESIGN: BRANDEN FRY
SOFTWARE: CHRIS MARLOW
PROJECT MANAGER: JASON BRYAN

JOB DATE: 2/25/2008
APPROVAL DATE:
REVISIONS


DESCRIPTION	BY	DATE
1		
2		
3		
4		
5		
6		

FILENAME: JCGA-101.1.DWG

DWG NO.

ES101.1

110.3750

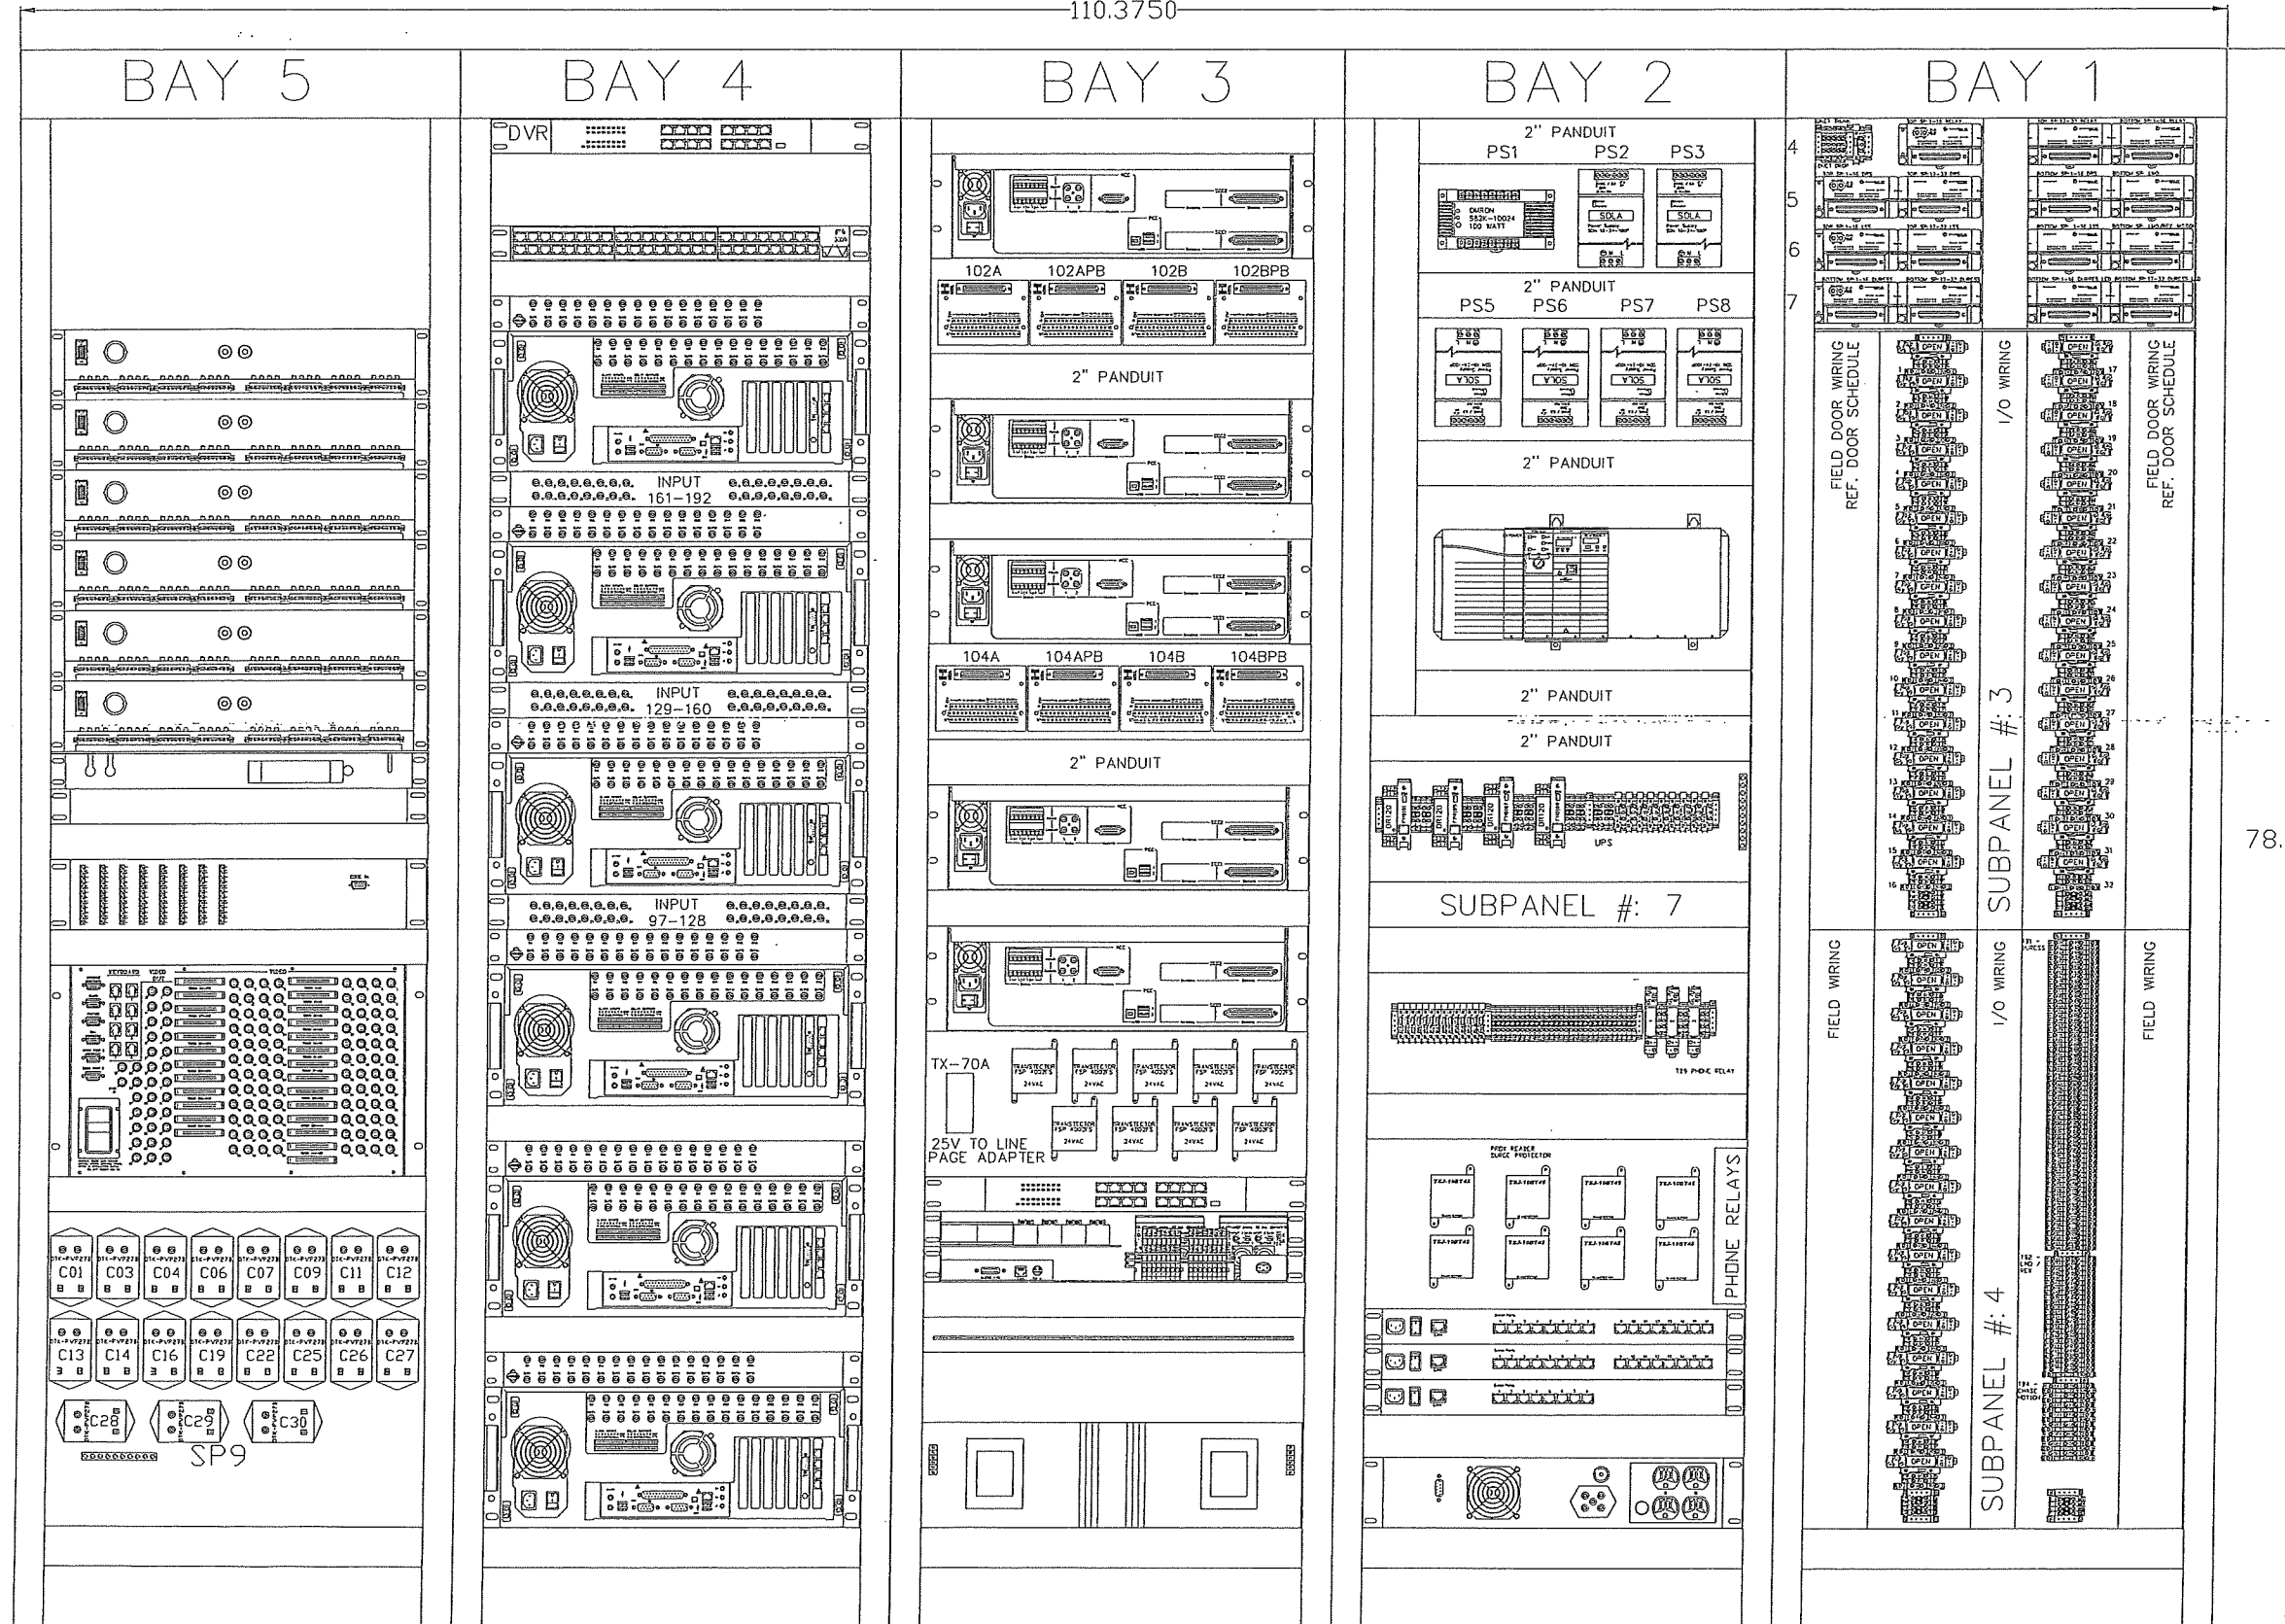

SEC 1 CABINET LAYOUT - REAR

The information hereon is property of Stanley Security Solutions, Integrator.com Division and shall not be transmitted, copied, or used for purposes other than that for which it was intended.

STANLEY integrator.com
14670 Cumberland Road
Noblesville, Indiana 46060
Phone: (317) 776-3500 Fax: (317) 776-3510
www.integrator.com

STANLEY Security Solutions

TITLE
JACKSON COUNTY JAIL
JEFFERSON, GA
POWER DISTRIBUTION

JOB #: V.1666 JOB DATE: 2/25/2008
APPROVAL: JB APPROVAL DATE:






DESIGN: BRANDEN FRY
SOFTWARE: CHRIS MARLOW
PROJECT MANAGER: JASON BRYAN

REVISIONS	
DESCRIPTION	BY/DATE
1	
2	
3	
4	
5	
6	

FILENAME: JCGA-101.2.DWG

DWG NO.

ES101.2

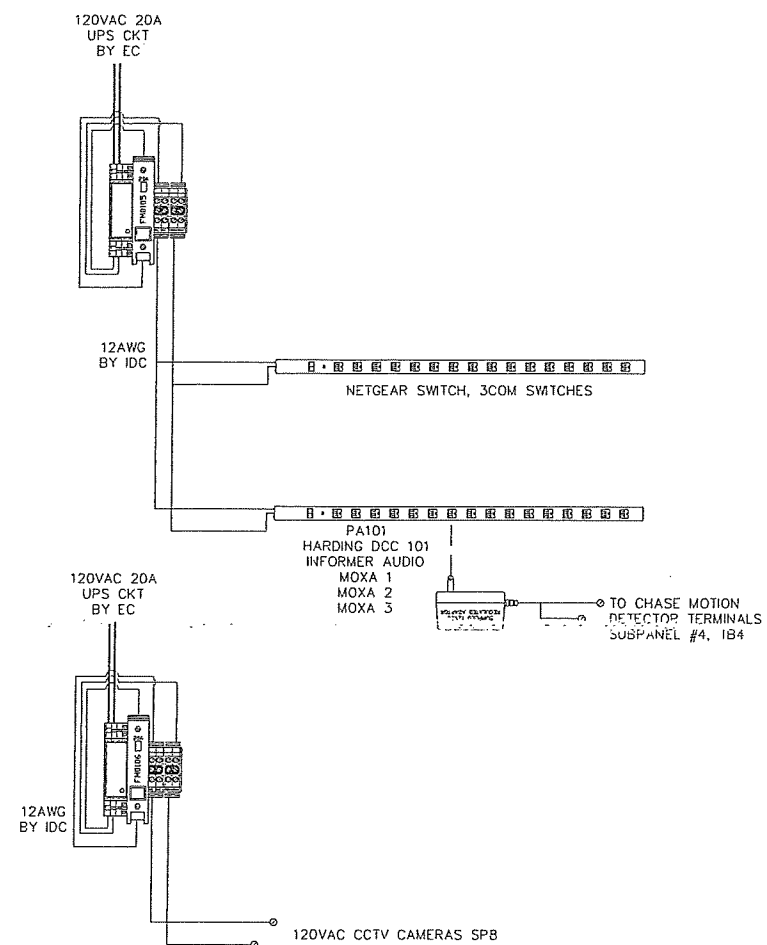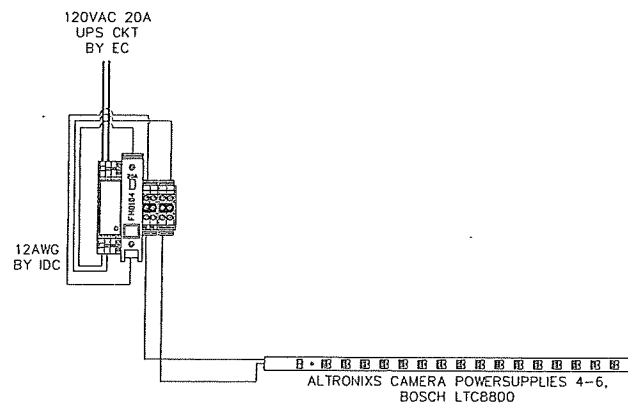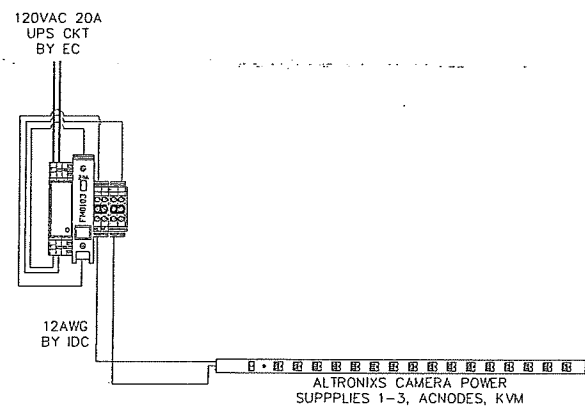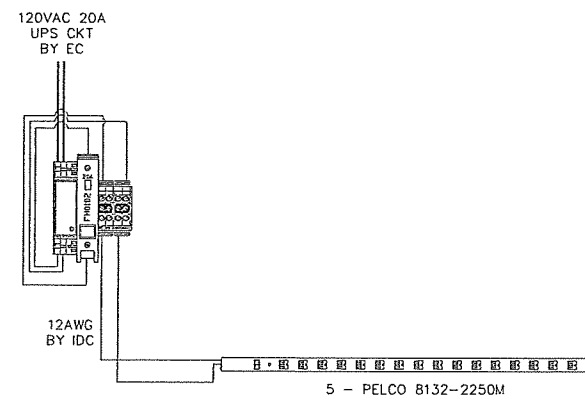
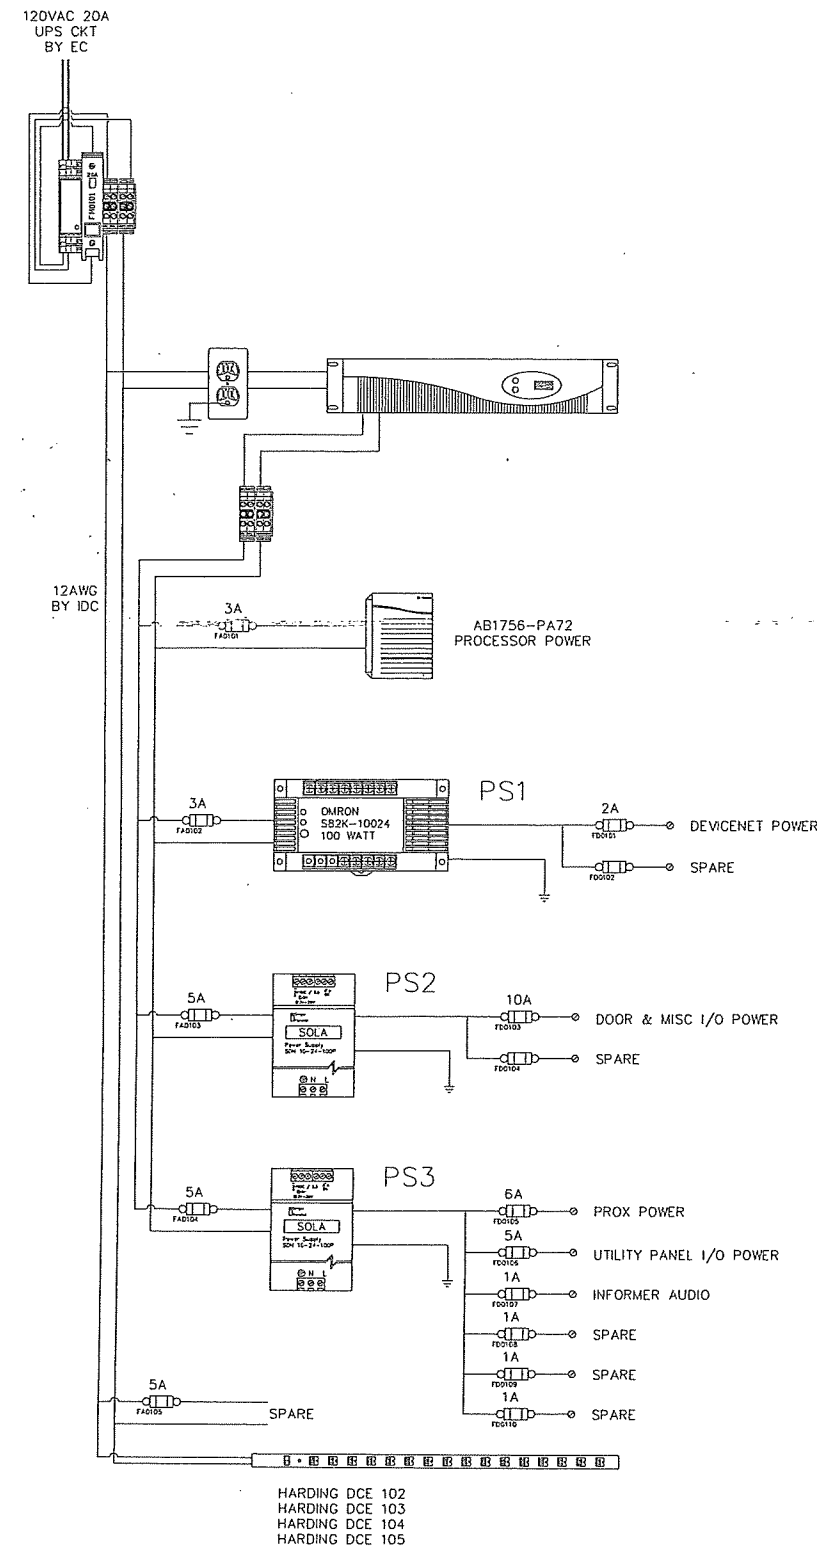


The information hereon is property of Stanley Security Solutions, integrator.com Division and shall not be transmitted, copied, or used for purposes other than that for which it was intended.


STANLEY
integrator.com
14670 Cumberland Road
Noblesville, Indiana 46060
Phone: (317) 776-3500 Fax: (317) 776-3510
www.integrator.com

STANLEY
Security Solutions


TITLE	
JACKSON COUNTY JAIL	
JEFFERSON, GA	
POWER DISTRIBUTION	
JOB #:	JOB DATE:
V.1666	2/25/2008
APPROVAL:	APPROVAL DATE:
JB	
DESIGN:	
BRANDEN FRY	
SOFTWARE:	
CHRIS MARLOW	
PROJECT MANAGER:	
JASON BRYAN	
REVISIONS	
DESCRIPTION	BY/DATE
1	
2	
3	
4	
5	
6	
FILENAME: JCGA-101.3.DWG	
DWG NO.	
ES101.3	

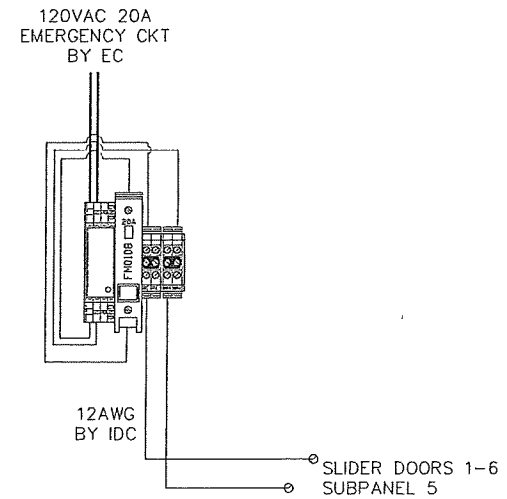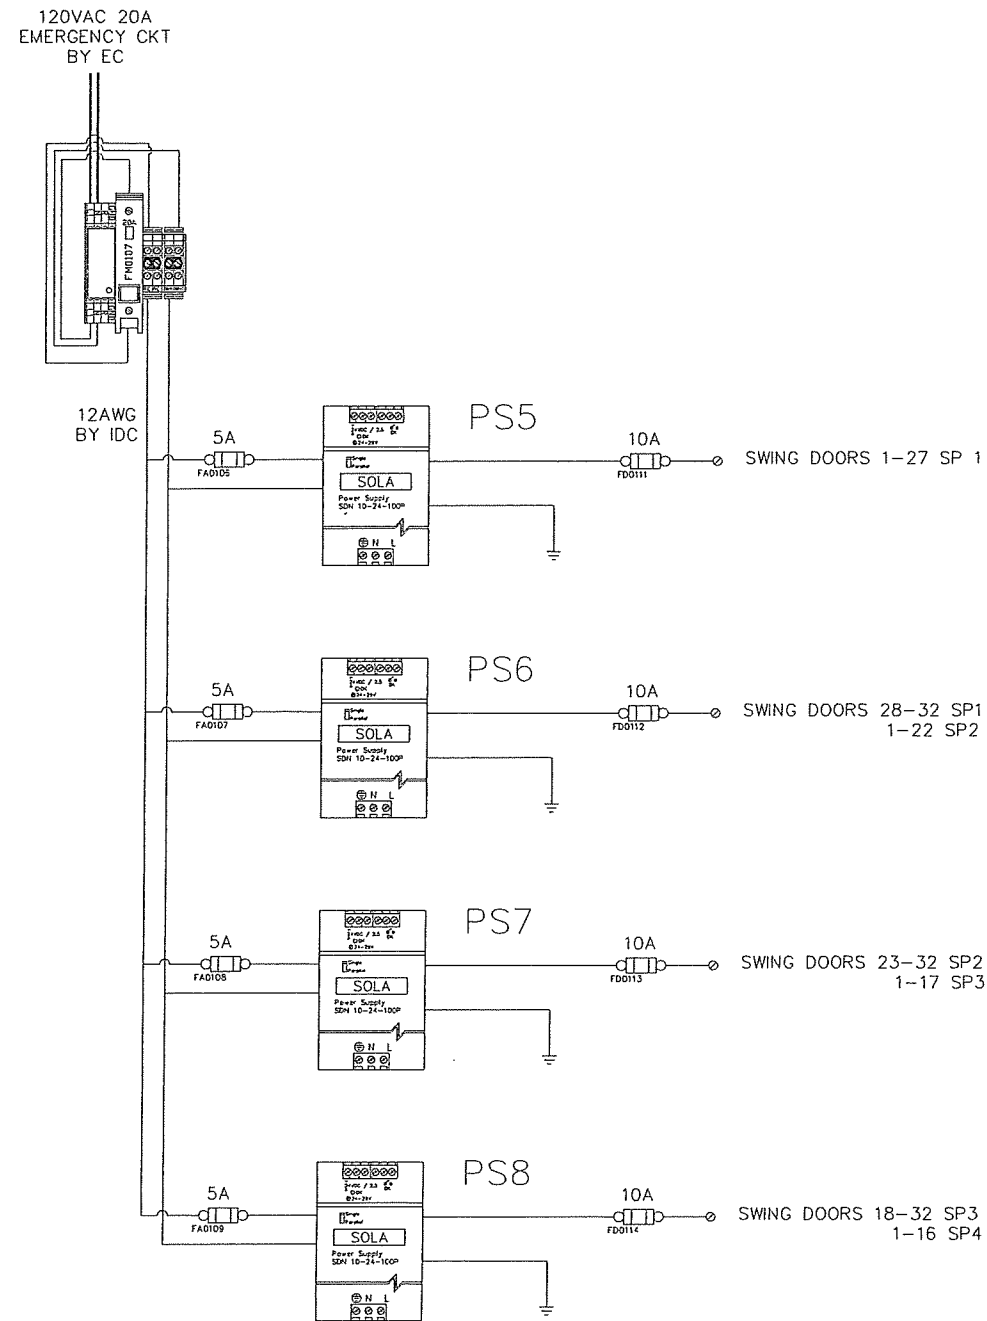

FIELD DOOR WIRING
REF. DOOR SCHEDULE

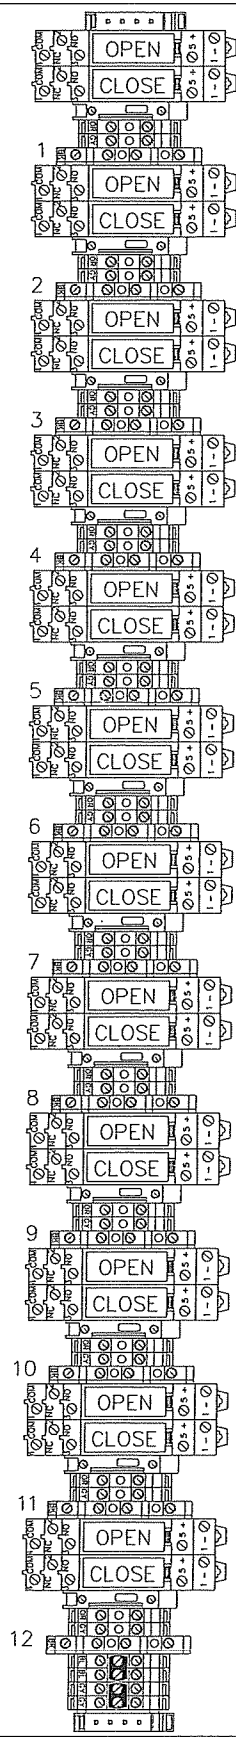

I/O WIRING
SUBPANEL #: 5

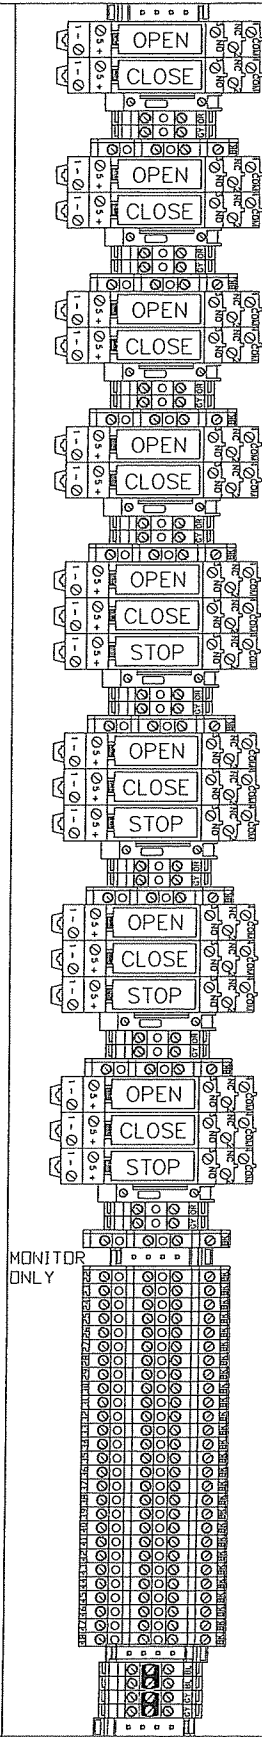

FIELD DOOR WIRING
REF. DOOR SCHEDULE

SEC1 SUBPANEL #5 TERMINAL DETAIL

The information hereon is property of Stanley Security Solutions, integrator.com Division and shall not be transmitted, copied, or used for purposes other than that for which it was intended.

STANLEY
integrator.com
14670 Cumberland Road
Noblesville, Indiana 46060
Phone: (317) 776-3500 Fax: (317) 776-3510
www.integrator.com

STANLEY
Security Solutions

TITLE
JACKSON COUNTY JAIL

JEFFERSON, GA
TERMINAL DETAIL

JOB #: V.1666
JOB DATE: 2/25/2008
APPROVAL: JB
APPROVAL DATE:


DESIGN: BRANDEN FRY
SOFTWARE: CHRIS MARLOW
PROJECT MANAGER: JASON BRYAN

REVISIONS		BY/DATE
DESCRIPTION		
1		
2		
3		
4		
5		
6		

FILENAME: JCGA-101.4.DWG

DWG NO.

ES101.4

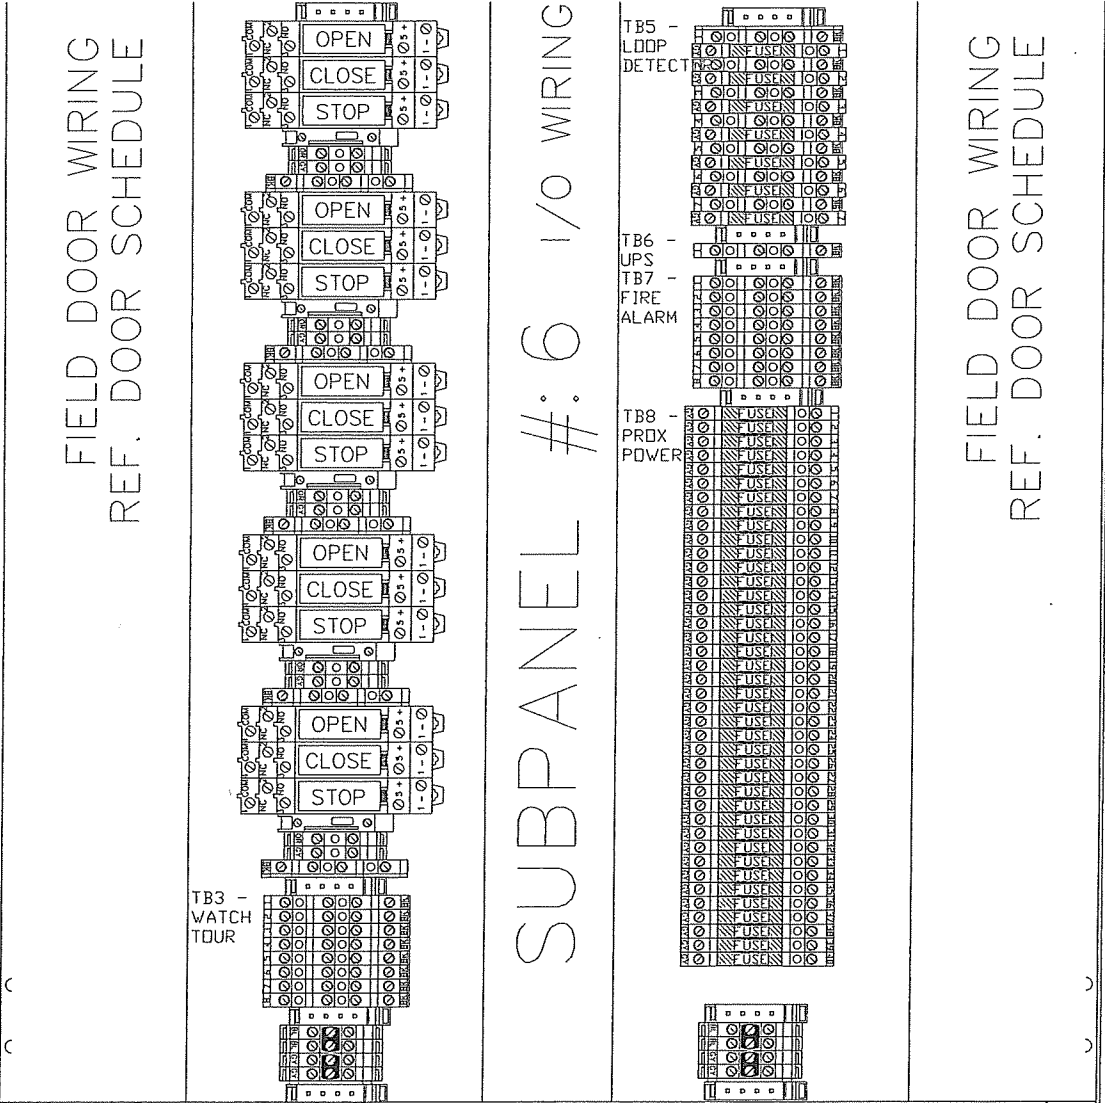

SEC1 SUBPANEL #6 TERMINAL DETAIL

The information hereon is property of Stanley Security Solutions, integrator.com Division and shall not be transmitted, copied, or used for purposes other than that for which it was intended.

STANLEY


integrator.com

14670 Cumberland Road
Noblesville, Indiana 46060
Phone: (317) 776-3500 Fax: (317) 776-3510
www.integrator.com



STANLEY

Security Solutions

TITLE	
JACKSON COUNTY JAIL	
JEFFERSON, GA	
TERMINAL DETAIL	
JOB #:	JOB DATE:
V.1666	2/25/2008
APPROVAL:	APPROVAL DATE:
JB	
DESIGN: BRANDEN FRY	
SOFTWARE: CHRIS MARLOW	
PROJECT MANAGER: JASON BRYAN	
REVISIONS	
DESCRIPTION	BY/DATE
1	
2	
3	
4	
5	
6	
FILENAME: JCGA-101.5.DWG	
DWG NO.	
ES101.5	

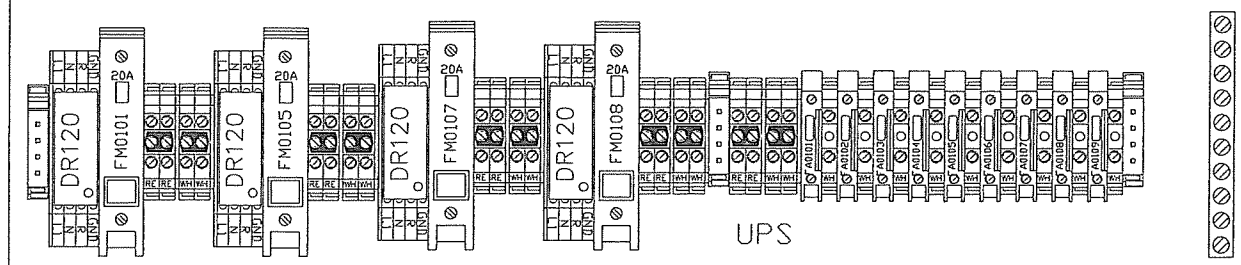

SUBPANEL #: 7

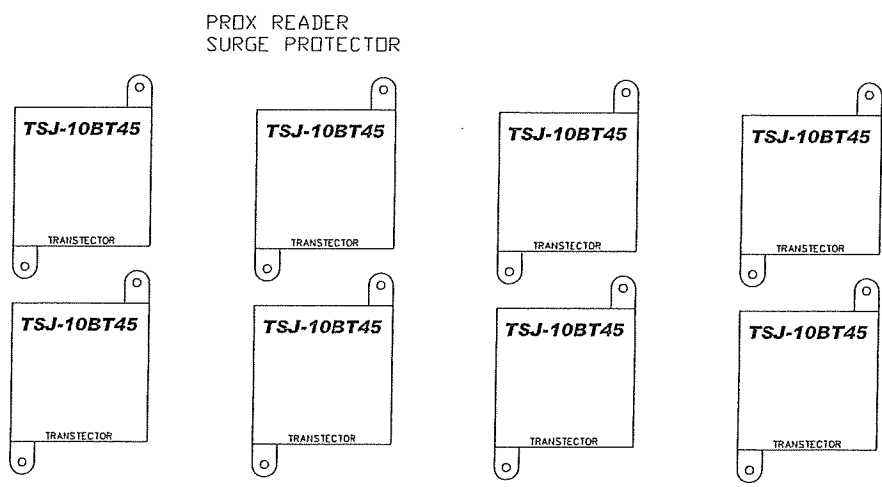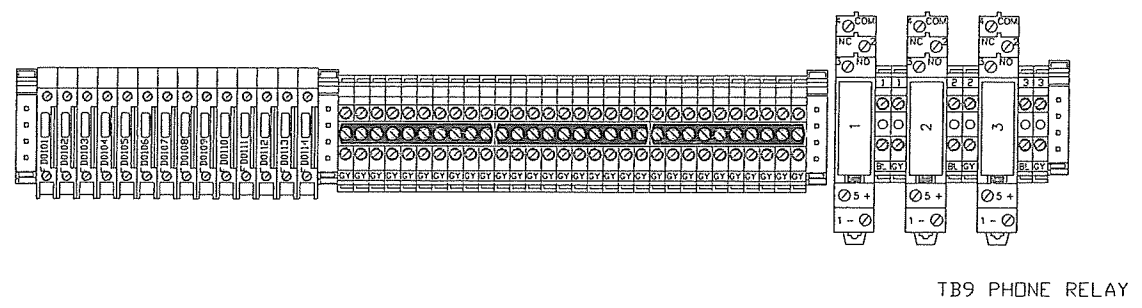

SEC1 SUBPANEL #7 TERMINAL DETAIL

The information hereon is property of Stanley Security Solutions, Integrator.com Division and shall not be transmitted, copied, or used for purposes other than that for which it was intended.

STANLEY
integrator.com
14670 Cumberland Road
Noblesville, Indiana 46060
Phone: (317) 776-3500 Fax: (317) 776-3510
www.integrator.com

STANLEY
Security Solutions

TITLE	
JACKSON COUNTY JAIL	
JEFFERSON, GA	
TERMINAL DETAIL	
JOB #: V.1666	JOB DATE: 2/25/2008
APPROVAL: JB	APPROVAL DATE:
DESIGN: BRANDEN FRY	
SOFTWARE: CHRIS MARLOW	
PROJECT MANAGER: JASON BRYAN	
REVISIONS	
DESCRIPTION	BY/DATE
1	
2	
3	
4	
5	
6	
FILENAME: JCGA-101.6.DWG	
DWG NO.	
ES101.6	

The information hereon is property of Stanley Security Solutions, integrator.com Division and shall not be transmitted, copied, or used for purposes other than that for which it was intended.

STANLEY
integrator.com
14570 Cumberland Road
Noblesville, Indiana 46060
Phone: (317) 776-3500 Fax: (317) 776-3510
www.integrator.com

STANLEY
Security Solutions

TITLE
JACKSON COUNTY JAIL

JEFFERSON, GA
TERMINAL DETAIL

JOB #: V.1666	JOB DATE: 2/25/2008
APPROVAL: JB	APPROVAL DATE:

DESIGN:
BRANDEN FRY

SOFTWARE:
CHRIS MARLOW


PROJECT MANAGER:
JASON BRYAN

REVISIONS		BY/
DESCRIPTION	DATE	
1		
2		
3		
4		
5		
6		

FILENAME: JCGA-101.7.DWG

DWG NO.

ES101.7

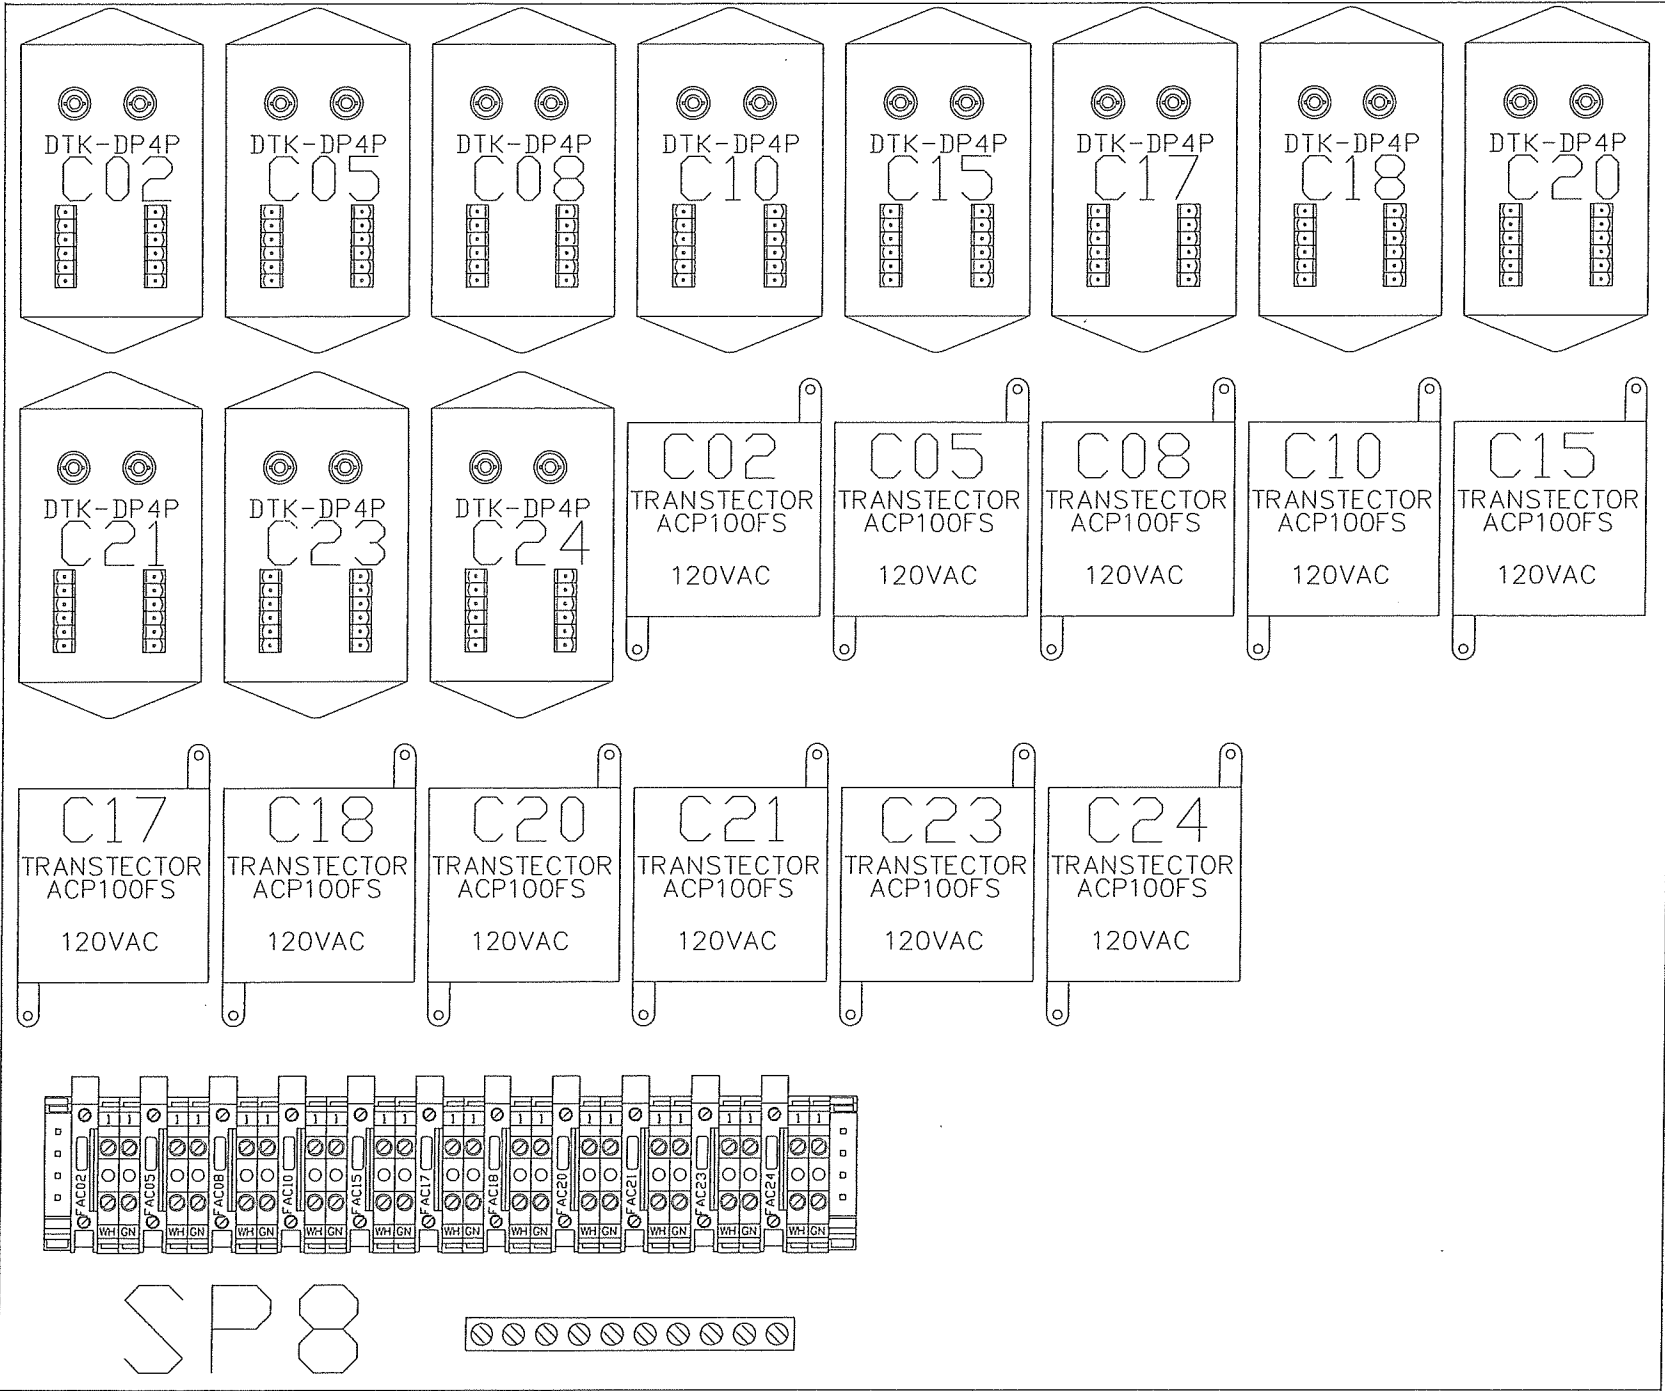

SEC1 SUBPANEL #8 TERMINAL DETAIL

The information hereon is property of Stanley Security Solutions, Integrator.com Division and shall not be transmitted, copied, or used for purposes other than that for which it was intended.

STANLEY
integrator.com
14670 Cumberland Road
Noblesville, Indiana 46060
Phone: (317) 776-3500 Fax: (317) 776-3510
www.integrator.com

STANLEY
Security Solutions

TITLE
JACKSON COUNTY JAIL

JEFFERSON, GA

TERMINAL DETAIL

JOB #:	V.1666	JOB DATE:	2/25/2008
APPROVAL:	JB	APPROVAL DATE:	

DESIGN: **BRANDEN FRY**

SOFTWARE: **CHRIS MARLOW**

PROJECT MANAGER: **JASON BRYAN**


REVISIONS

DESCRIPTION	BY/DATE
1	
2	
3	
4	
5	
6	


FILENAME: JCGA-101.8.DWG

DWG NO.

ES101.8

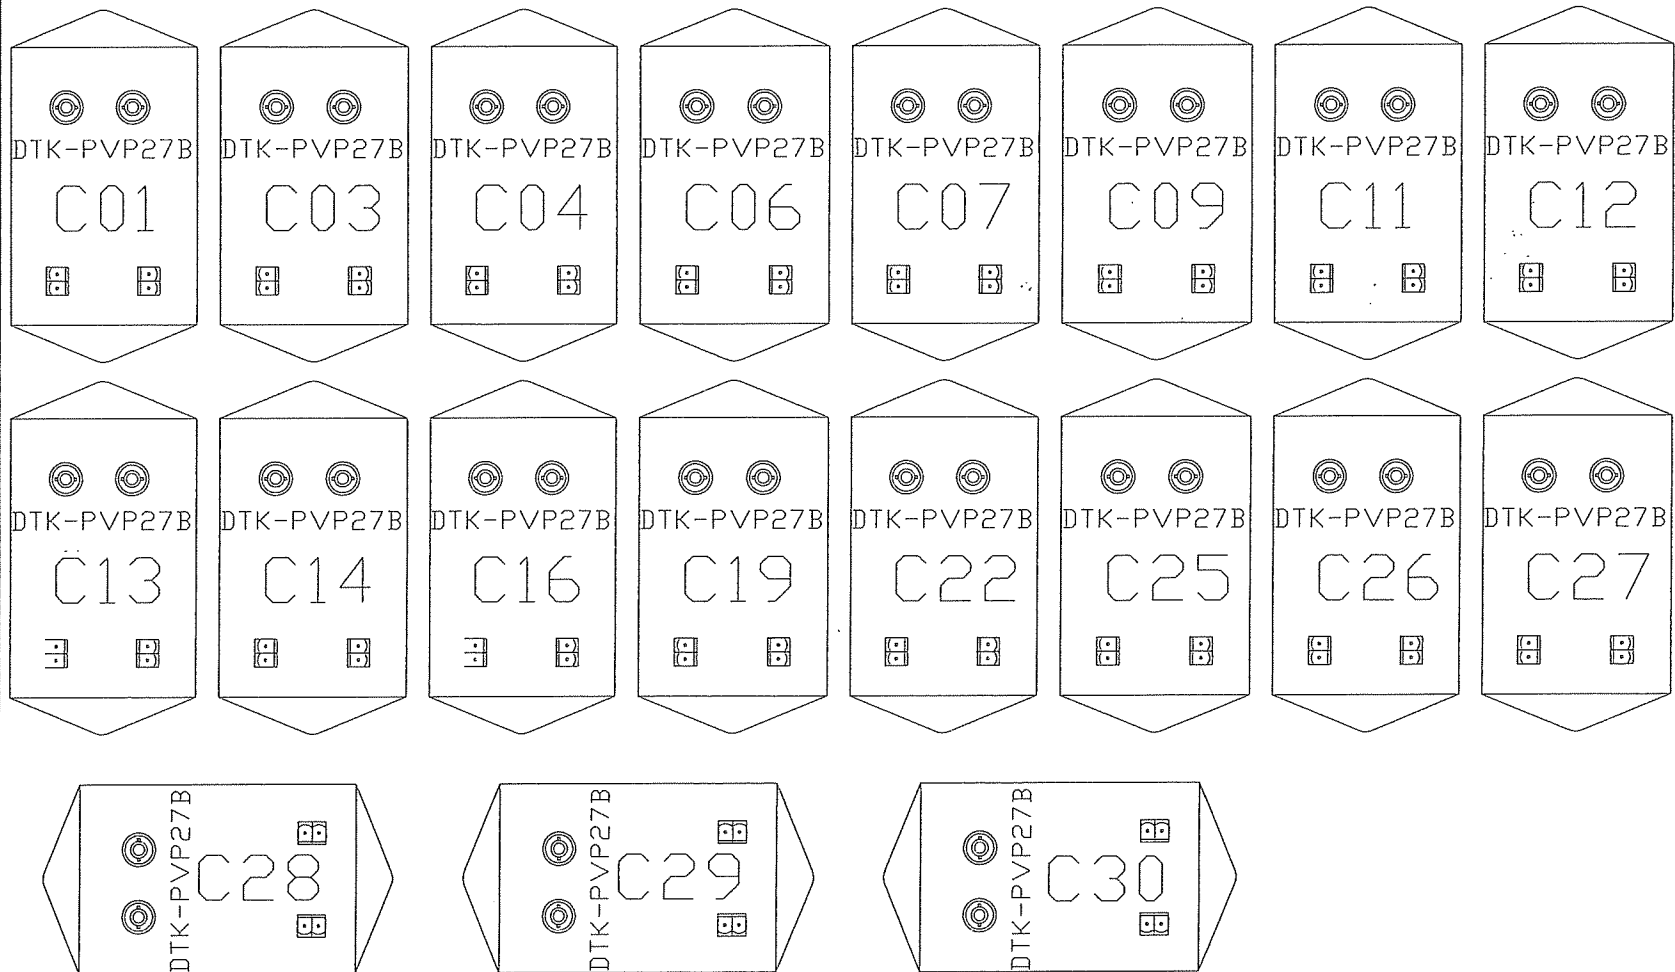

SEC1 SUBPANEL #9 TERMINAL DETAIL

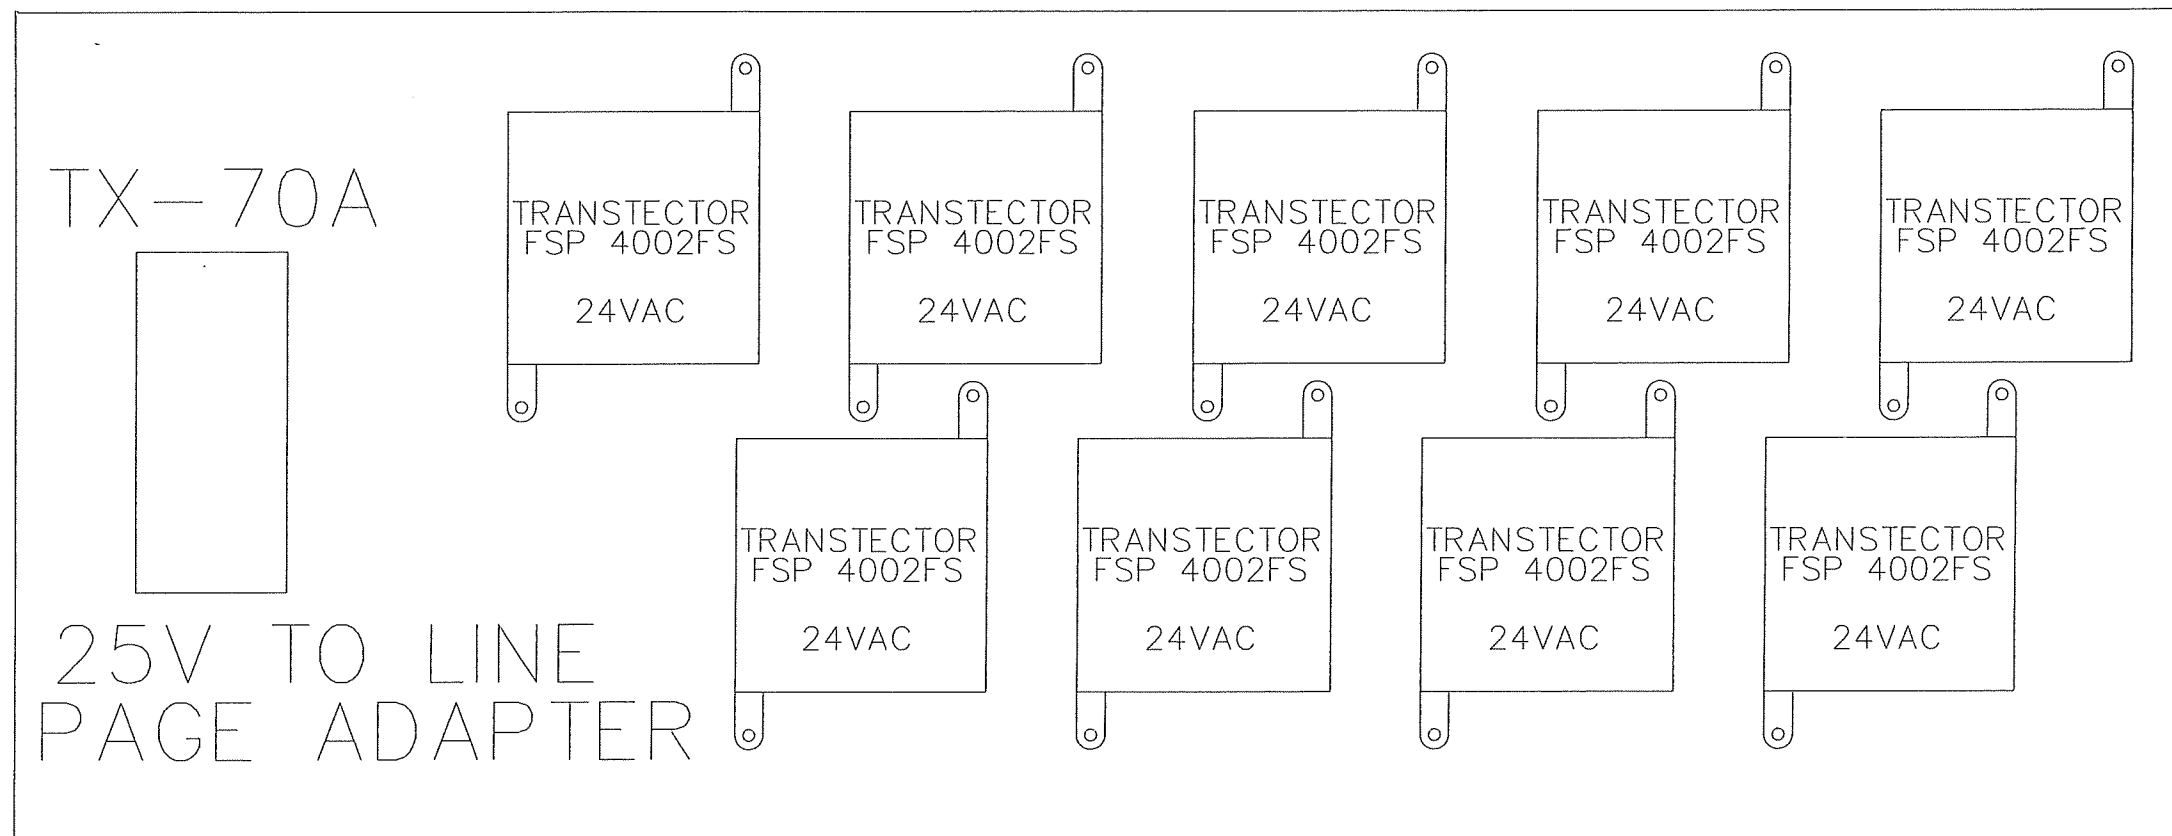

The information hereon is property of Stanley Security Solutions, integrator.com Division and shall not be transmitted, copied, or used for purposes other than that for which it was intended.


STANLEY
integrator.com
14670 Cumberland Road
Noblesville, Indiana 46060
Phone: (317) 776-3500 Fax: (317) 776-3510
www.integrator.com

STANLEY
Security Solutions

TITLE	
JACKSON COUNTY JAIL	
JEFFERSON, GA	
TERMINAL DETAIL	
JOB #: V.1666	JOB DATE: 2/25/2008
APPROVAL: JB	APPROVAL DATE:
DESIGN: BRANDEN FRY	
SOFTWARE: CHRIS MARLOW	
PROJECT MANAGER: JASON BRYAN	
REVISIONS	
DESCRIPTION	BY/ DATE
1	
2	
3	
4	
5	
6	
FILENAME: JCGA--101.9.DWG	
DWG NO.	
ES101.9	

SEC1 SIDE INTERCOM TERMINAL DETAIL

88.2500

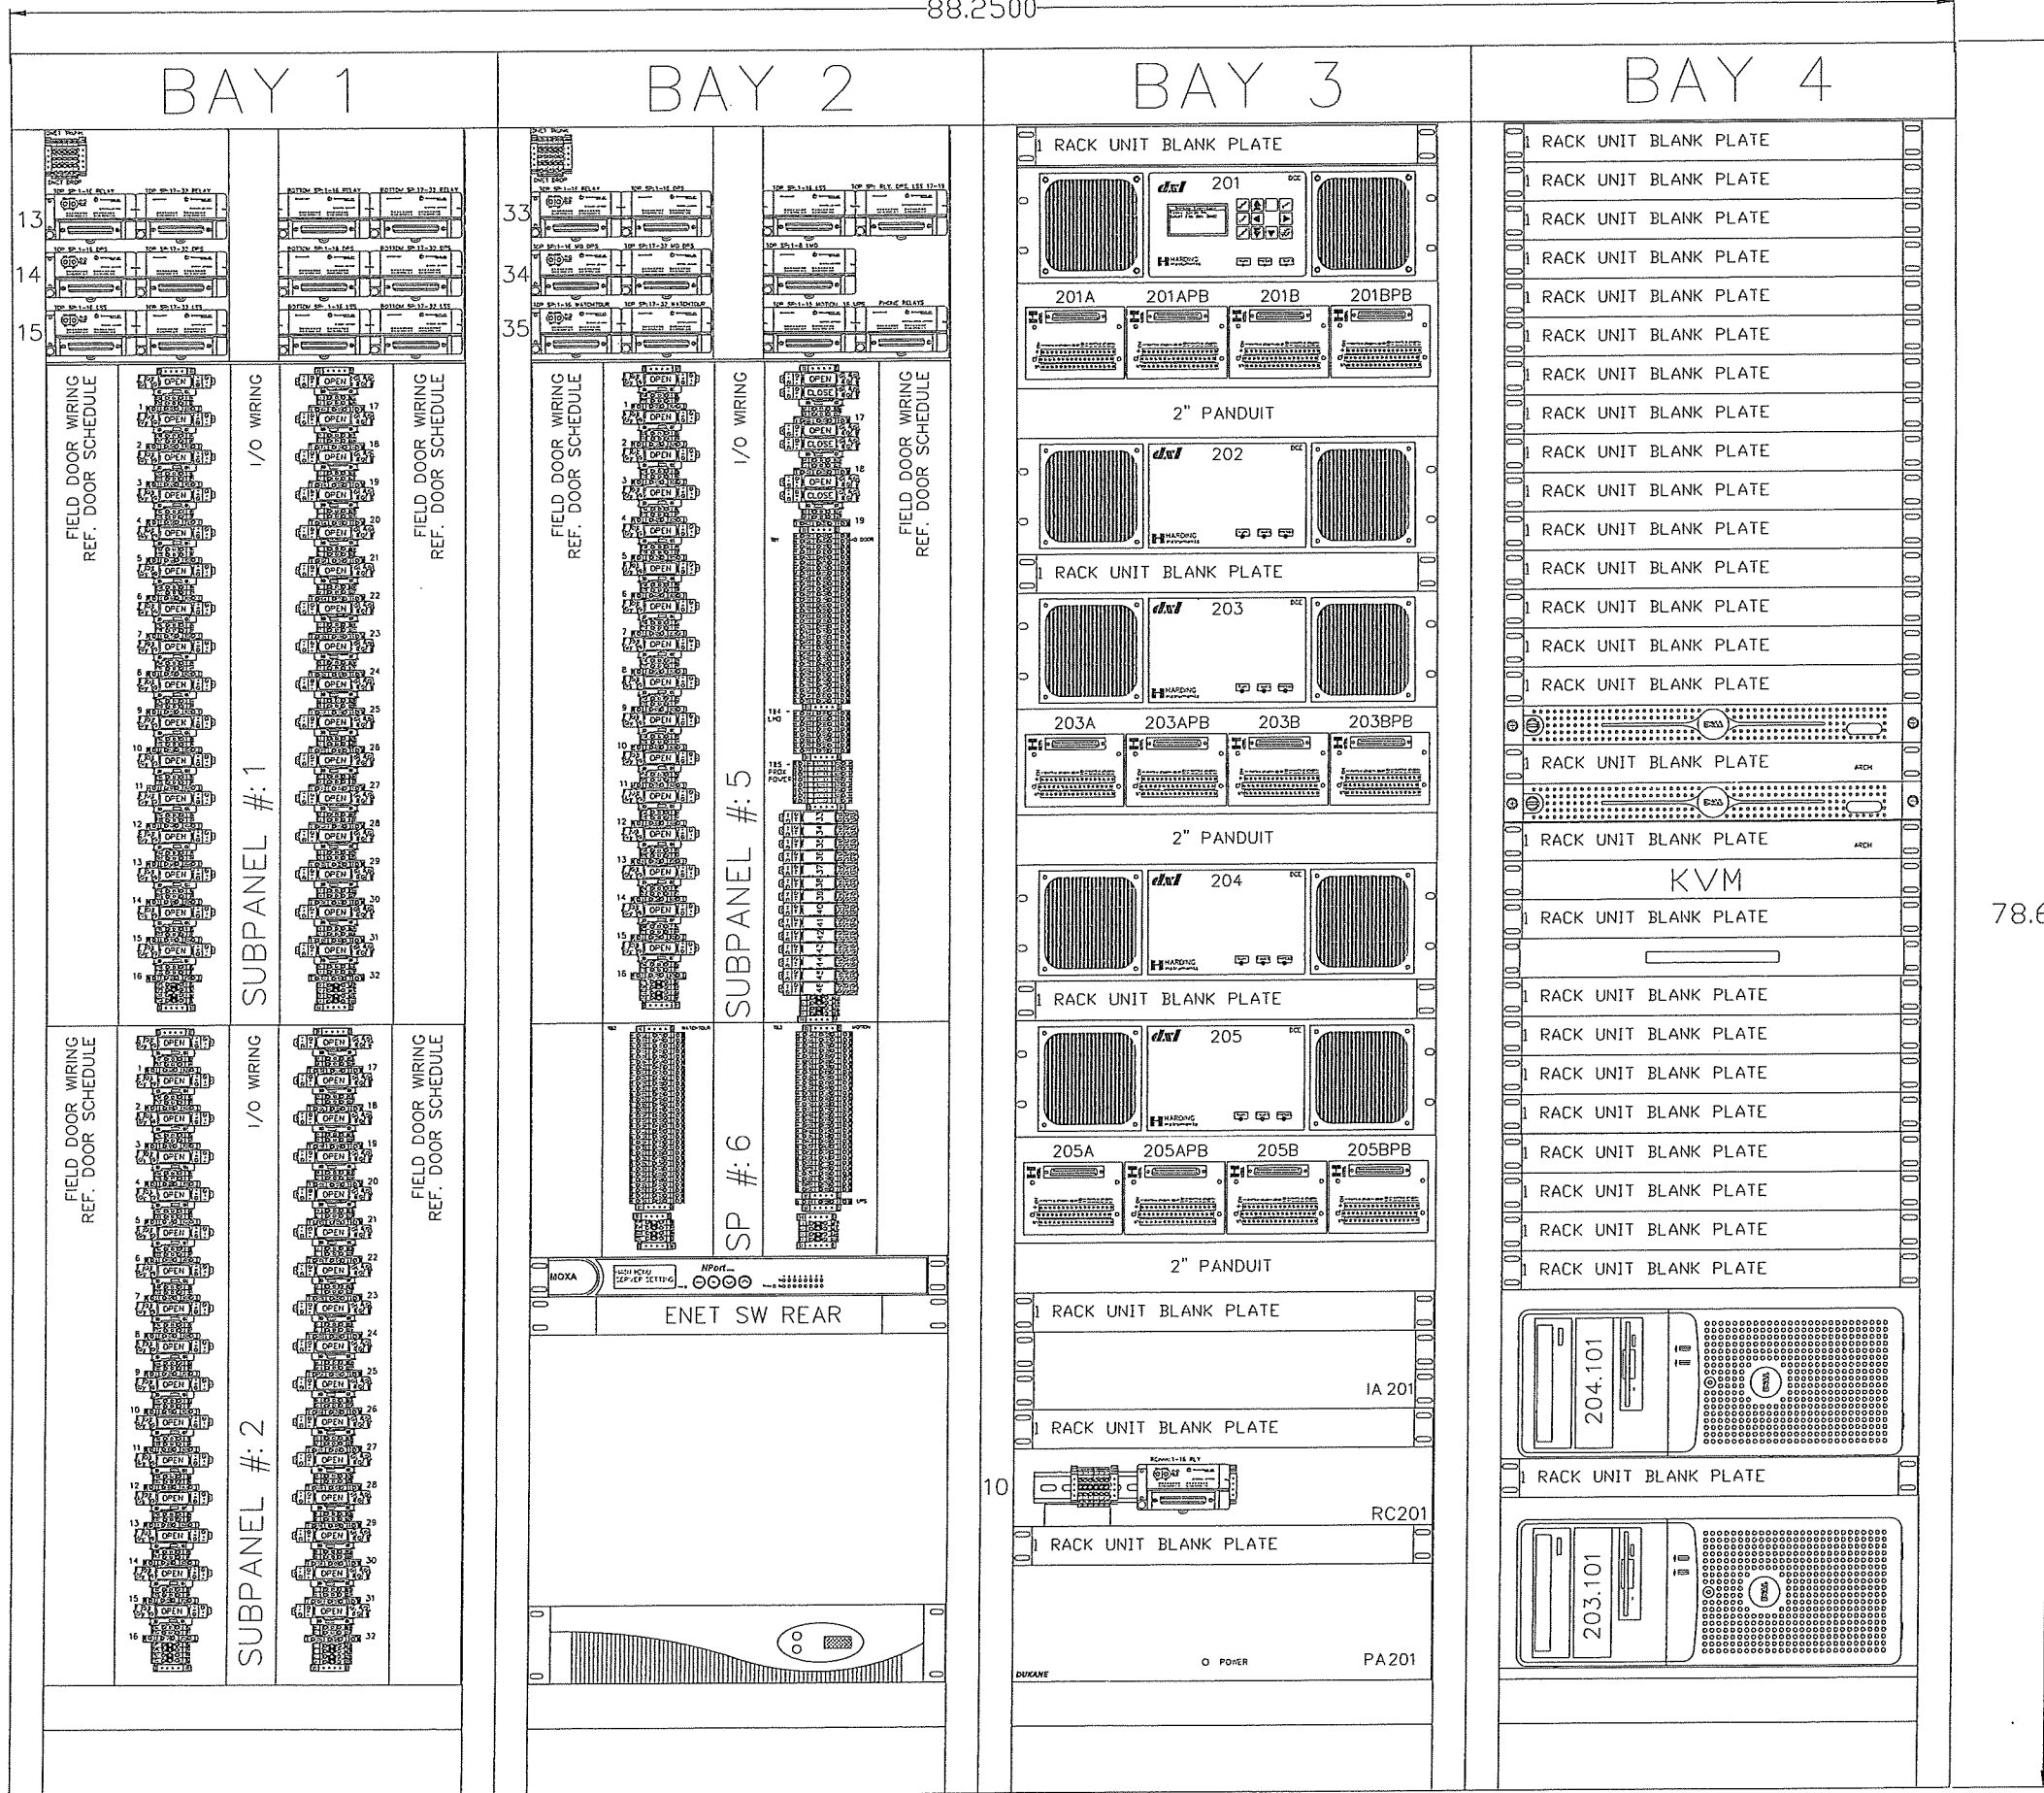

SPLIT FOR SHIPPING

SEC2 CABINET LAYOUT - FRONT


The information hereon is property of Stanley Security Solutions, Integrator.com Division and shall not be transmitted, copied, or used for purposes other than that for which it was intended.

STANLEY
integrator.com
14670 Cumberland Road
Noblesville, Indiana 46060
Phone: (317) 776-3500 Fax: (317) 776-3510
www.integrator.com

STANLEY
Security Solutions

TITLE	
JACKSON COUNTY JAIL	
JEFFERSON, GA	
CABINET LAYOUT	
JOB #:	JOB DATE:
V.1666	2/25/2008
APPROVAL:	APPROVAL DATE:
JB	
DESIGN:	BRANDEN FRY
SOFTWARE:	CHRIS MARLOW
PROJECT MANAGER:	JASON BRYAN
REVISIONS	
DESCRIPTION	BY/DATE
1	
2	
3	
4	
5	
6	
FILENAME: JCGA-102.0.DWG	
DWG NO.	

ES102.0

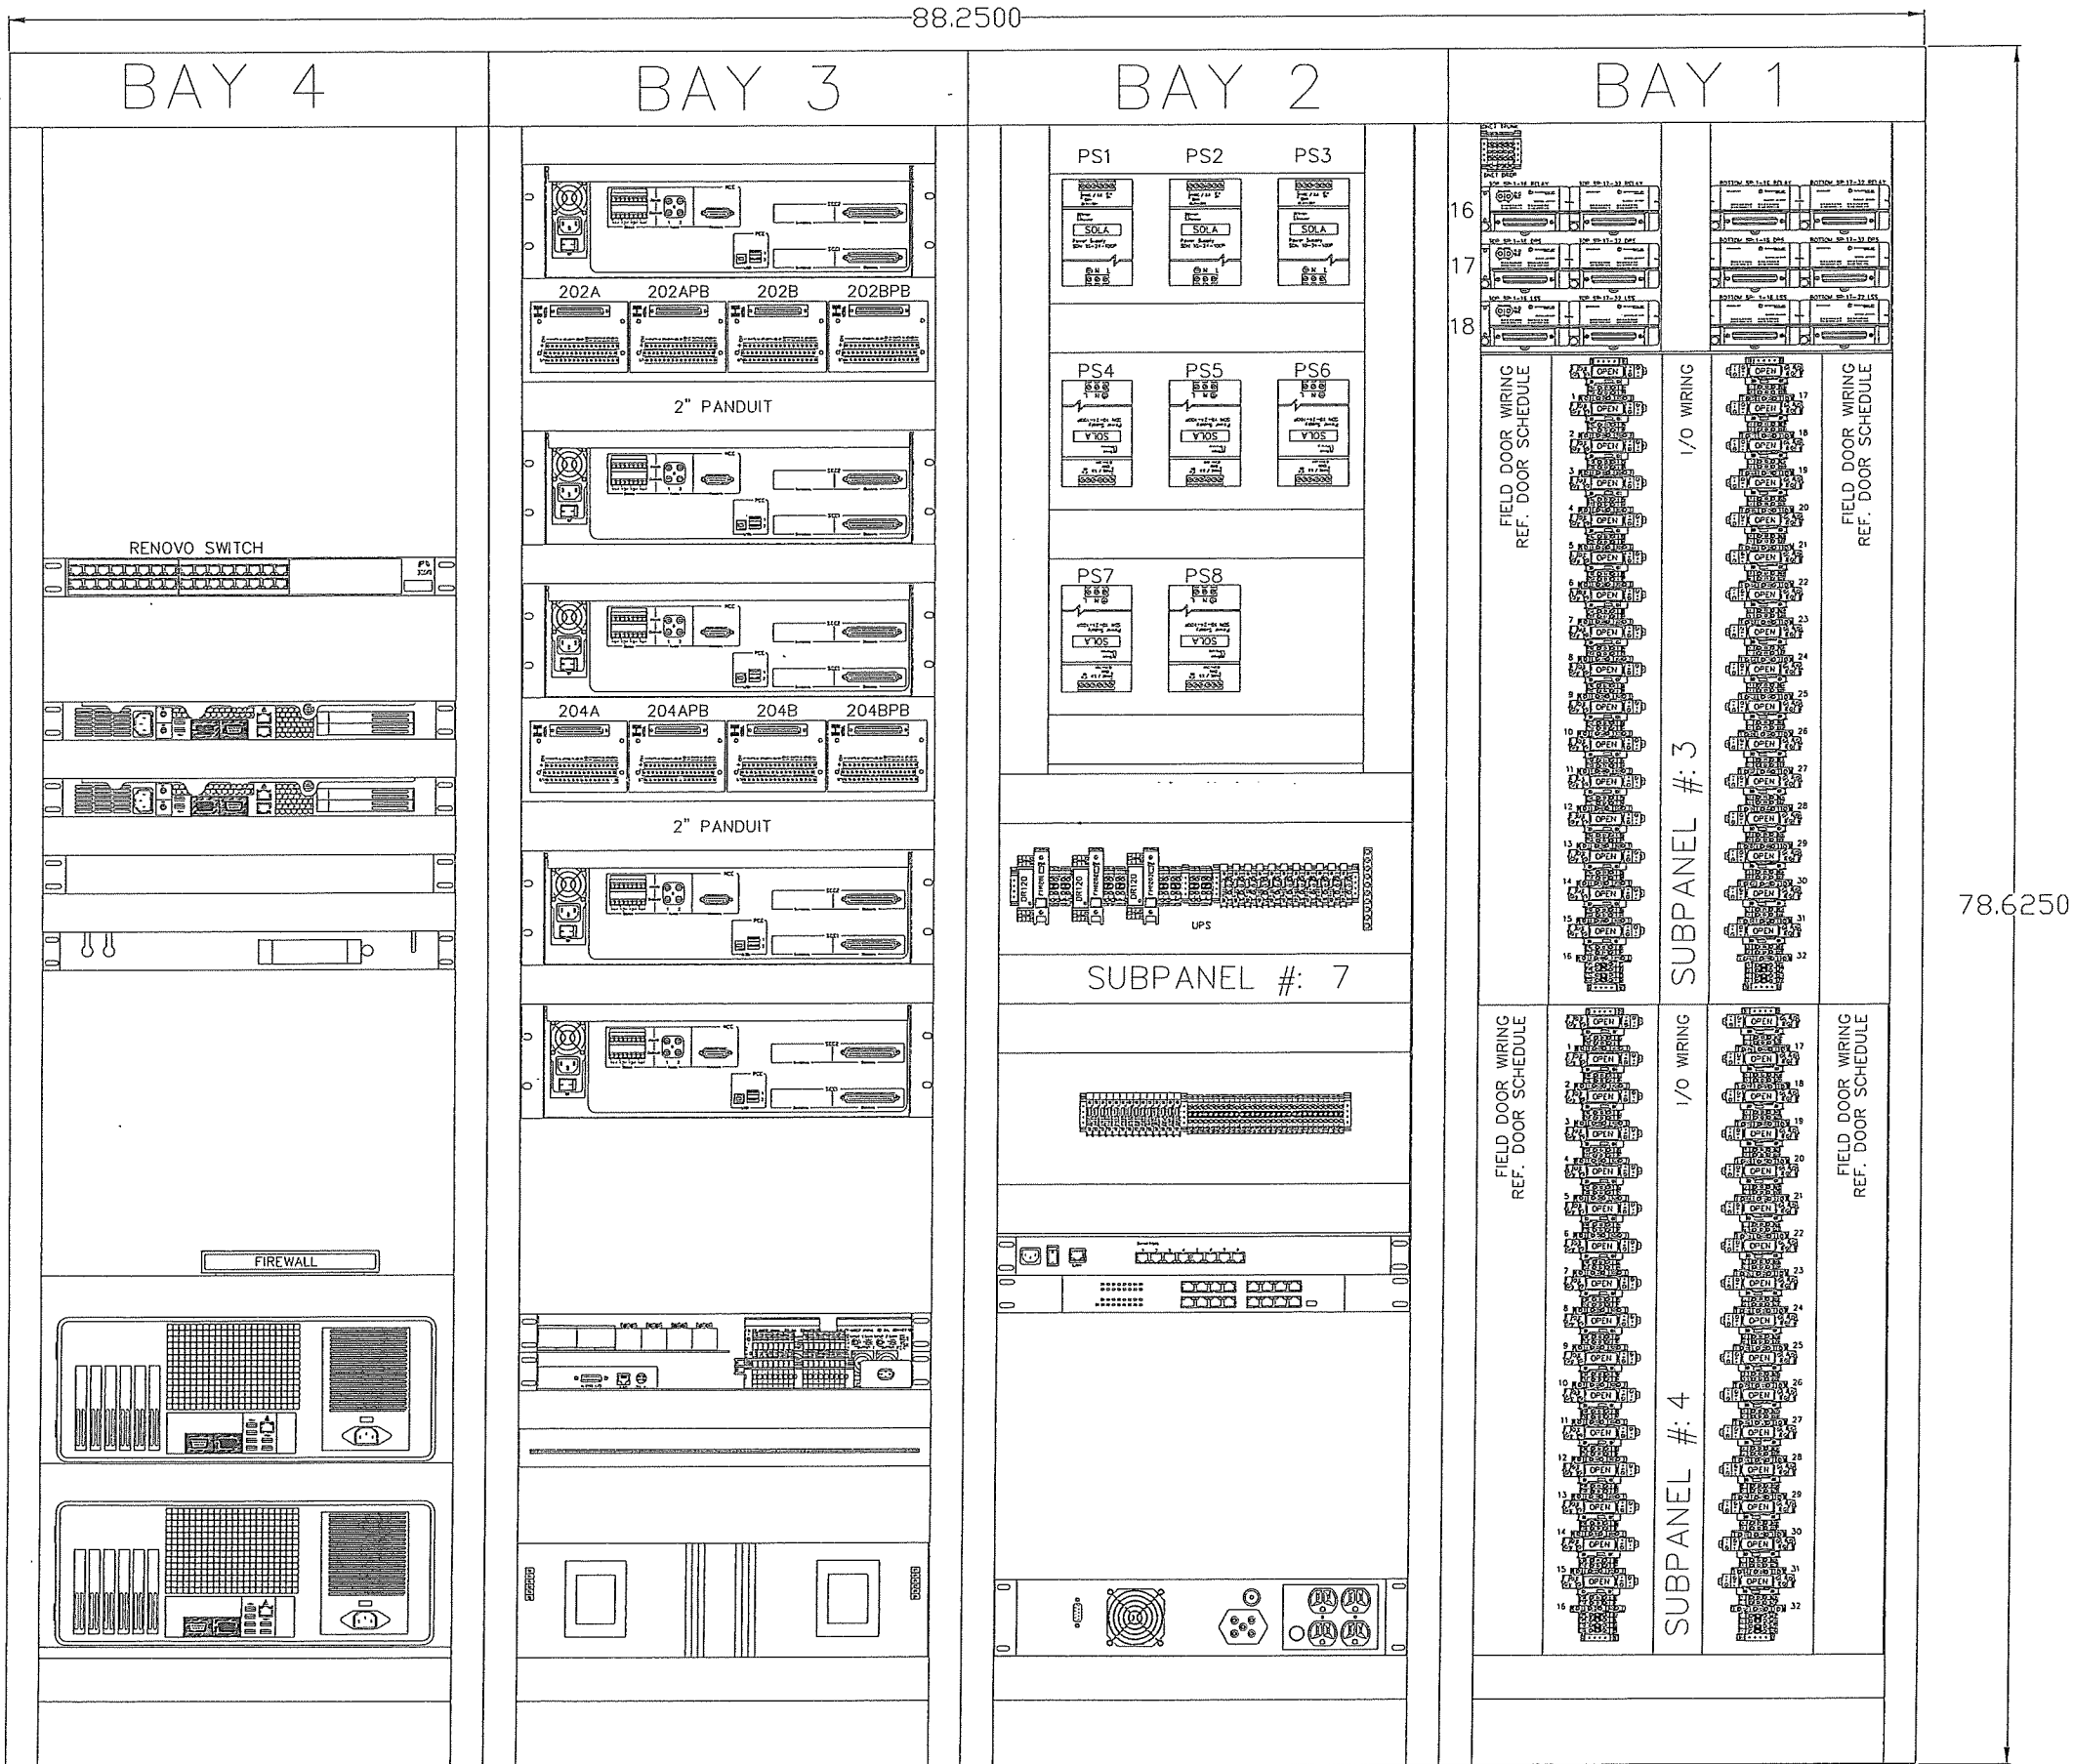

SPLIT FOR SHIPPING


The information hereon is property of Stanley Security Solutions, integrator.com Division and shall not be transmitted, copied, or used for purposes other than that for which it was intended.

STANLEY
integrator.com
14670 Cumberland Road
Noblesville, Indiana 46060
Phone: (317) 776-3500 Fax: (317) 776-3510
www.integrator.com


STANLEY
Security Solutions

TITLE	
JACKSON COUNTY JAIL	
JEFFERSON, GA	
CABINET LAYOUT	
JOB #:	JOB DATE:
V.1666	2/25/2008
APPROVAL:	APPROVAL DATE:
JB	
DESIGN: BRANDEN FRY	
SOFTWARE: CHRIS MARLOW	
PROJECT MANAGER: JASON BRYAN	
REVISIONS	
DESCRIPTION	BY/DATE
1	
2	
3	
4	
5	
6	
FILENAME: JCGA-102.1.DWG	
DWG NO.	
ES102.1	

1 - 20A 120VAC
UPS SERVICE (BY E.C.)

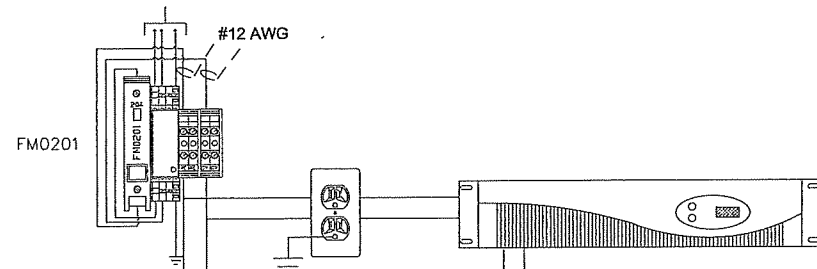

1 - 20A 120VAC
UPS SERVICE (BY E.C.)

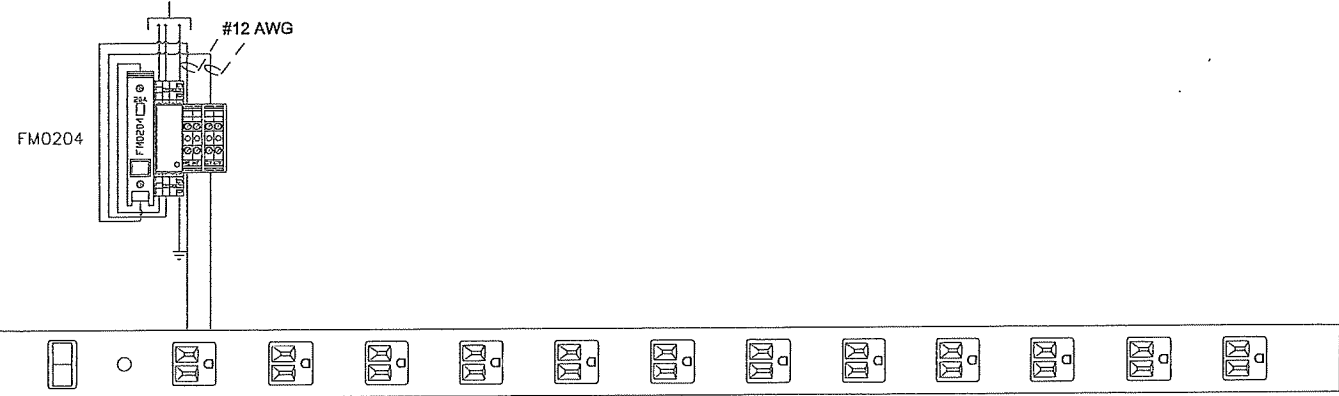

FA0201 5A

PS1

FA0202 5A

PS2



DC COMMON

FD0201 6A DOOR / MISC. I/O POWER
FD0202 2A PROX POWER
FD0203 2A SPARE
FD0204 1A SPARE

DC COMMON

FD0205 4A SPARE
FD0206 2A SPARE
FD0207 1A INFORMER AUDIO
FD0208 6A UTILITY I/O POWER

FA0203 2A SPARE
FA0204 2A SPARE

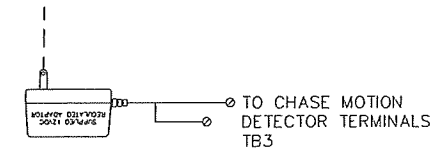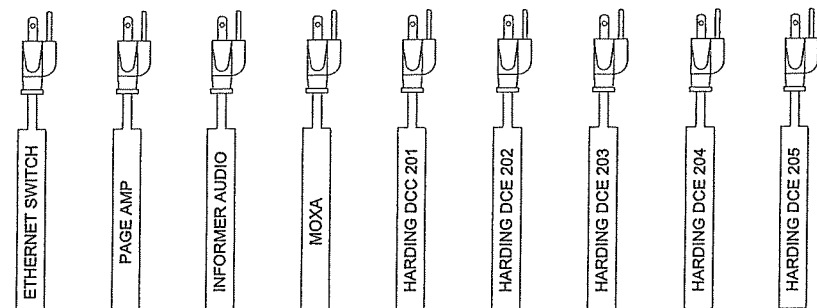

The information hereon is property of Stanley Security Solutions, integrator.com Division and shall not be transmitted, copied, or used for purposes other than that for which it was intended.

STANLEY integrator.com
14670 Cumberland Road
Noblesville, Indiana 46060
Phone: (317) 776-3500 Fax: (317) 776-3510
www.integrator.com

STANLEY Security Solutions

TITLE
JACKSON COUNTY JAIL
JEFFERSON, GA
POWER DISTRIBUTION

JOB #: V.1666 JOB DATE: 2/25/2008
APPROVAL: JB APPROVAL DATE:

DESIGN: BRANDEN FRY

SOFTWARE: CHRIS MARLOW

PROJECT MANAGER: JASON BRYAN

REVISIONS

DESCRIPTION	BY	DATE
⚠		
⚠		
⚠		
⚠		
⚠		
⚠		

FILENAME: JCGA-102.2.DWG

DWG NO.

ES102.2


SEC2 EM POWER DISTRIBUTION

The information hereon is property of Stanley Security Solutions, integrator.com Division and shall not be transmitted, copied, or used for purposes other than that for which it was intended.


STANLEY integrator.com
14670 Cumberland Road
Noblesville, Indiana 46060
Phone: (317) 776-3500 Fax: (317) 776-3510
www.integrator.com

STANLEY Security Solutions

1 - 20A 120VAC
EMERGENCY POWER (BY E.C.)

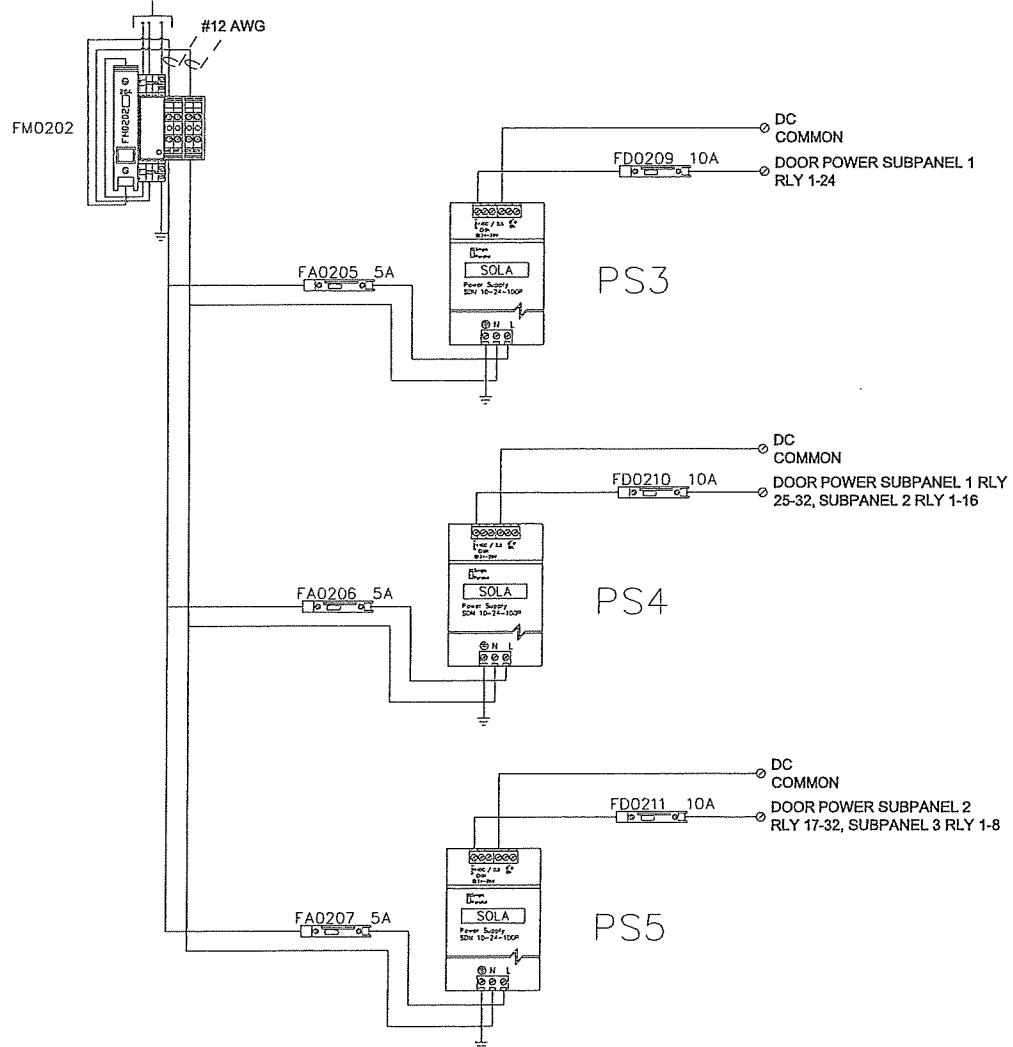

1 - 20A 120VAC
EMERGENCY POWER (BY E.C.)

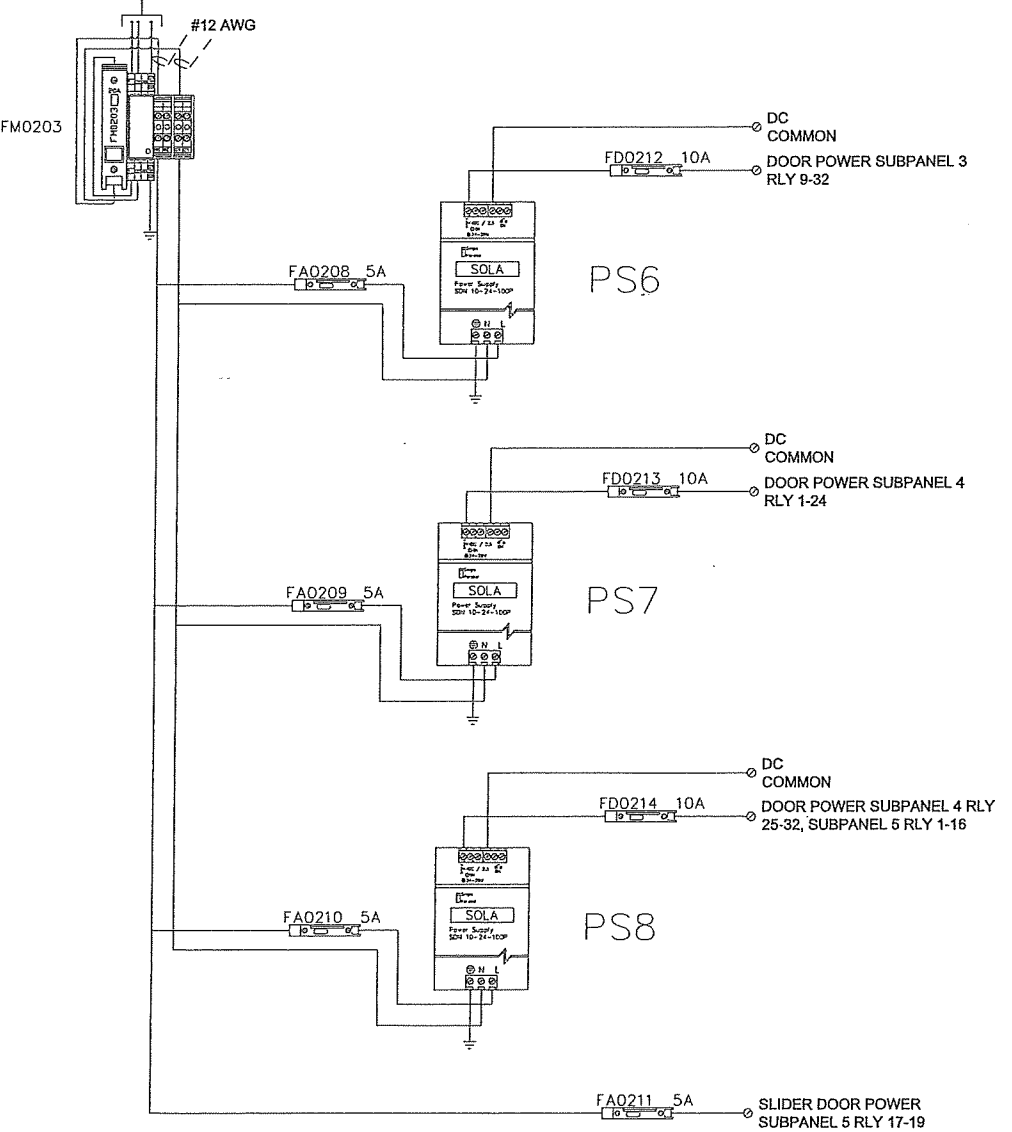

SEC2 EM POWER DISTRIBUTION

TITLE

JACKSON COUNTY JAIL

JEFFERSON, GA

POWER DISTRIBUTION

JOB #: V.1666 JOB DATE: 2/25/2008

APPROVAL: JB APPROVAL DATE:

DESIGN: BRANDEN FRY

SOFTWARE: CHRIS MARLOW

PROJECT MANAGER: JASON BRYAN


REVISIONS

DESCRIPTION	BY	DATE
1		
2		
3		
4		
5		
6		

FILENAME: JCGA-102.3.DWG

DWG NO.

ES102.3

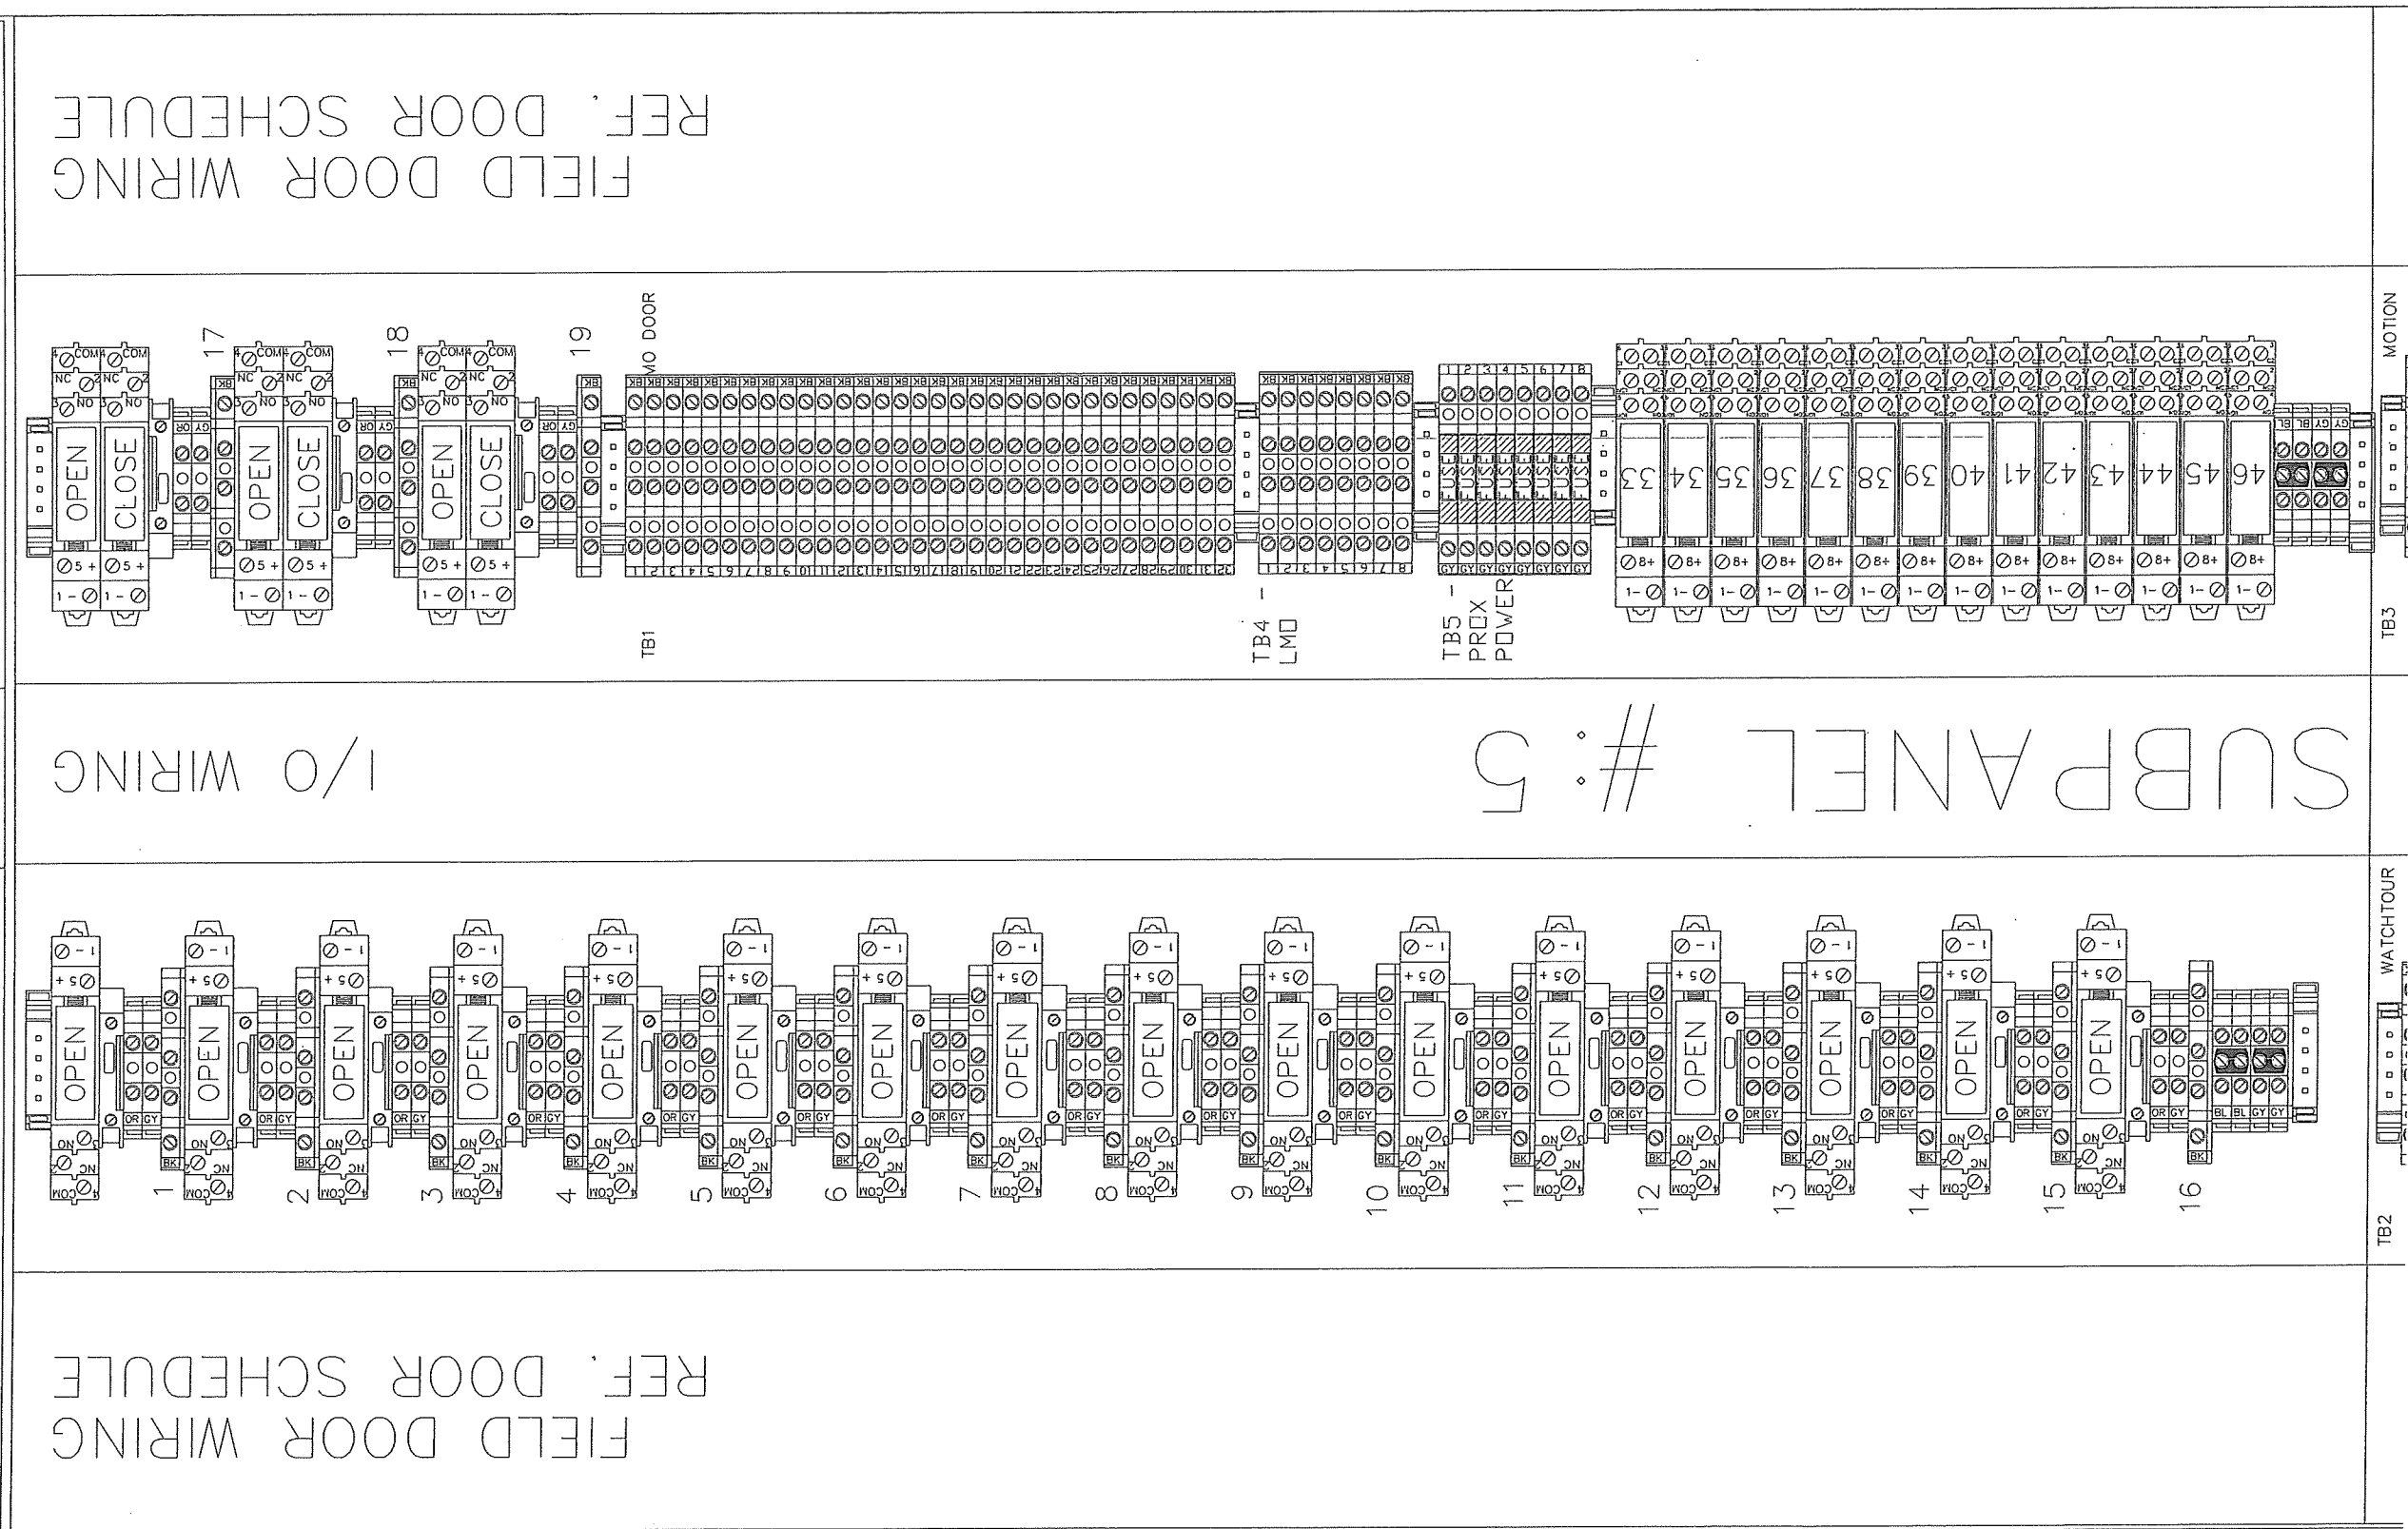

FIELD DOOR WIRING
REF. DOOR SCHEDULE

SUBPANEL #5

FIELD DOOR WIRING
REF. DOOR SCHEDULE

SEC2 TERMINAL BLOCK DETAIL


The information hereon is property of Stanley Security Solutions, integrator.com Division and shall not be transmitted, copied, or used for purposes other than that for which it was intended.

STANLEY integrator.com

14570 Cumberland Road
Noblesville, Indiana 46060
Phone: (317) 776-3500 Fax: (317) 776-3510
www.integrator.com

STANLEY Security Solutions

TITLE	
JACKSON COUNTY JAIL	
JEFFERSON, GA	
TERMINAL DETAIL	
JOB #:	JOB DATE:
V.1666	2/25/2008
APPROVAL:	APPROVAL DATE:
JB	
DESIGN:	
BRANDEN FRY	
SOFTWARE:	
CHRIS MARLOW	
PROJECT MANAGER:	
JASON BRYAN	
REVISIONS	
DESCRIPTION	BY/DATE
1	
2	
3	
4	
5	
6	
FILENAME: JCGA-102.4.DWG	
DWG NO.	
ES102.4	

 

SECRET

The information hereon is property of Stanley Security Solutions, integrator.com Division and shall not be transmitted, copied, or used for purposes other than that for which it was intended.

STANLEY
integrator.com
14670 Cumberland Road
Noblesville, Indiana 46060
Phone: (317) 776-3500 Fax: (317) 776-3510

STANLEY®
Security Solutions

TITLE	JACKSON COUNTY JAIL
-------	---------------------

JEFFERSON, GA

TERMINAL DETAIL

JOB #:	JOB DATE:
V.1666	2/25/2008
APPROVAL:	APPROVAL DATE:
JIB	

DESIGN: BRANDEN FRY

SOFTWARE: CHRIS MARLOW

PROJECT MANAGER:
JASON DEYAN


REVISIONS

	DESCRIPTION	DATE
1		
2		
3		
4		
5		
6		


FILENAME: JCGA-102.5.DWG

DWG NO.

ES102.5

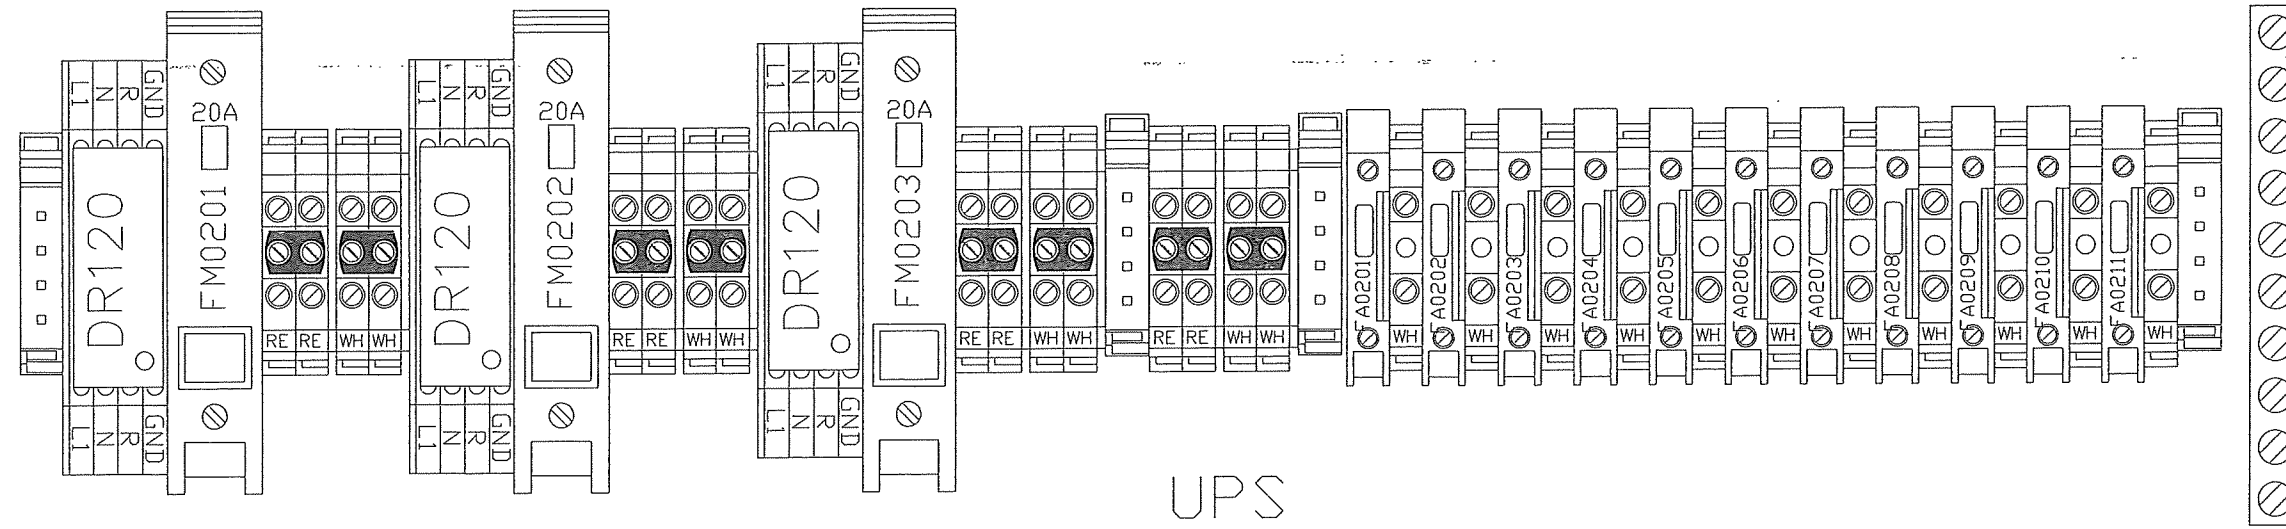

SUBPANEL # 7

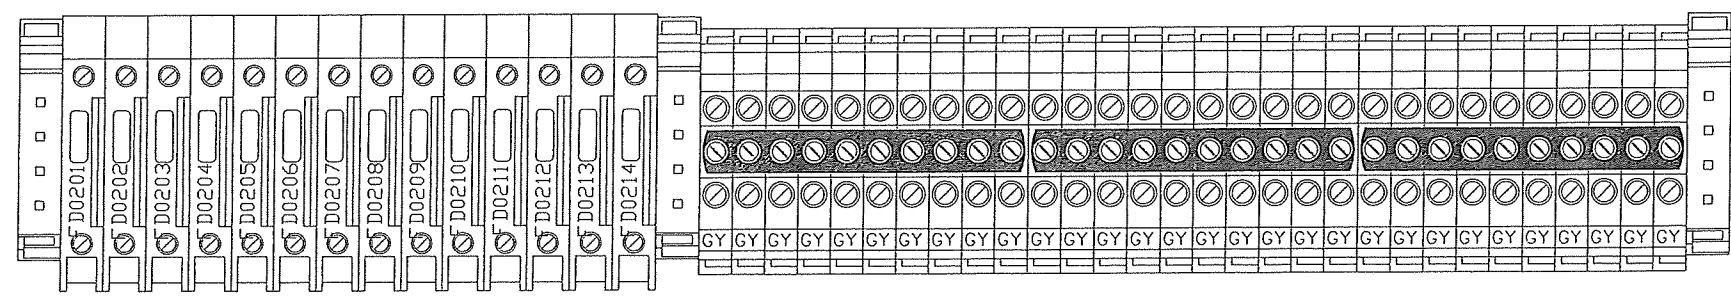

SEC2 TERMINAL BLOCK DETAIL

The information hereon is property of Stanley Security Solutions, integrator.com Division and shall not be transmitted, copied, or used for purposes other than that for which it was intended.

STANLEY


integrator.com

14670 Cumberland Road
Noblesville, Indiana 46060
Phone: (317) 776-3500 Fax: (317) 776-3510
www.integrator.com

STANLEY®

Security Solutions

TITLE	
JACKSON COUNTY JAIL	
JEFFERSON, GA	
TERMINAL DETAIL	
JOB #:	JOB DATE:
V.1666	2/25/2008
APPROVAL:	APPROVAL DATE:
JB	
DESIGN:	
BRANDEN FRY	
SOFTWARE:	
CHRIS MARLOW	
PROJECT MANAGER:	
JASON BRYAN	
REVISIONS	
DESCRIPTION	BY/DATE
1	
2	
3	
4	
5	
6	
FILENAME: JCGA-102.6.DWG	
DWG NO.	
ES102.6	

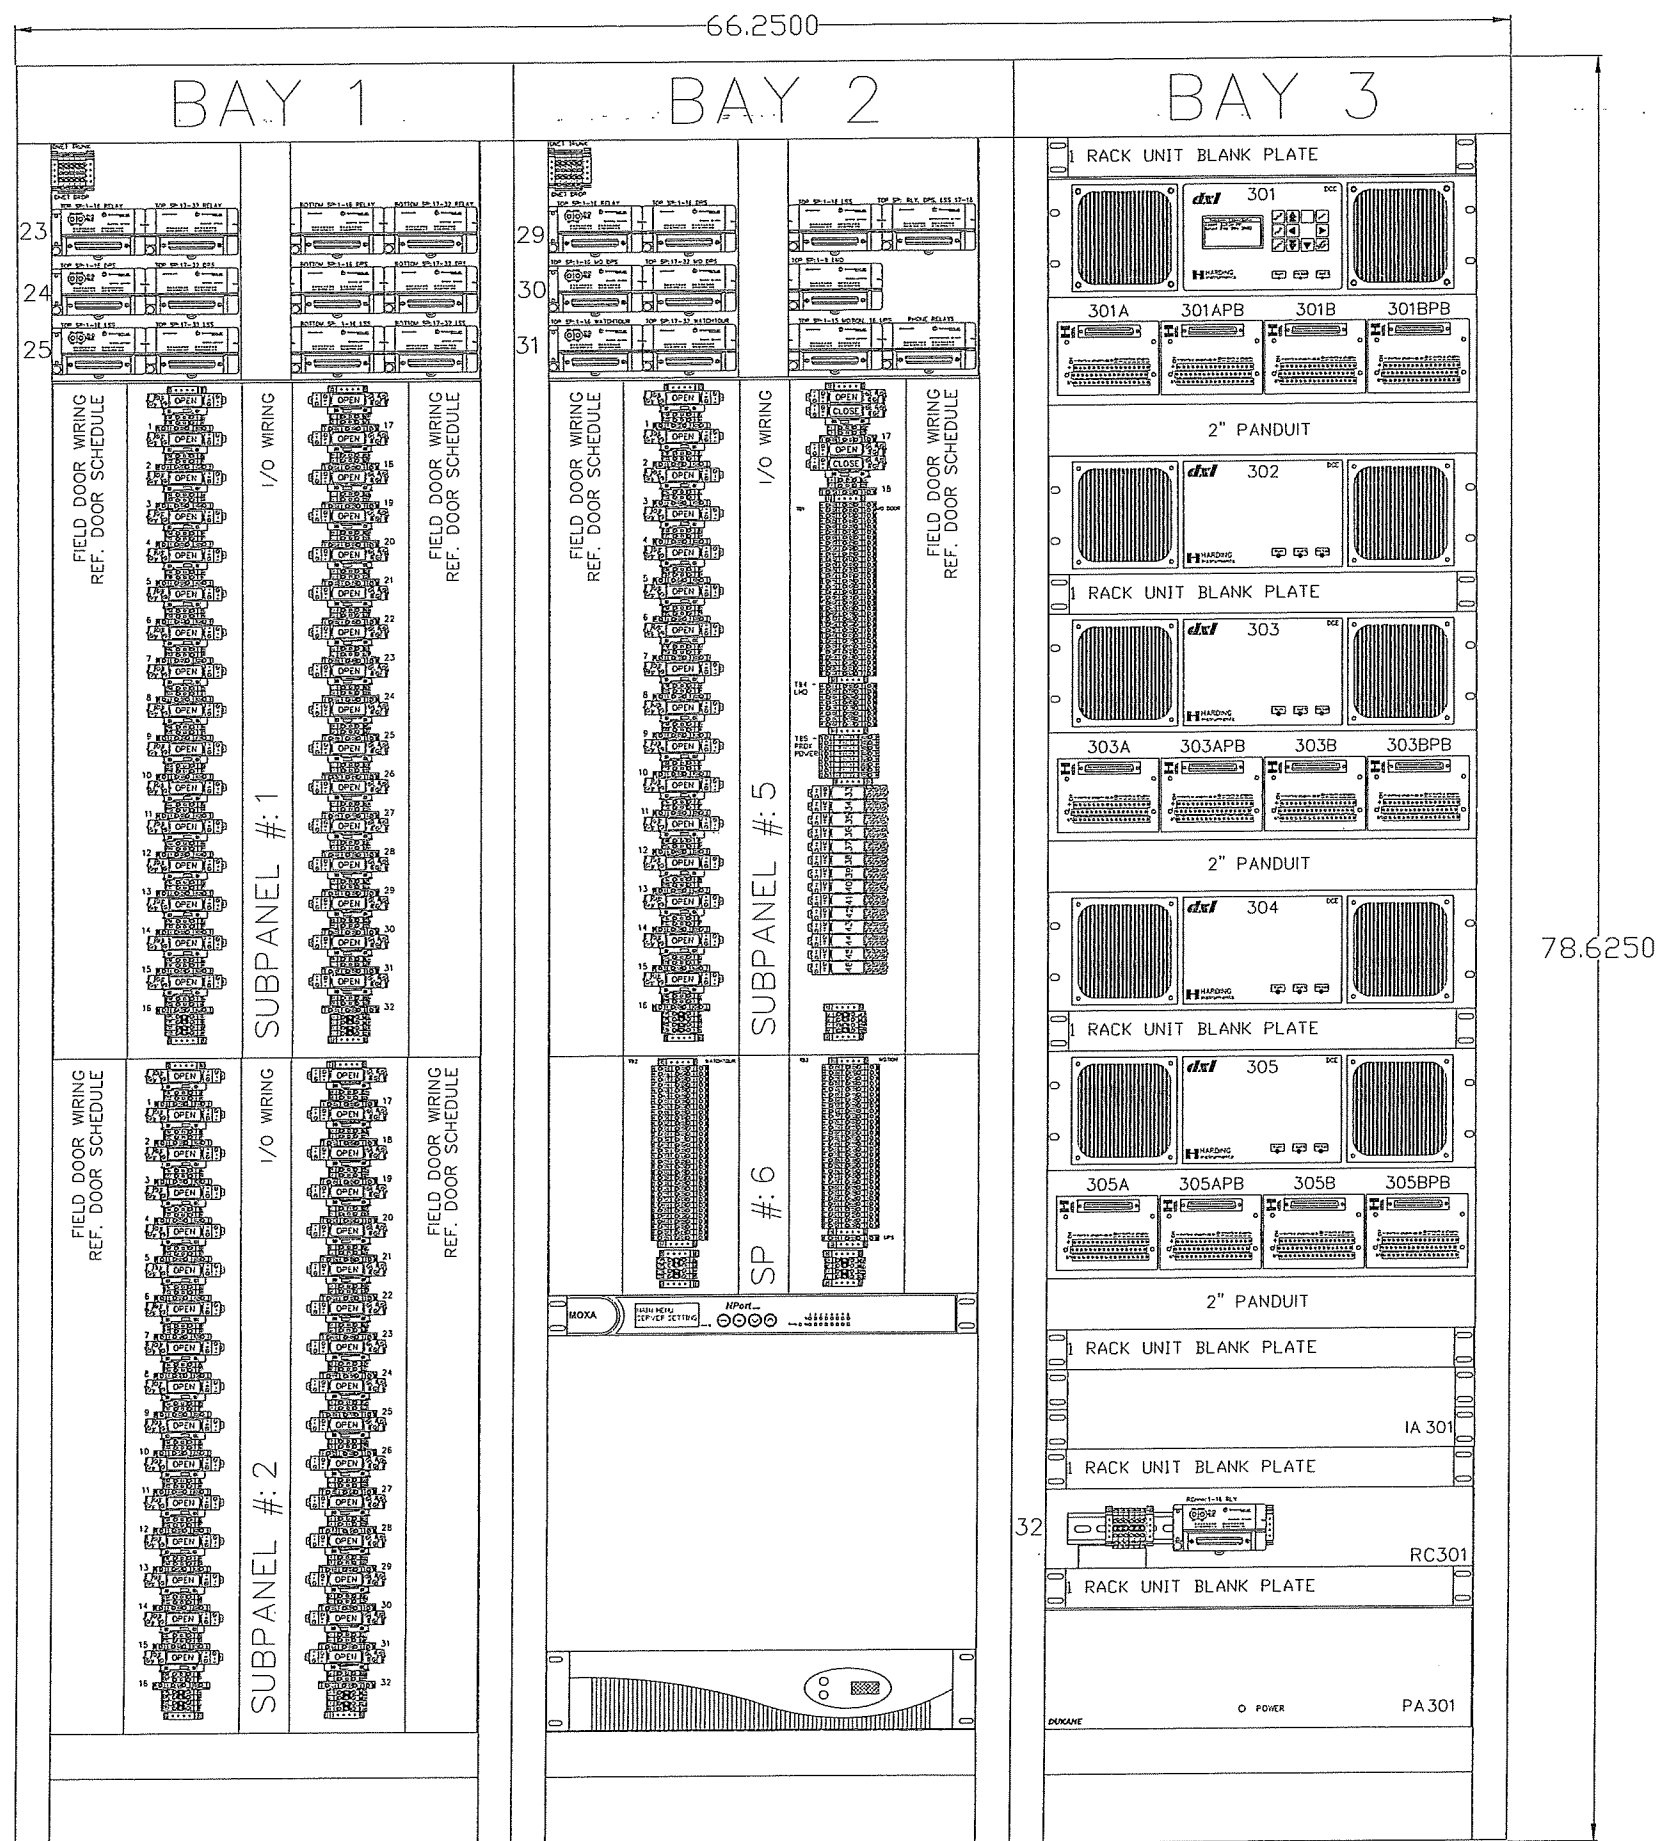

The information hereon is property of Stanley Security Solutions, integrator.com Division and shall not be transmitted, copied, or used for purposes other than that for which it was intended.


STANLEY
Integrator.com
14670 Cumberland Road
Noblesville, Indiana 46060
Phone: (317) 776-3500 Fax: (317) 776-3510
www.integrator.com

STANLEY®
Security Solutions

JACKSON COUNTY JAIL	
JEFFERSON, GA	
CABINET LAYOUT	
JOB #:	JOB DATE:
V.1666	2/25/2008
APPROVAL:	APPROVAL DATE:
JB	
DESIGN:	
BRANDEN FRY	
SOFTWARE:	
CHRIS MARLOW	
PROJECT MANAGER:	
JASON BRYAN	
REVISIONS	
DESCRIPTION	BY/ DATE
①	
②	
③	
④	
⑤	
⑥	
FILENAME: JCGA-103.0.DWG	
DWG NO.	

ES103.0

66.2500

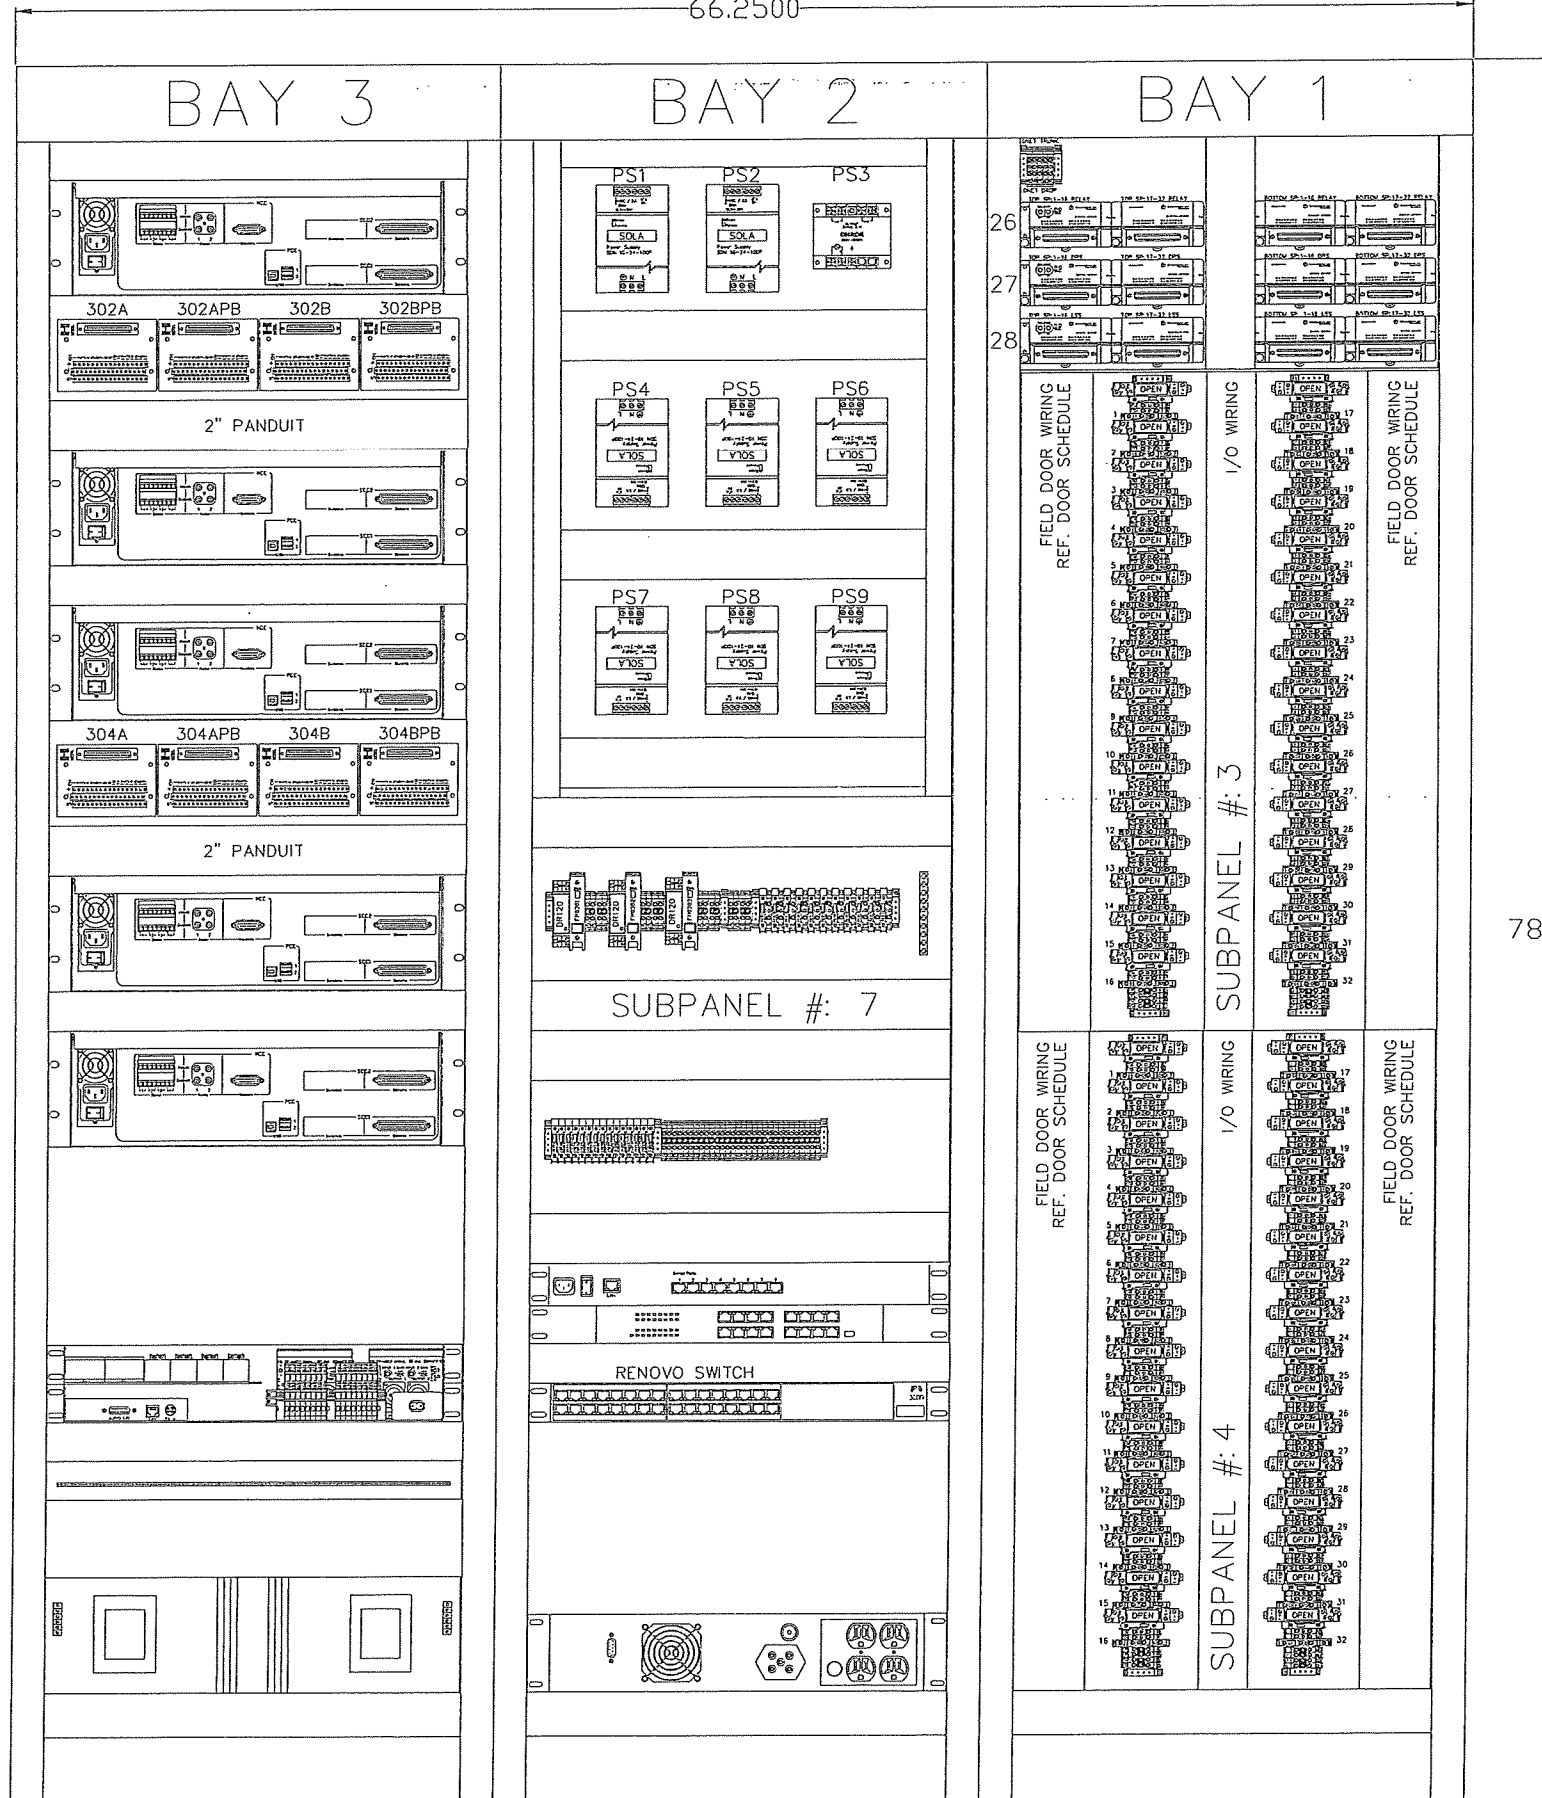


The information hereon is property of Stanley Security Solutions, Integrator.com Division and shall not be transmitted, copied, or used for purposes other than that for which it was intended.

STANLEY **integrator.com**
14670 Cumberland Road
Noblesville, Indiana 46060
Phone: (317) 776-3500 Fax: (317) 776-3510
www.integrator.com

STANLEY®
Security Solutions

TITLE	
JACKSON COUNTY JAIL	
JEFFERSON, GA	
CABINET LAYOUT	
JOB #:	JOB DATE:
V.1666	2/25/2008
APPROVAL:	APPROVAL DATE:
JB	
DESIGN: BRANDEN FRY	
SOFTWARE: CHRIS MARLOW	
PROJECT MANAGER: JASON BRYAN	
REVISIONS	
DESCRIPTION	BY/DATE
⚠	
⚠	
⚠	
⚠	
⚠	
⚠	
FILENAME: JCGA-103.1.DWG	
DWG NO.	
ES103.1	

1 - 20A 120VAC
UPS SERVICE (BY E.C.)

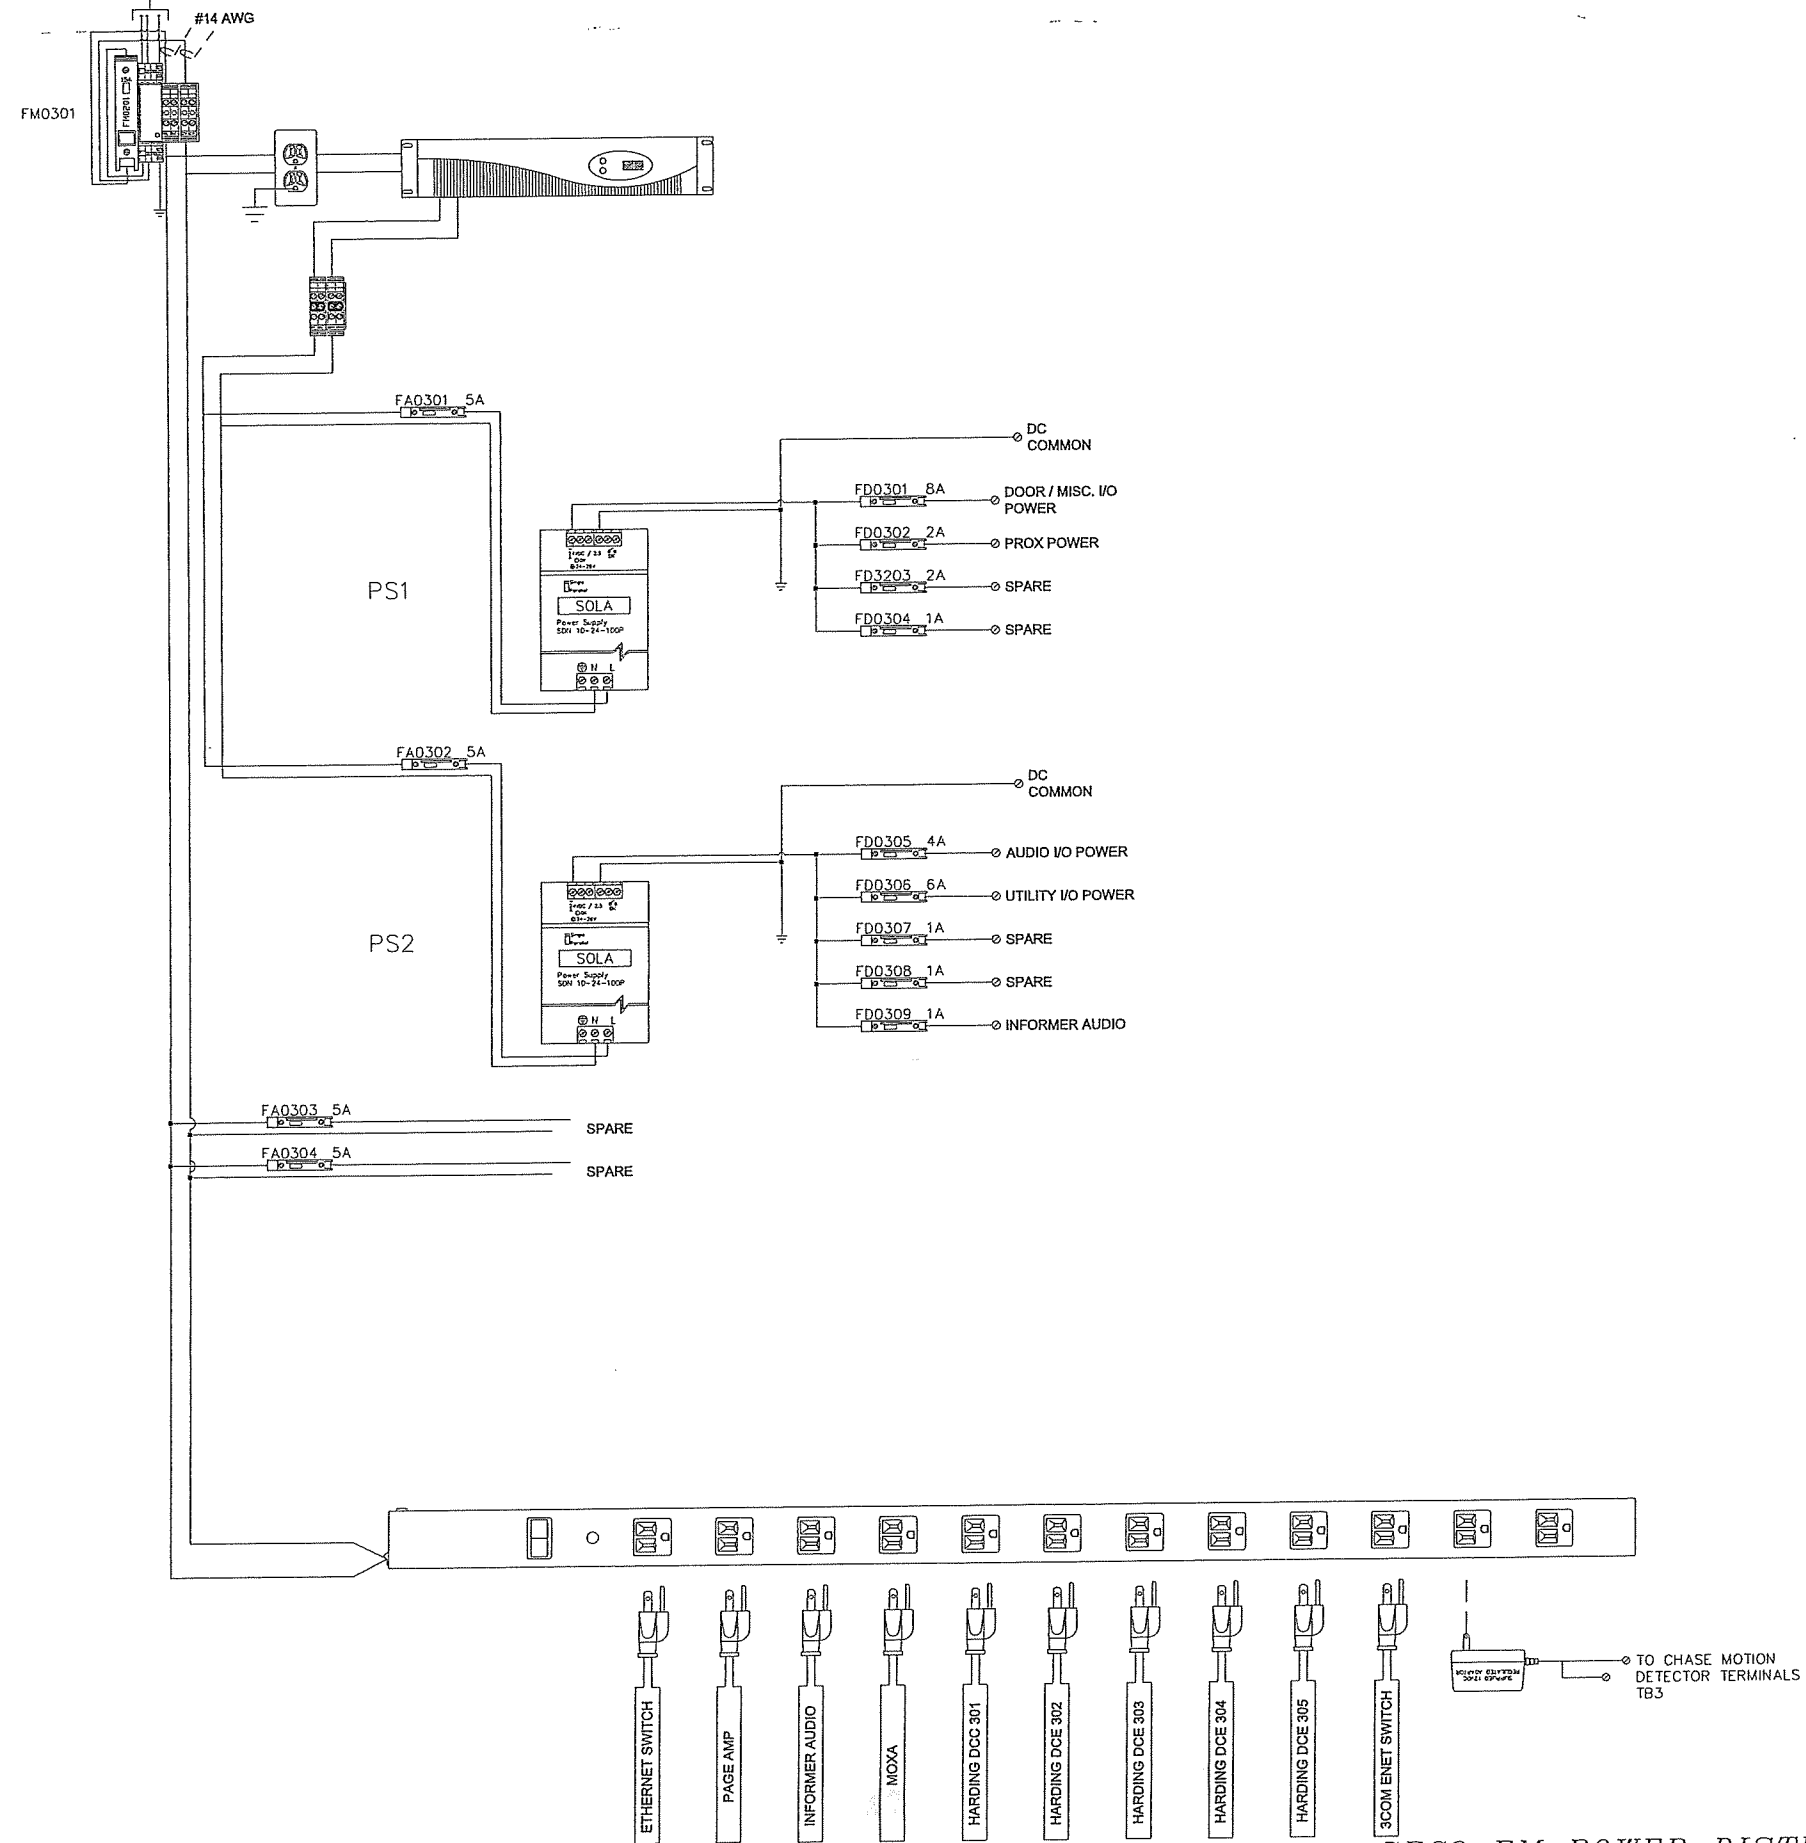

The information hereon is property of Stanley Security Solutions, integrator.com Division and shall not be transmitted, copied, or used for purposes other than that for which it was intended.

STANLEY **integrator.com**
14670 Cumberland Road
Noblesville, Indiana 46060
Phone: (317) 776-3500 Fax: (317) 776-3510
www.integrator.com

STANLEY®
Security Solutions

TITLE
JACKSON COUNTY JAIL

JEFFERSON, GA

POWER DISTRIBUTION

JOB #:	JOB DATE:
V.1666	2/25/2008
APPROVAL:	APPROVAL DATE:
JB	

DESIGN: **BRANDEN FRY**

SOFTWARE: **CHRIS MARLOW**

PROJECT MANAGER: **JASON BRYAN**

REVISIONS

DESCRIPTION	BY/DATE
1	
2	
3	
4	
5	
6	

FILENAME: JCGA-103.2.DWG

DWG NO.

ES103.2

SEC3 EM POWER DISTRIBUTION

The information hereon is property of Stanley Security Solutions, Integrator.com Division and shall not be transmitted, copied, or used for purposes other than that for which it was intended.

STANLEY integrator.com
14670 Cumberland Road
Noblesville, Indiana 46060
Phone: (317) 776-3510
www.integrator.com

STANLEY®
Security Solutions

TITLE
JACKSON COUNTY JAIL

JEFFERSON, GA

POWER DISTRIBUTION

JOB #: V.1666 JOB DATE: 2/25/2008
APPROVAL: JB APPROVAL DATE:

DESIGN: BRANDEN FRY

SOFTWARE: CHRIS MARLOW

PROJECT MANAGER: JASON BRYAN

REVISIONS


DESCRIPTION	BY/DATE
1	
2	
3	
4	
5	
6	

FILENAME: JCGA-103.3.DWG


DWG NO.

ES103.3

1 - 20A 120VAC
EMERGENCY (BY E.C.)

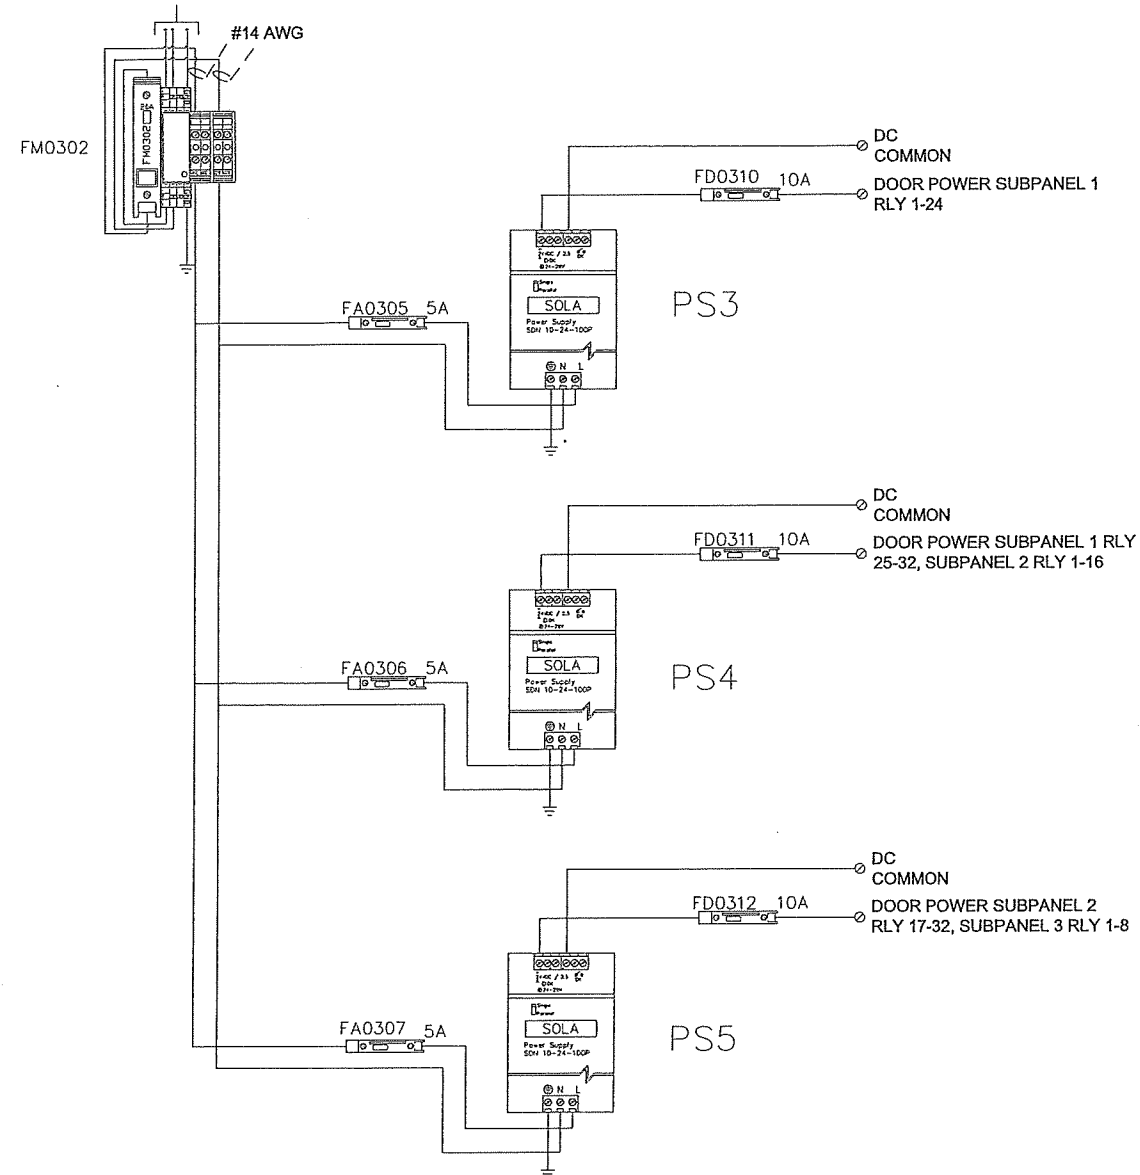

1 - 20A 120VAC
EMERGENCY (BY E.C.)

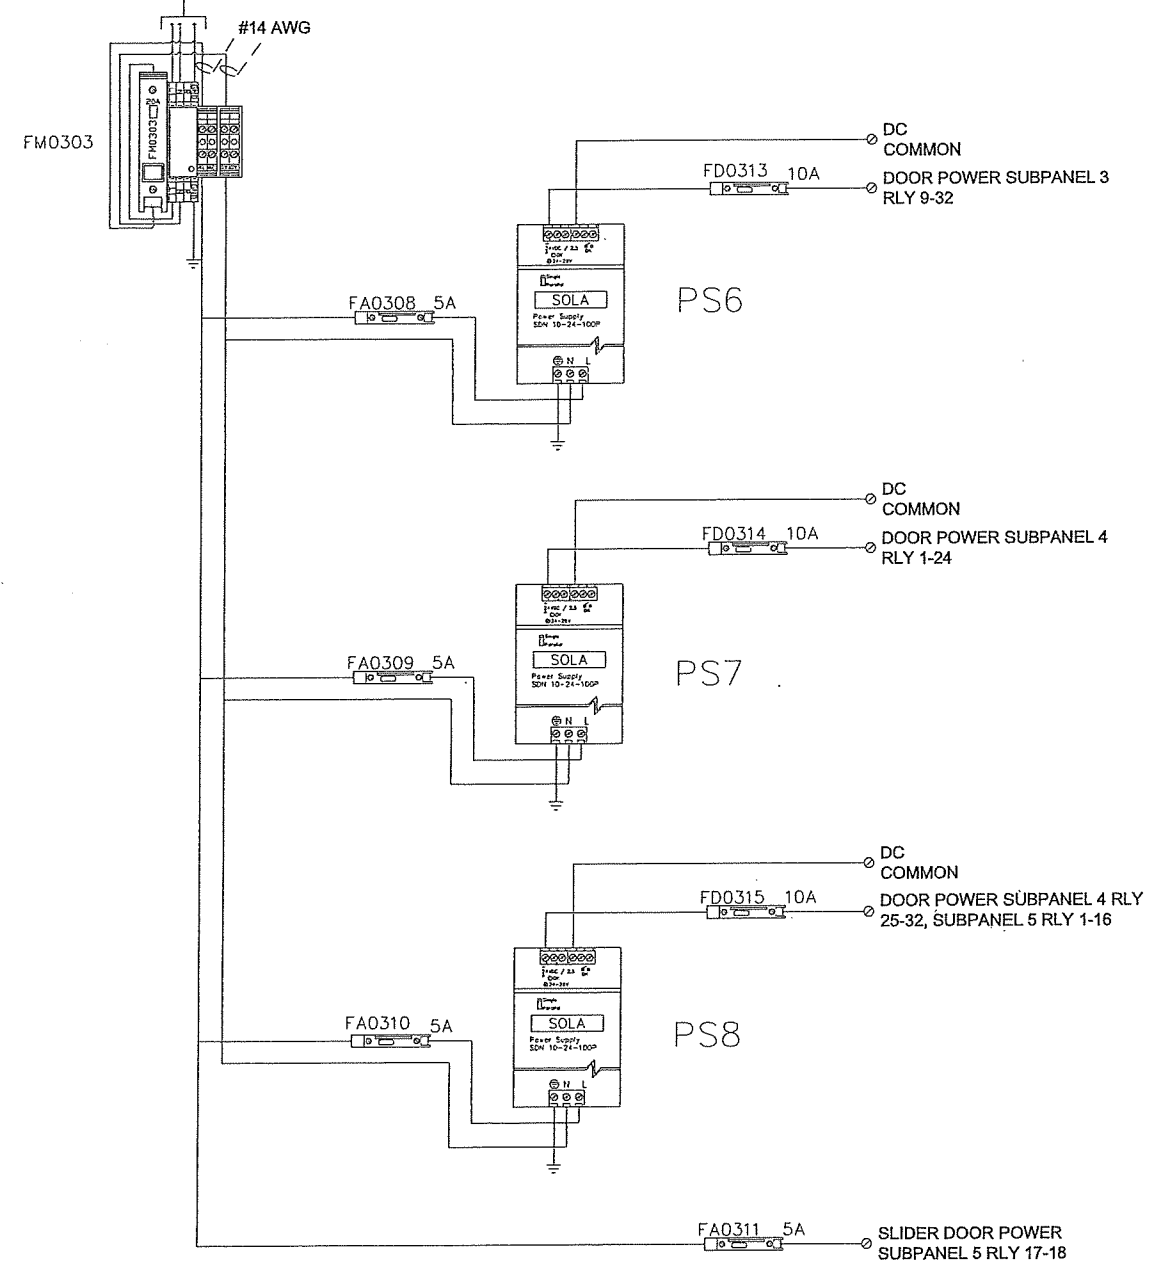

SEC3 EM POWER DISTRIBUTION

The information hereon is property of Stanley Security Solutions, integrator.com Division and shall not be transmitted, copied, or used for purposes other than that for which it was intended.

STANLEY
integrator.com
14670 Cumberland Road
Noblesville, Indiana 46060
Phone: (317) 776-3520
www.integrator.com

STANLEY
Security Solutions

TITLE
JACKSON COUNTY JAIL

JEFFERSON, GA
TERMINAL DETAIL

JOB #: V.1666
JOB DATE: 2/25/2008
APPROVAL: JB
APPROVAL DATE:

DESIGN: BRANDEN FRY

SOFTWARE: CHRIS MARLOW

PROJECT MANAGER: JASON BRYAN

REVISIONS


DESCRIPTION	BY/DATE
1	
2	
3	
4	
5	
6	

FILENAME: JCGA-103.4.DWG


DWG NO.

ES103.4

FIELD DOOR WIRING
REF. DOOR SCHEDULE

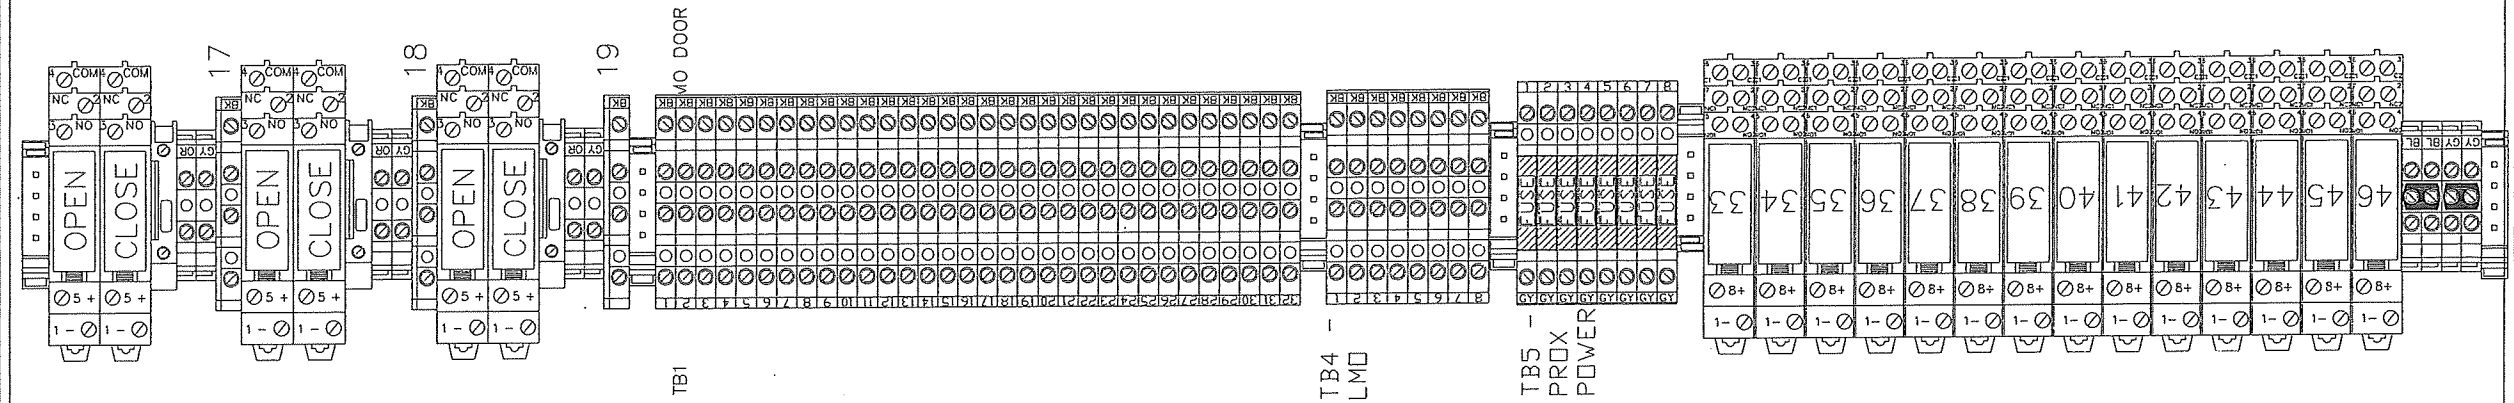

SUBPANEL #5
I/O WIRING

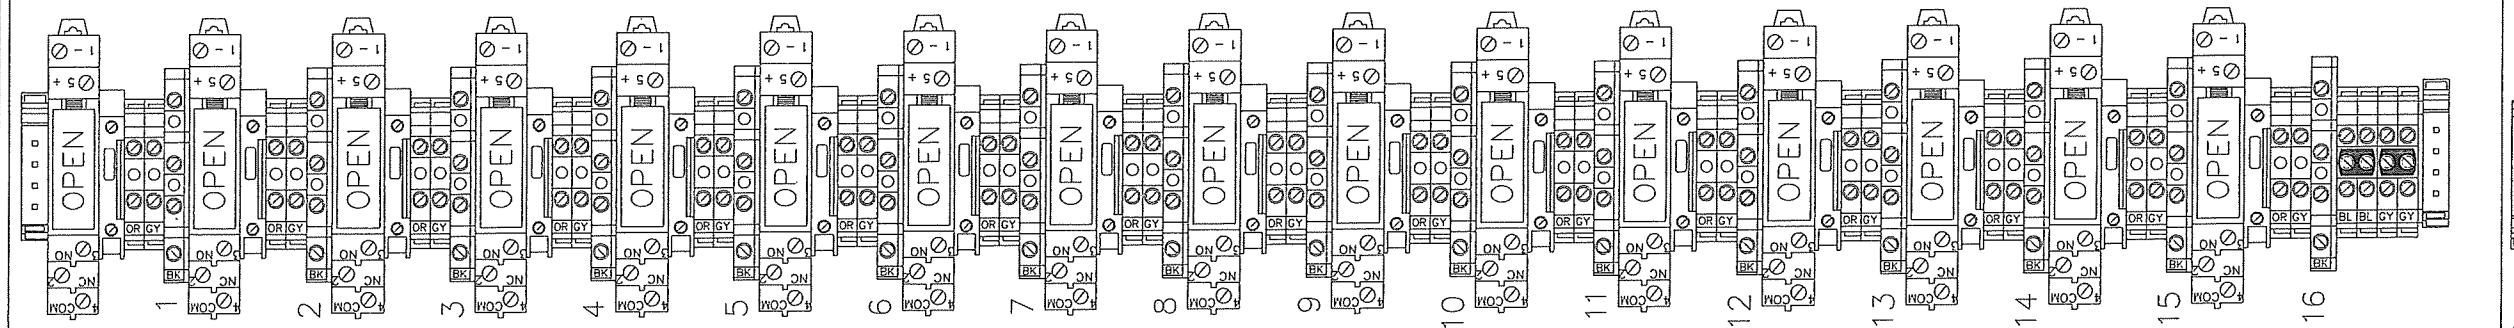


FIELD DOOR WIRING
REF. DOOR SCHEDULE





MOTION

TB3


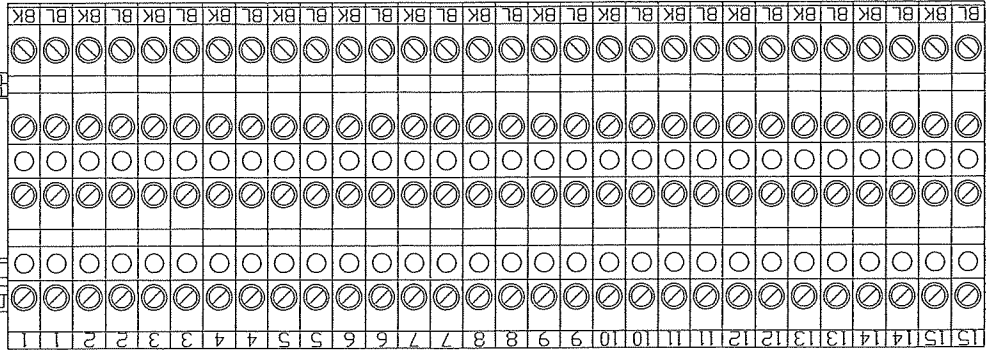


UPS

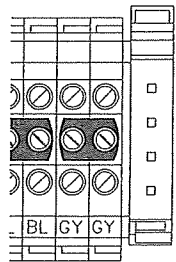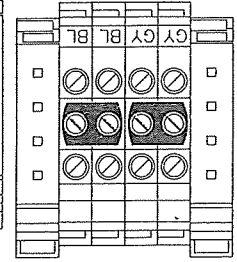

WATCHTOUR


TB2

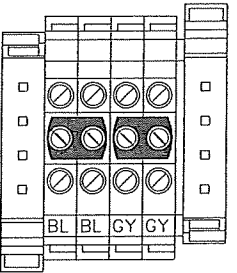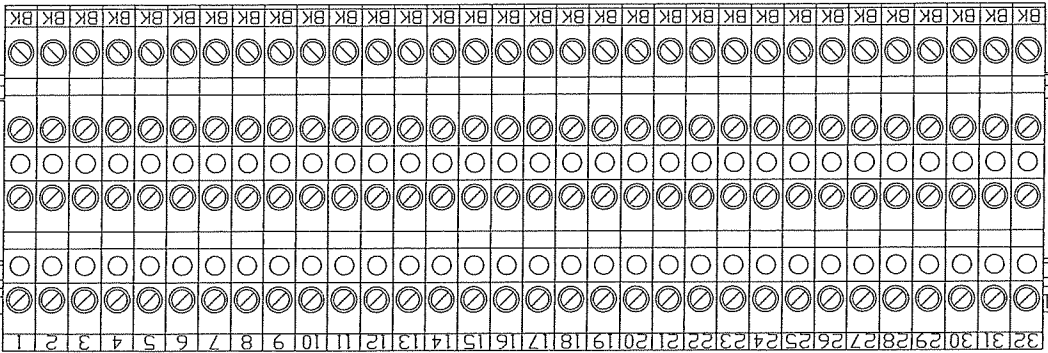

NPort 5610-8

MAIN MENU
SERVER SETTING

 1 2 3 4 5 6 7 8
Tx 0 0 0 0 0 0 0 0
Ready 0 Rx 0 0 0 0 0 0 0 0



Reset 0

ENET SW REAR

A

SEC3 TERMINAL BLOCK DETAIL

The information hereon is property of Stanley Security Solutions, integrator.com Division and shall not be transmitted, copied, or used for purposes other than that for which it was intended.

STANLEY
integrator.com
14670 Cumberland Road
Noblesville, Indiana 46060
Phone: (317) 776-3500 Fax: (317) 776-3510
www.integrator.com

STANLEY
Security Solutions

TITLE
JACKSON COUNTY JAIL

JEFFERSON, GA
TERMINAL DETAIL

JOB #: V.1666
JOB DATE: 2/25/2008
APPROVAL: JB
APPROVAL DATE:

DESIGN: BRANDEN FRY
SOFTWARE: CHRIS MARLOW
PROJECT MANAGER: JASON BRYAN

REVISIONS		BY/DATE
DESCRIPTION		
1		
2		
3		
4		
5		
6		

FILENAME: JCGA-103.5.DWG

DWG NO.




ES103.5

The information hereon is property of Stanley Security Solutions, integrator.com Division and shall not be transmitted, copied, or used for purposes other than that for which it was intended.

STANLEY
integrator.com
14670 Cumberland Road
Noblesville, Indiana 46060
Phone: (317) 776-5600 Fax: (317) 776-3510
www.integrator.com

STANLEY
Security Solutions

TITLE	
JACKSON COUNTY JAIL	
JEFFERSON, GA	
TERMINAL DETAIL	
JOB #: V.1666	JOB DATE: 2/25/2008
APPROVAL: JB	APPROVAL DATE:
DESIGN: BRANDEN FRY	
SOFTWARE: CHRIS MARLOW	
PROJECT MANAGER: JASON BRYAN	
REVISIONS	
DESCRIPTION	BY/DATE
1	
2	
3	
4	
5	
6	
7	
8	
9	
FILENAME: JCGA-103.6.DWG	
DWG NO.	
ES103.6	

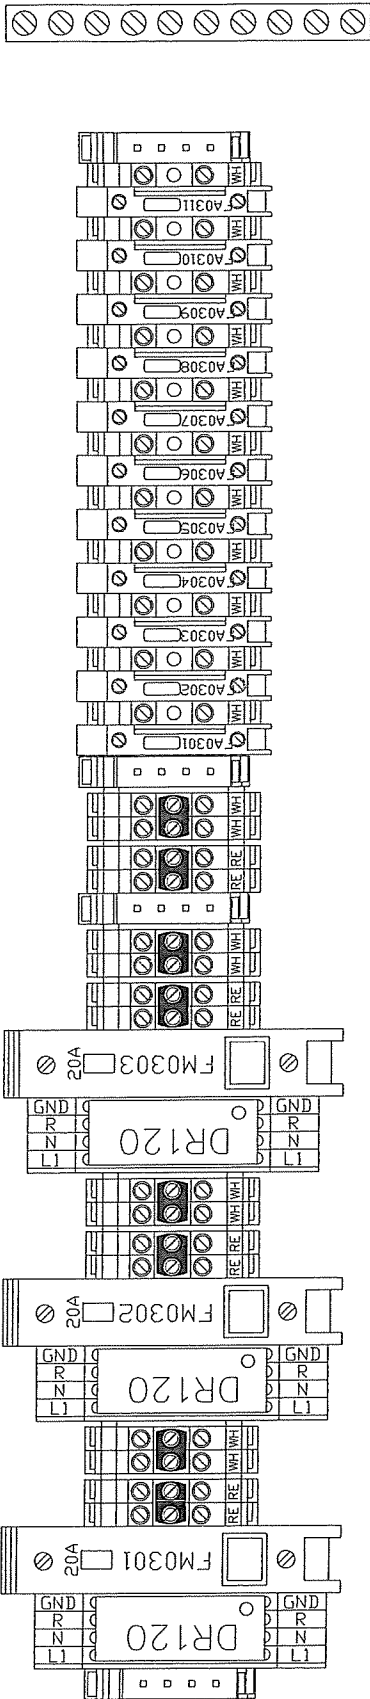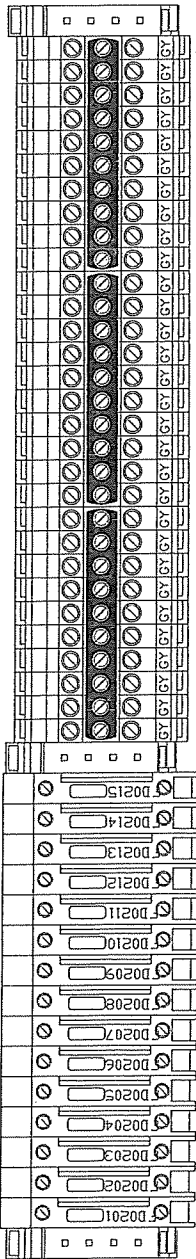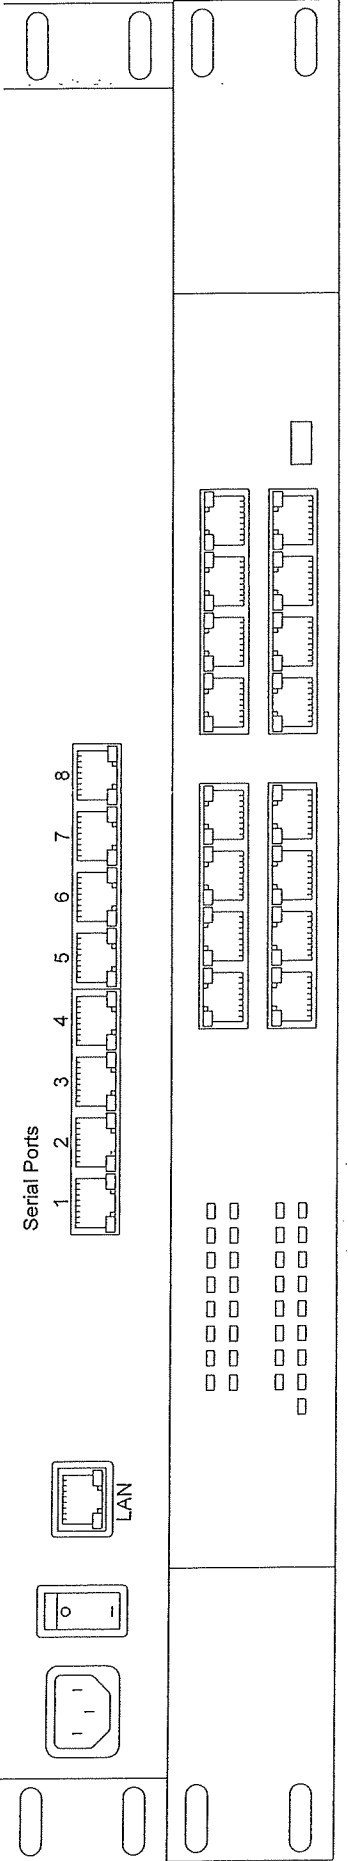

SUBPANEL #: 7

SEC3 TERMINAL BLOCK DETAIL

The information hereon is property of Stanley Security Solutions, Integrator.com Division and shall not be transmitted, copied, or used for purposes other than that for which it was intended.

STANLEY
integrator.com
14670 Cumberland Road
Noblesville, Indiana 46060
Phone: (317) 776-3500 Fax: (317) 776-3510
www.integrator.com

STANLEY
Security Solutions

TITLE
JACKSON COUNTY JAIL
JEFFERSON, GA
UCP-1 PANEL LAYOUT

JOB # V.1666 JOB DATE 2/25/2008
APPROVAL: JB APPROVAL DATE

DESIGN: BRANDEN FRY

SOFTWARE: CHRIS MARLOW

PROJECT MANAGER: JASON BRYAN


REVISIONS

DESCRIPTION	BY/DATE
△	
△	
△	
△	
△	
△	



FILENAME: JCGA-151.0.DWG

DWG NO.

ES151.0

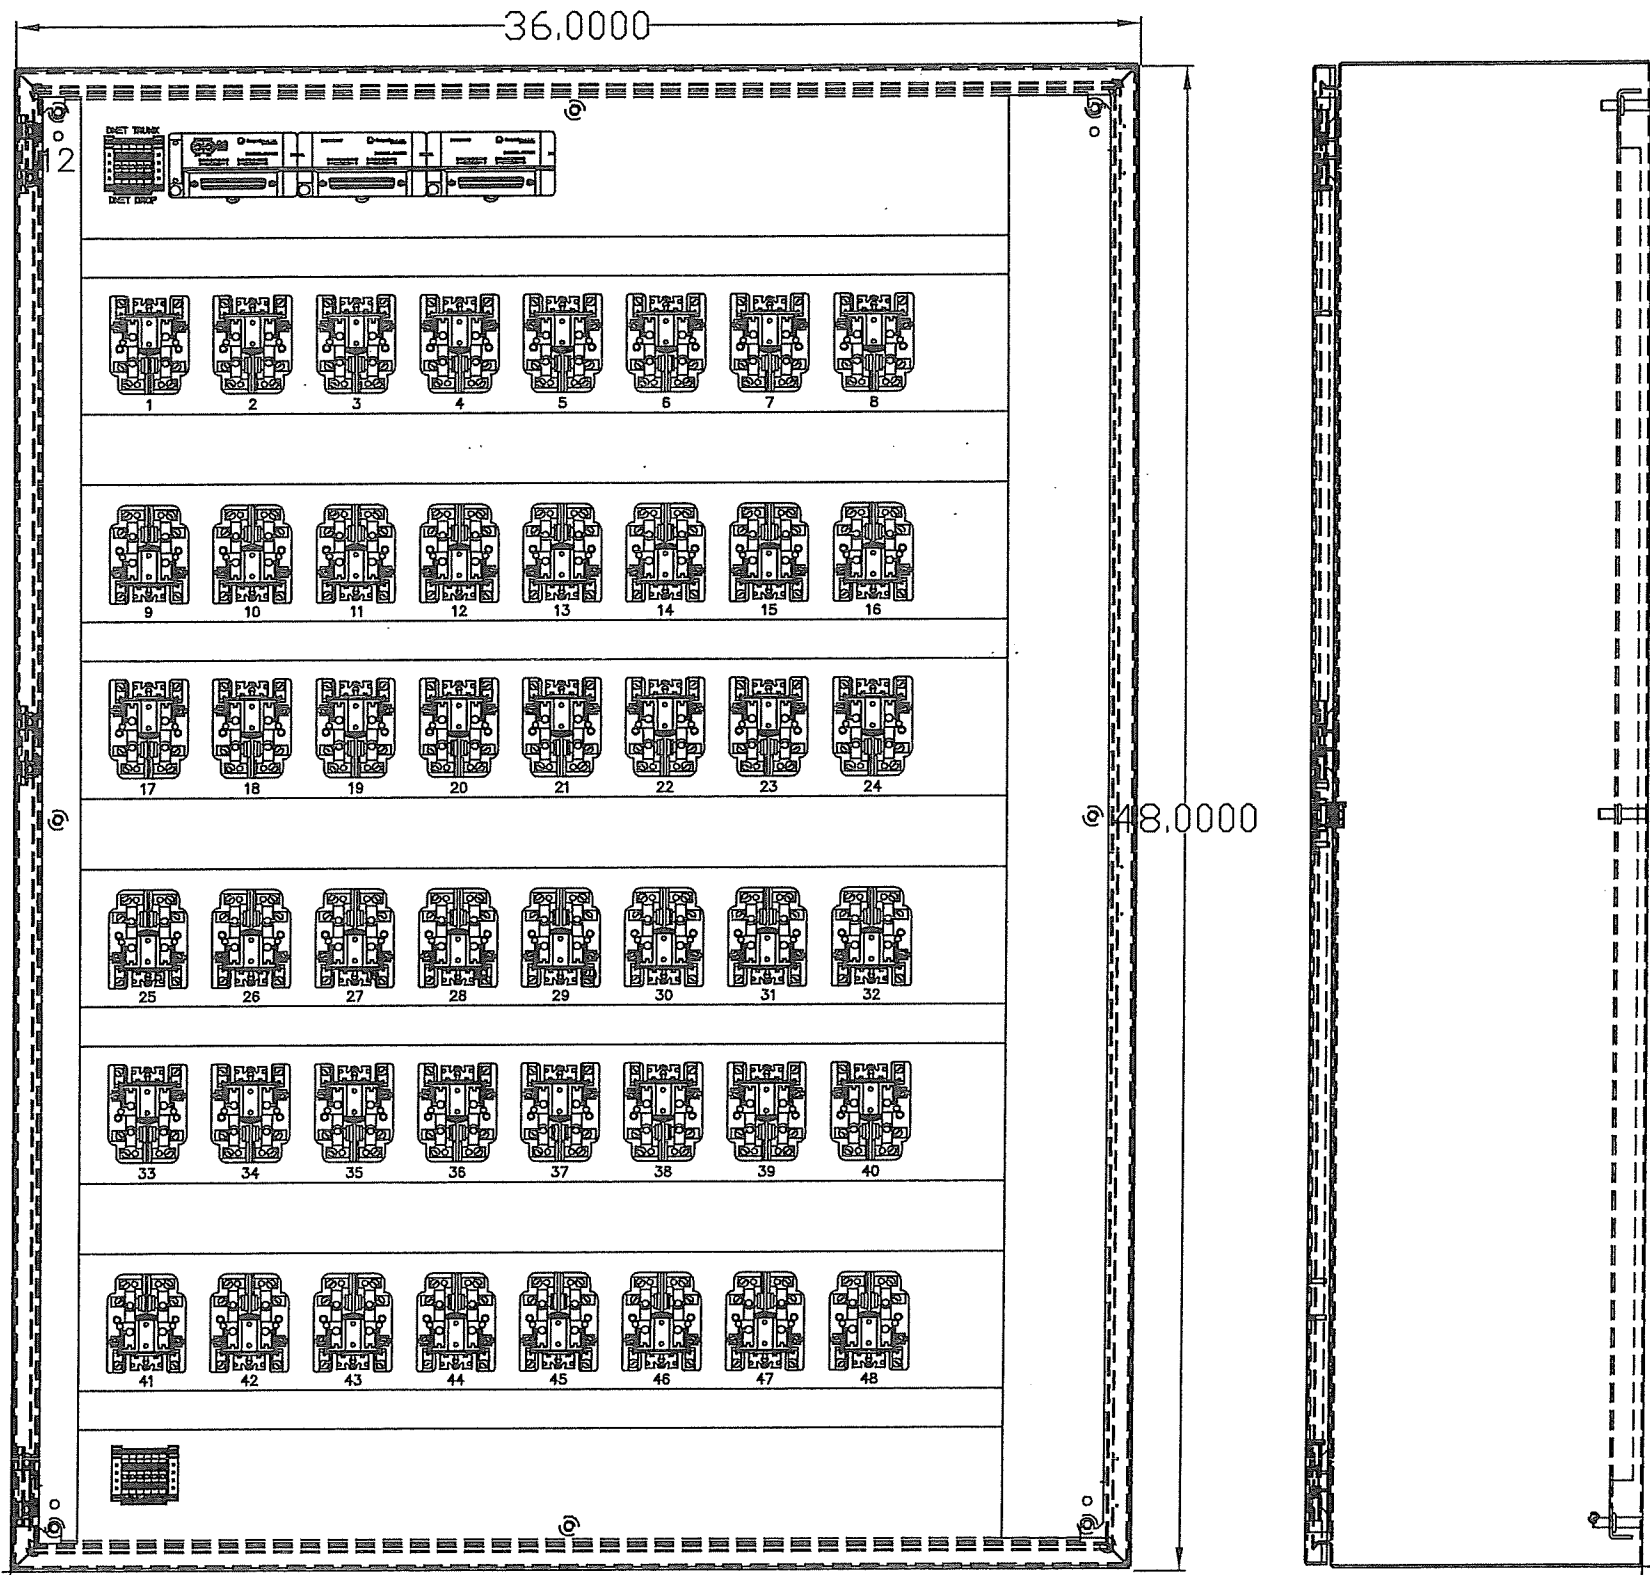

UCP-1 PANEL LAYOUT

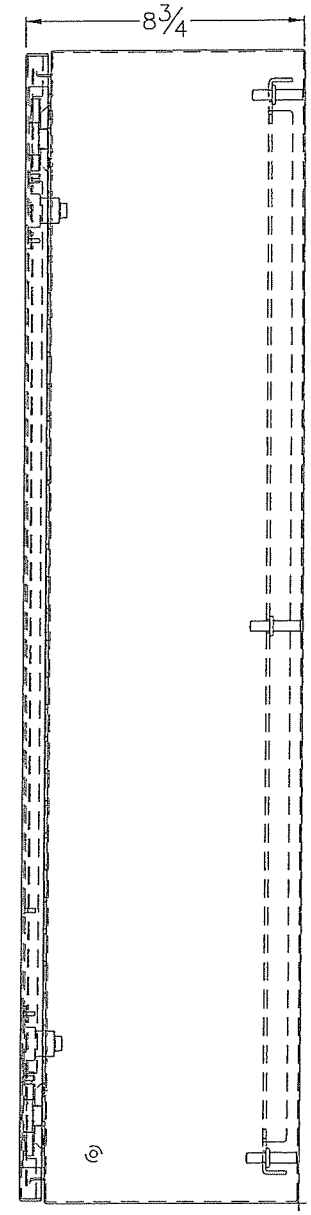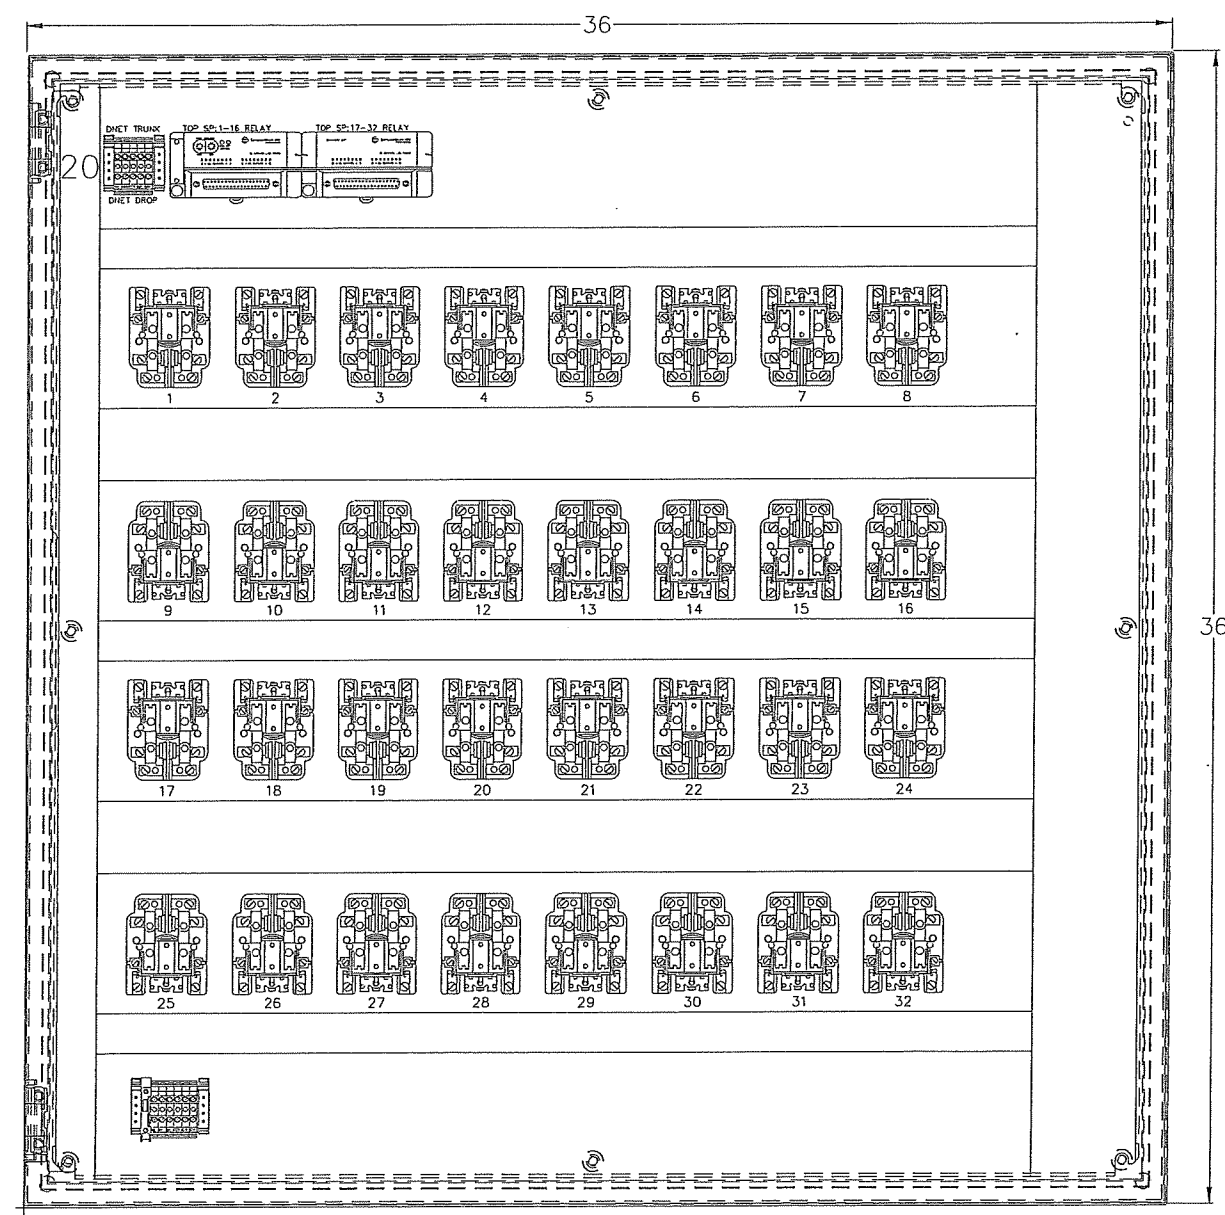

UCP-2 PANEL LAYOUT

The information hereon is property of Stanley Security Solutions, integrator.com Division and shall not be transmitted, copied, or used for purposes other than that for which it was intended.

STANLEY

integrator.com

14570 Cumberland Road
Noblesville, Indiana 46060
Phone: (317) 776-3500 Fax: (317) 776-3510
www.integrator.com

STANLEY

Security Solutions

TITLE

JACKSON COUNTY JAIL

JEFFERSON, GA

UCP-2 PANEL LAYOUT

JOB #:

V.1666

JOB DATE:

2/25/2008

APPROVAL:

JB

APPROVAL DATE:

DESIGN:

BRANDEN FRY

SOFTWARE:

CHRIS MARLOW

PROJECT MANAGER:

JASON BRYAN

REVISIONS

DESCRIPTION	BY	DATE
1		
2		
3		
4		
5		
6		

FILENAME:

JCGA-151.1.DWG

DWG NO.

ES151.1

The information hereon is property of Stanley Security Solutions, integrator.com Division and shall not be transmitted, copied, or used for purposes other than that for which it was intended.

STANLEY
integrator.com
14670 Cumberland Road
Noblesville, Indiana 46060
Phone: (317) 776-3500 Fax: (317) 776-3520
www.integrator.com

STANLEY
Security Solutions

TITLE
JACKSON COUNTY JAIL

JEFFERSON, GA
UCP-3 PANEL LAYOUT

JOB #:	V.1666	JOB DATE:	2/25/2008
APPROVAL:	JB	APPROVAL DATE:	



DESIGN: **BRANDEN FRY**
SOFTWARE: **CHRIS MARLOW**
PROJECT MANAGER: **JASON BRYAN**

REVISIONS		BY/DATE
DESCRIPTION		
1		
2		
3		
4		
5		
6		

FILENAME: JCGA-151.2.DWG

DWG NO.

ES151.2

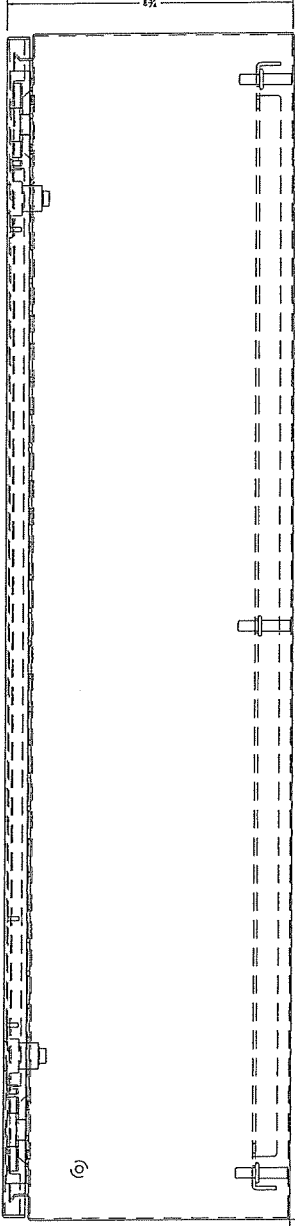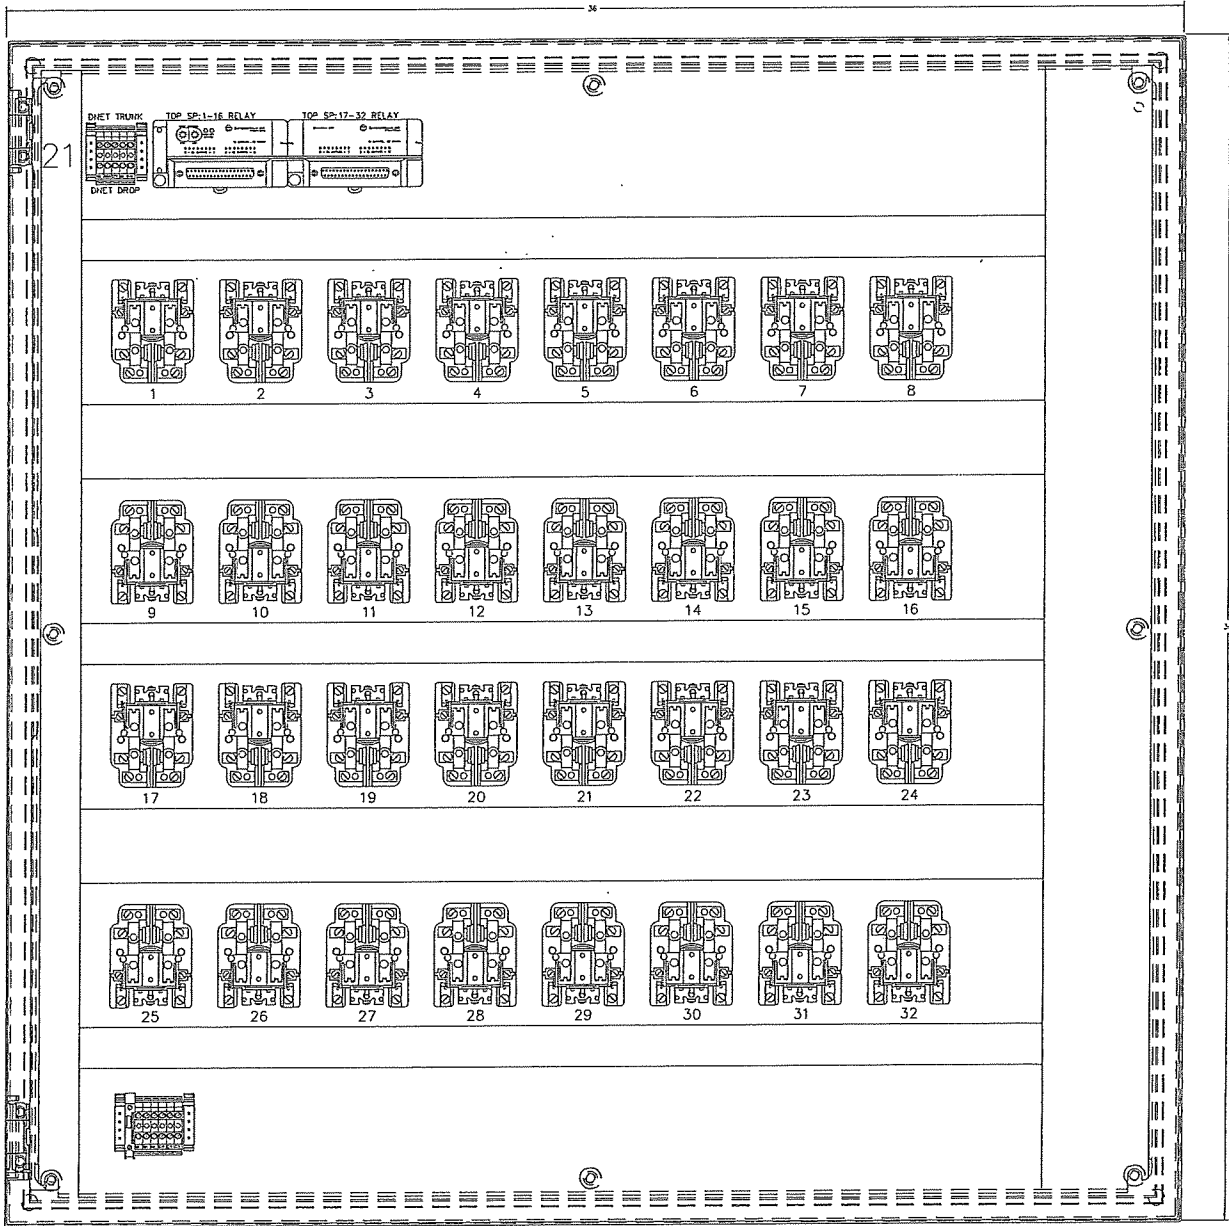

UCP-3 PANEL LAYOUT

NOTES:
1. WIRE COLORS ARE SUBJECT TO CHANGE
DEPENDING ON WIRE TYPE USED.

The information hereon is
property of Stanley Security
Solutions, Integrator.com
Division and shall not be
transmitted, copied, or used for
purposes other than that for
which it was intended.

STANLEY
integrator.com
14670 Cumberland Road
Noblesville, Indiana 46060
Phone: (317) 776-5500 Fax: (317) 776-5550
www.integrator.com

STANLEY
Security Solutions

TITLE
JACKSON COUNTY JAIL

JEFFERSON, GA

SYSTEM COMM

JOB #: V.1666 JOB DATE: 2/25/2008
APPROVAL: JB APPROVAL DATE:

DESIGN: BRANDEN FRY

SOFTWARE: CHRIS MARLOW

PROJECT MANAGER: JASON BRYAN


REVISIONS

DESCRIPTION	BY	DATE
1		
2		
3		
4		
5		
6		

FILENAME: JCGA-ES200.0

DWG NO.

ES200.0

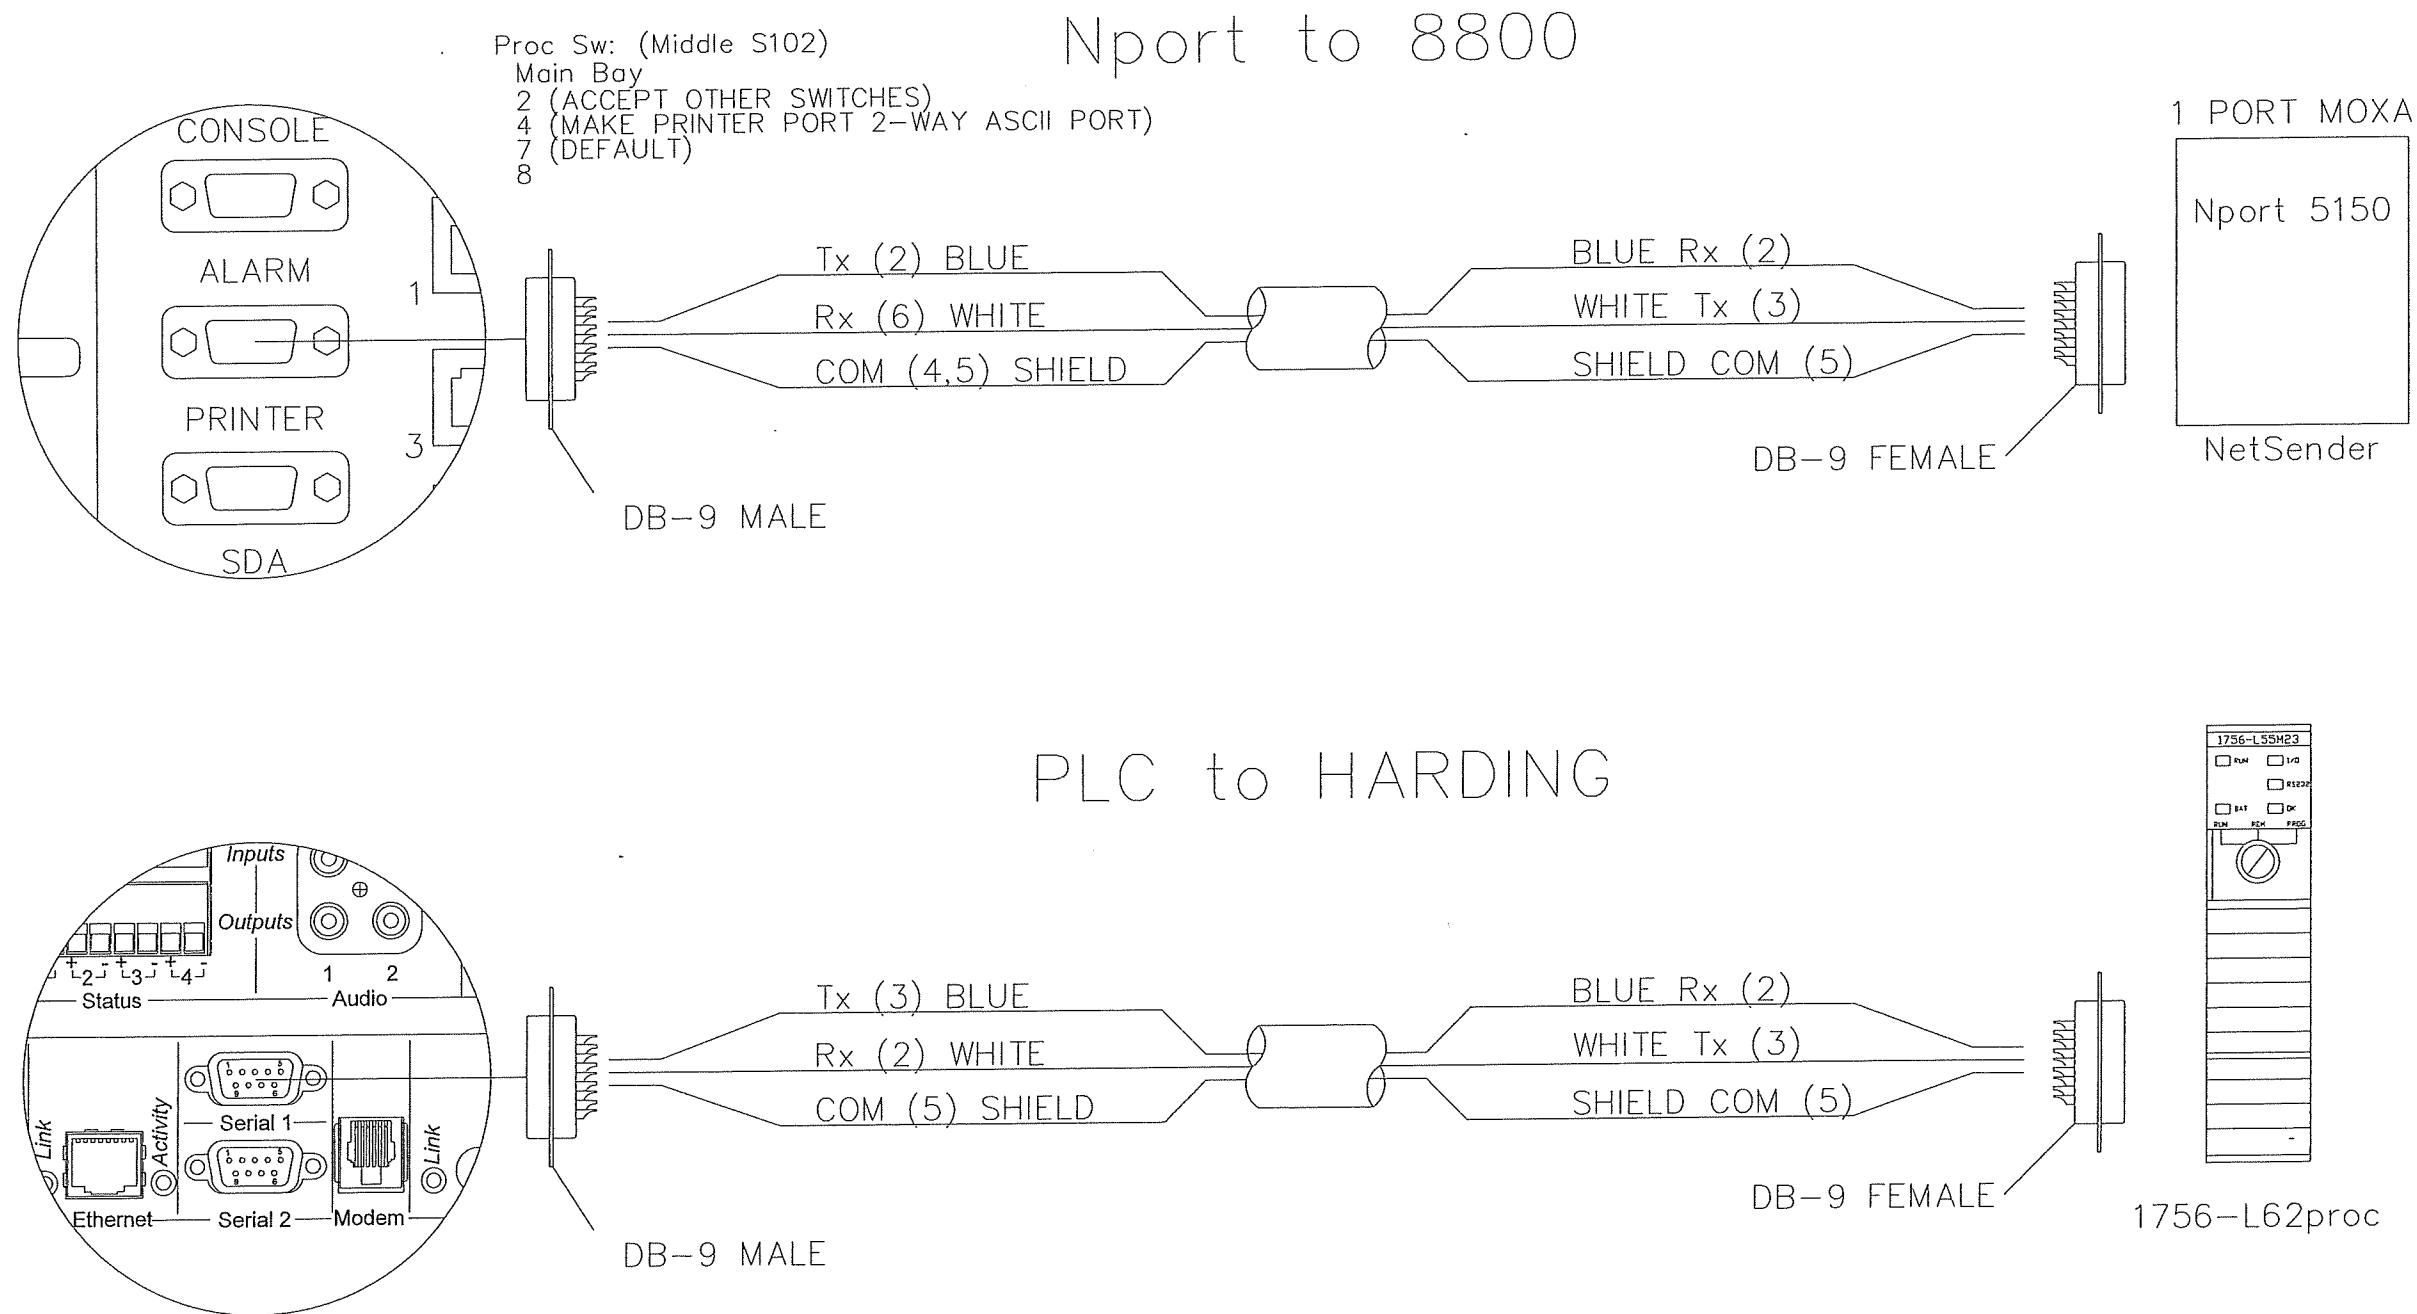

The information hereon is property of Stanley Security Solutions, Integrator.com Division and shall not be transmitted, copied, or used for purposes other than that for which it was intended.

STANLEY
integrator.com
14670 Cumberland Road
Noblesville, Indiana 46060
Phone: (317) 776-3500 Fax: (317) 776-9510
www.integrator.com

STANLEY®
Security Solutions

TITLE
JACKSON COUNTY JAIL
JEFFERSON, GA
LOOP PANEL LAYOUT


JOB #: V.1666
JOB DATE: 2/25/2008
APPROVAL: JB
APPROVAL DATE:

DESIGN: BRANDEN FRY
SOFTWARE: CHRIS MARLOW
PROJECT MANAGER: JASON BRYAN


REVISIONS	
DESCRIPTION	BY/DATE
⚠	
⚠	
⚠	
⚠	
⚠	
⚠	

FILENAME: JCGA-ES200.1


DWG NO.
ES200.1

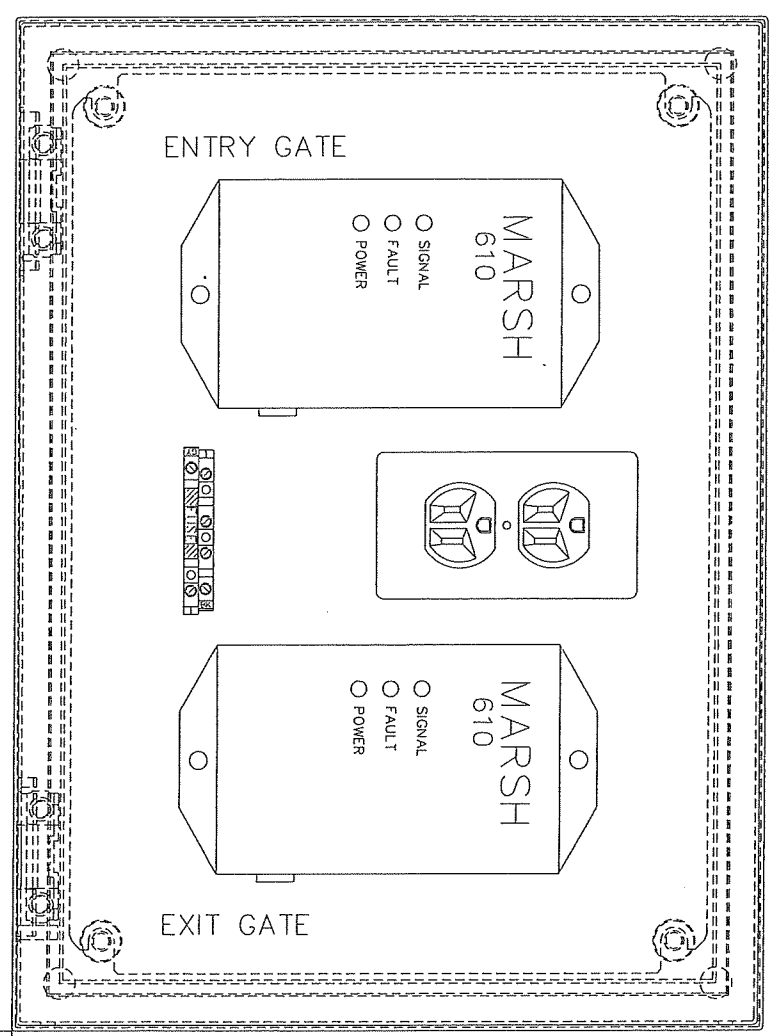

TYPICAL GATE (x2)

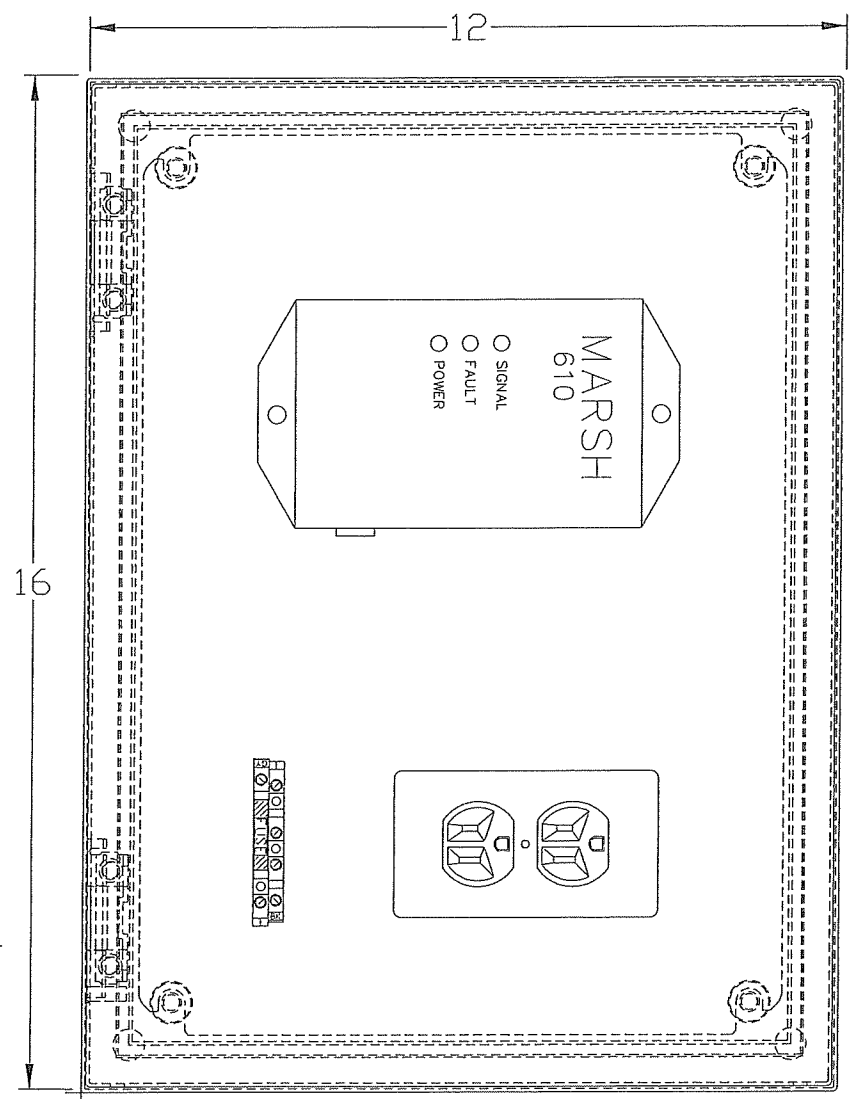

VEHICLE SALLYPORT

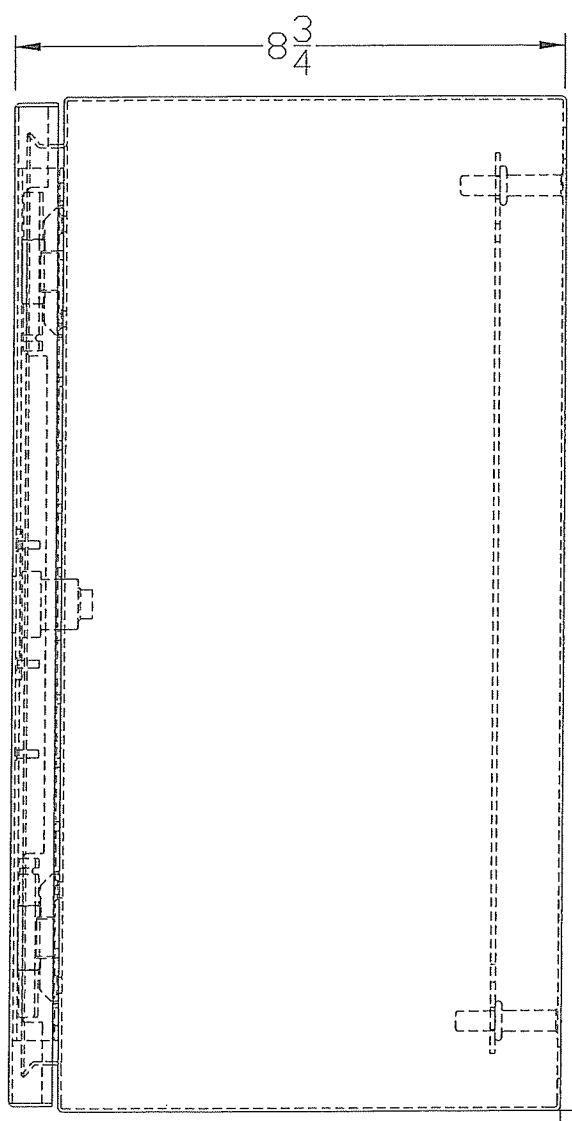

The information hereon is property of Stanley Security Solutions, integrator.com Division and shall not be transmitted, copied, or used for purposes other than that for which it was intended.

STANLEY
integrator.com
14670 Cumberland Road
Noblesville, Indiana 46060
Phone: (317) 776-3500 Fax: (317) 776-3510
www.integrator.com

STANLEY
Security Solutions

TITLE
JACKSON COUNTY JAIL
JEFFERSON, GA
BOLLARD DETAIL

JOB #: V.1666
JOB DATE: 2/25/2008
APPROVAL: JB
APPROVAL DATE:

DESIGN: BRANDEN FRY

SOFTWARE: CHRIS MARLOW

PROJECT MANAGER: JASON BRYAN

REVISIONS

DESCRIPTION	BY	DATE
△		
△		
△		
△		
△		
△		

FILENAME: JCGA-ES200.2

DWG NO.

ES200.2

CAP TO PREVENT
WATER
INFILTRATION

CAMERA MOUNTED
AT 16'-0"

3" DIA STEEL TUBING
SCHEDULE 40

CALL BOX - REFER
TO SECURITY
ELECTRONICS
DRAWINGS

NOTE:
REFER TO 2002.0 FOR BALANCE OF NOTES

Call Box Detail


Call Box Detail

DRIVE-UP GATE BOLLARD DETAIL

STANLEY
integrator.com
14570 Cumberland Road
Noblesville, Indiana 46060
Phone: (317) 776-5310
www.integrator.com

STANLEY®
Security Solutions

 ES210.0




The information hereon is property of Stanley Security Solutions, integrator.com Division and shall not be transmitted, copied, or used for purposes other than that for which it was intended.

STANLEY
integrator.com
14670 Cumberland Road
Noblesville, Indiana 46060
Phone: (317) 765-3311
www.integrator.com

STANLEY
Security Solutions



TITLE	
JACKSON COUNTY JAIL	
JEFFERSON, GA	
MASTER DIAGRAM	
JOB #:	JOB DATE:
V.1666	2/25/2008
APPROVAL:	APPROVAL DATE:
JB	
DESIGN: BRANDEN FRY	
SOFTWARE: CHRIS MARLOW	
PROJECT MANAGER: JASON BRYAN	
REVISIONS	
DESCRIPTION	BY/DATE
1	
2	
3	
4	
5	
6	
FILENAME: JCGA-ES210.1	
DWG NO.	
ES210.1	

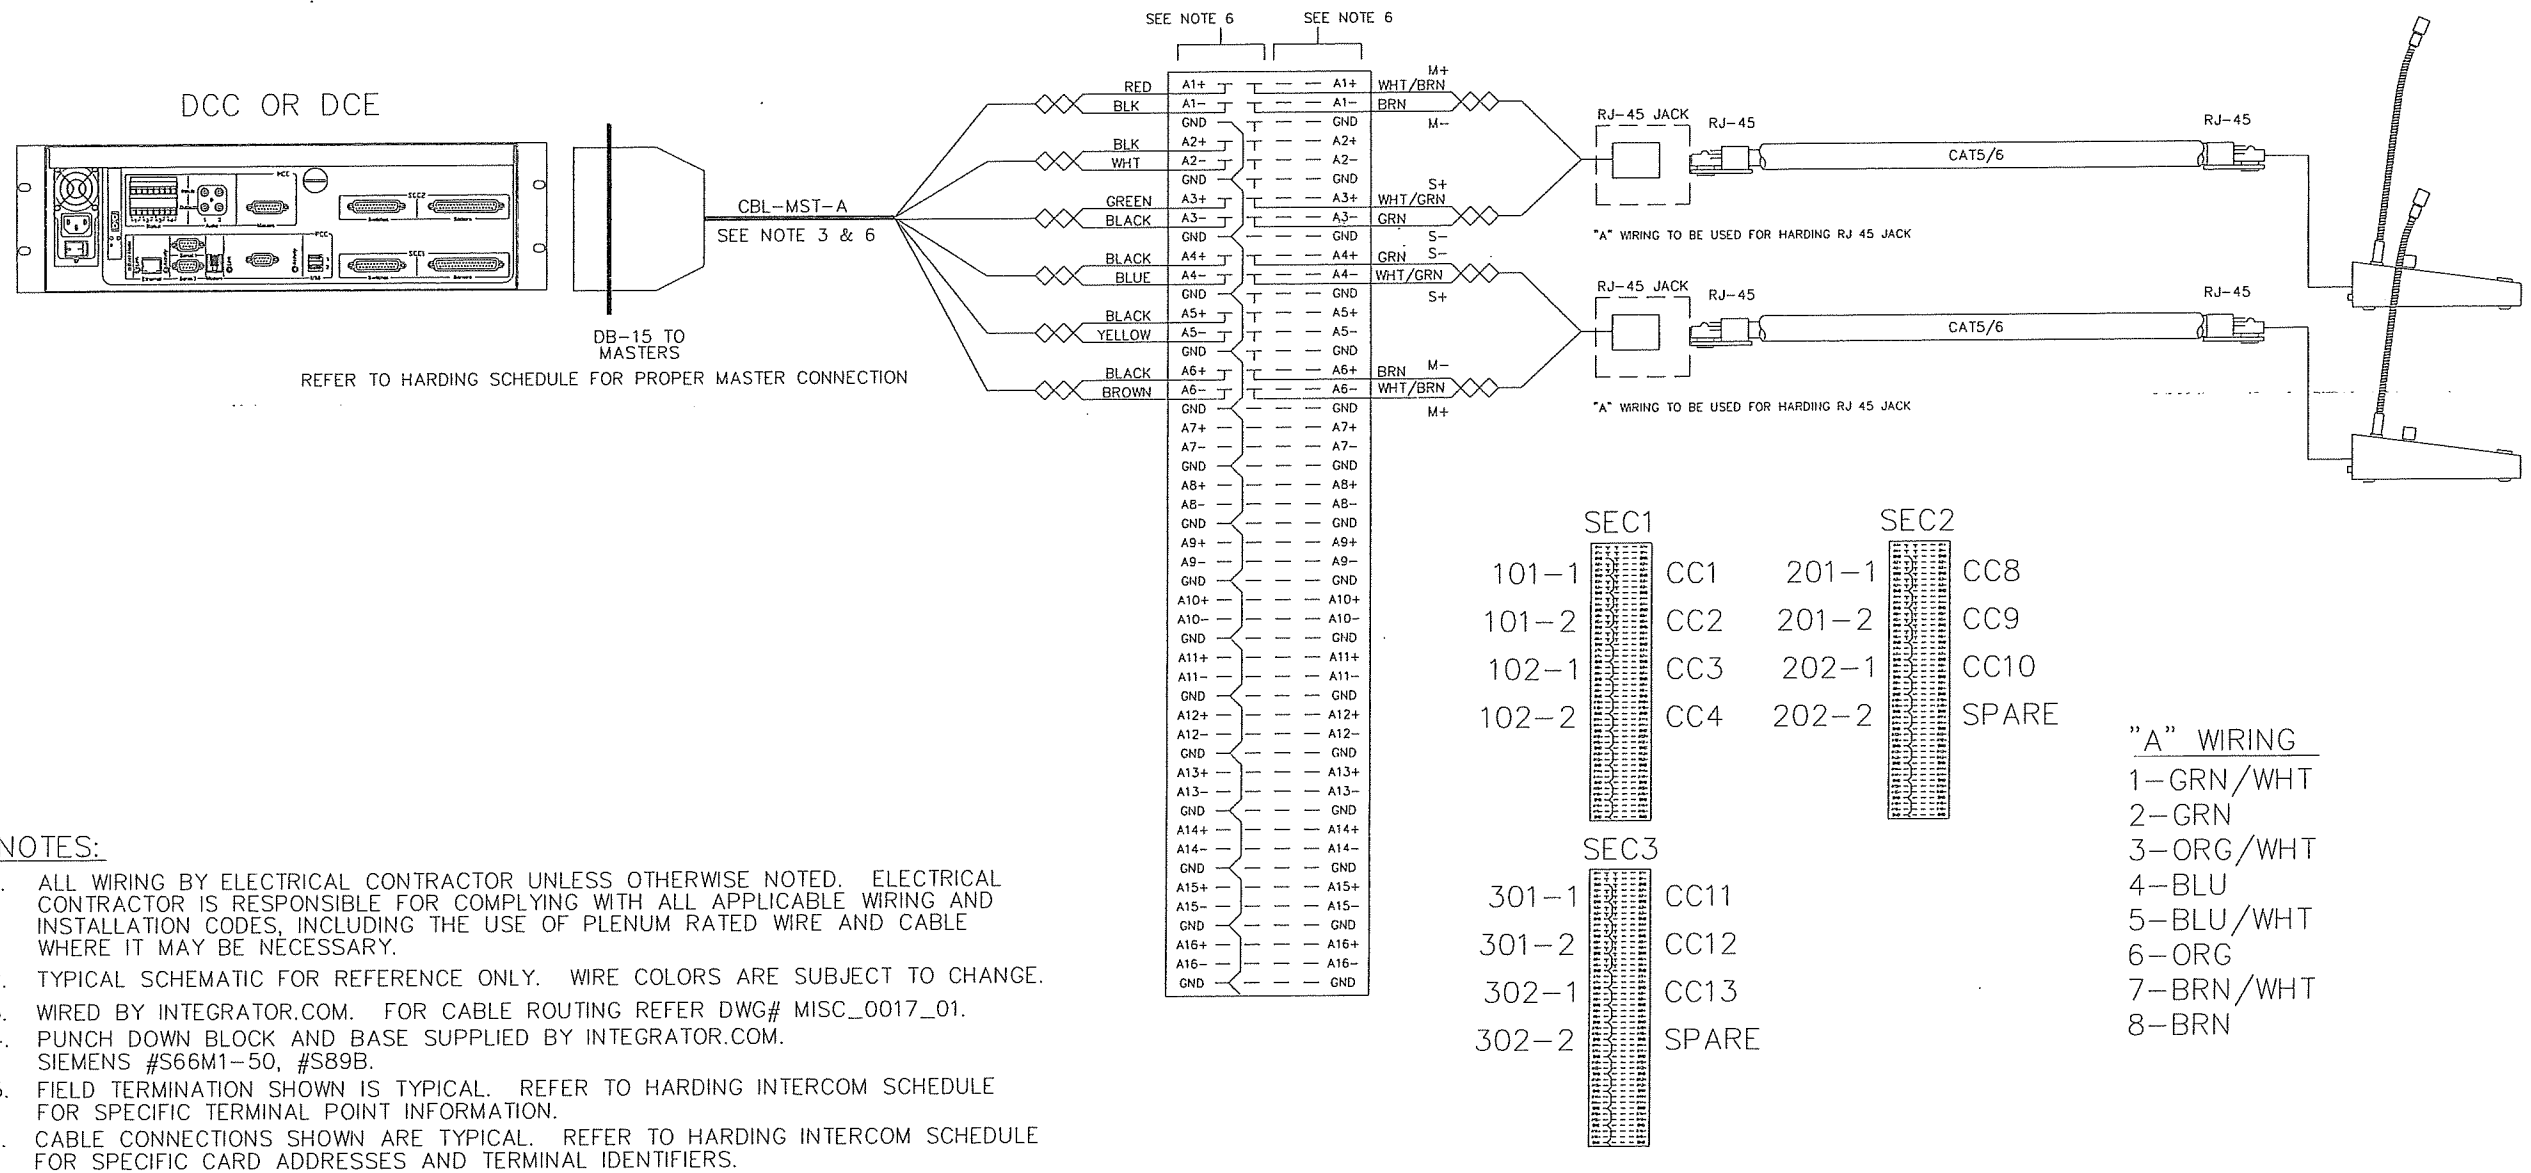

NOTES:

1. ALL WIRING BY ELECTRICAL CONTRACTOR UNLESS OTHERWISE NOTED. ELECTRICAL CONTRACTOR IS RESPONSIBLE FOR COMPLYING WITH ALL APPLICABLE WIRING AND INSTALLATION CODES, INCLUDING THE USE OF PLENUM RATED WIRE AND CABLE WHERE IT MAY BE NECESSARY.
2. TYPICAL SCHEMATIC FOR REFERENCE ONLY. WIRE COLORS ARE SUBJECT TO CHANGE.
3. WIRED BY INTEGRATOR.COM. FOR CABLE ROUTING REFER DWG# MISC_0017_01.
4. PUNCH DOWN BLOCK AND BASE SUPPLIED BY INTEGRATOR.COM. SIEMENS #S66M1-50, #S89B.
5. FIELD TERMINATION SHOWN IS TYPICAL. REFER TO HARDING INTERCOM SCHEDULE FOR SPECIFIC TERMINAL POINT INFORMATION.
6. CABLE CONNECTIONS SHOWN ARE TYPICAL. REFER TO HARDING INTERCOM SCHEDULE FOR SPECIFIC CARD ADDRESSES AND TERMINAL IDENTIFIERS.

MASTER STATION WIRING DIAGRAM

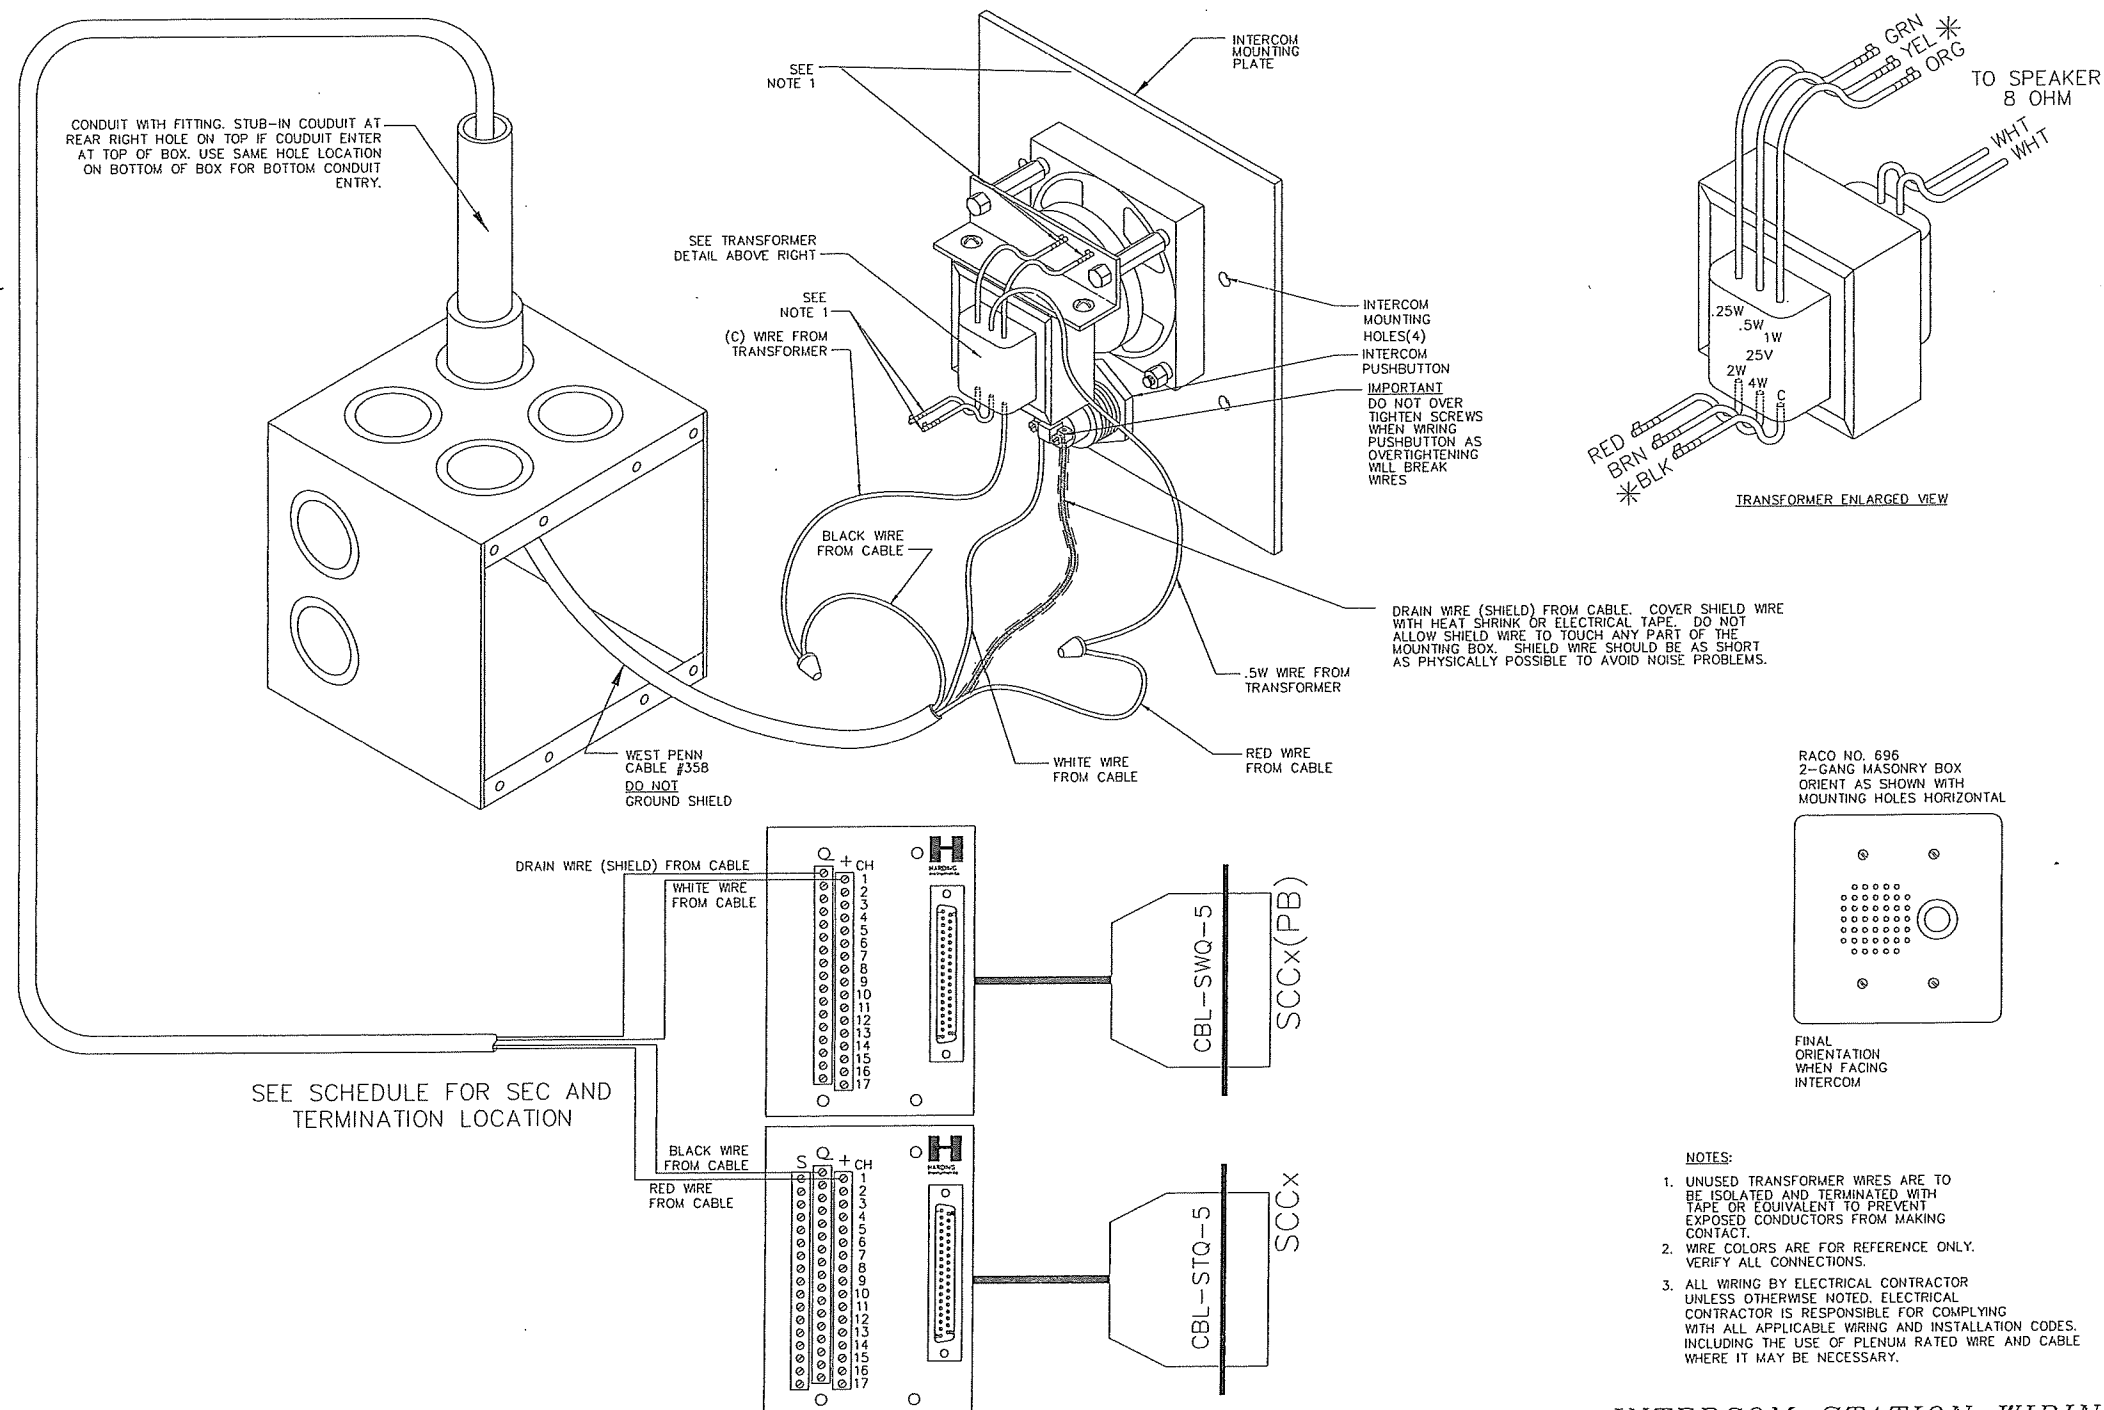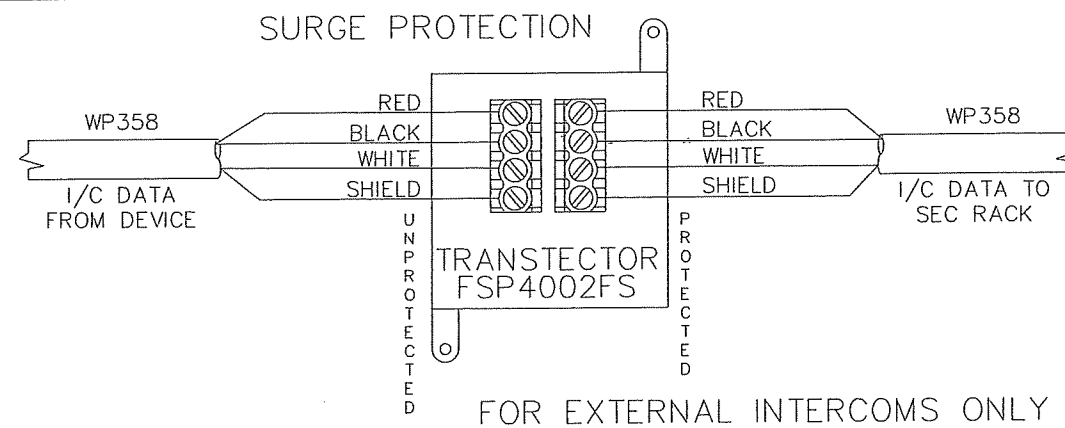

INTERCOM STATION WIRING DIAGRAM

The information hereon is property of Stanley Security Solutions, Integrator.com Division and shall not be transmitted, copied, or used for purposes other than that for which it was intended.

STANLEY integrator.com
14670 Cumberland Road
Noblesville, Indiana 46060
Phone: (317) 776-3500 Fax: (317) 776-3510
www.integrator.com


STANLEY Security Solutions

TITLE	
JACKSON COUNTY JAIL	
JEFFERSON, GA	
INTERCOM DIAGRAM	
JOB #:	V.1666
JOB DATE:	2/25/2008
APPROVAL:	JJB
APPROVAL DATE:	
DESIGN:	BRANDEN FRY
SOFTWARE:	CHRIS MARLOW
PROJECT MANAGER:	JASON BRYAN
REVISIONS	
DESCRIPTION	BY/DATE
1	
2	
3	
4	
5	
6	
FILENAME: JCGA-ES210.2	
DWG NO.	
ES210.2	

The information hereon is property of Stanley Security Solutions, integrator.com Division and shall not be transmitted, copied, or used for purposes other than that for which it was intended.

STANLEY
integrator.com
14670 Cumberland Road
Noblesville, Indiana 46060
Phone: (317) 776-3500 Fax: (317) 776-3510
www.integrator.com

STANLEY
Security Solutions

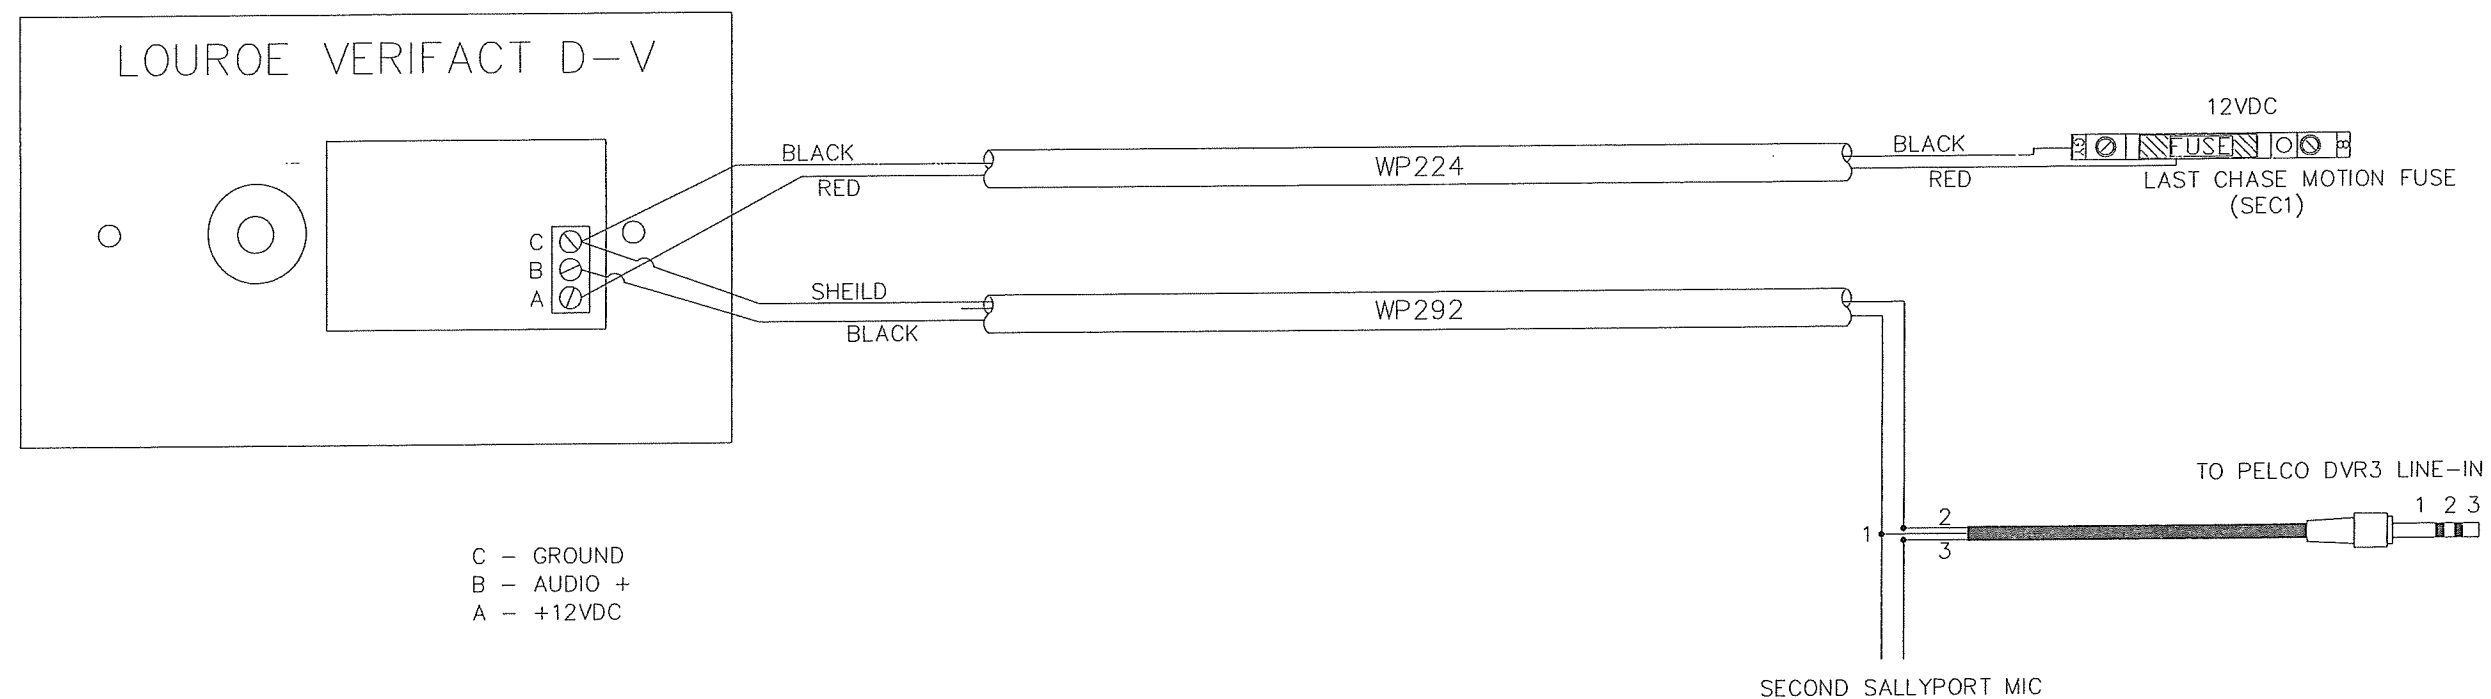

C - GROUND
B - AUDIO +
A - +12VDC

TITLE	
JACKSON COUNTY JAIL	
JEFFERSON, GA	
COVERT MICROPHONE	
JOB #:	JOB DATE:
V.1666	2/25/2008
APPROVAL:	APPROVAL DATE:
JB	
DESIGN: BRANDEN FRY	
SOFTWARE: CHRIS MARLOW	
PROJECT MANAGER: JASON BRYAN	
REVISIONS	
DESCRIPTION	BY/DATE
1	
2	
3	
4	
5	
6	
FILENAME: JCGA-ES210.3	
DWG NO.	
ES210.3	

SALLYPORT COVERT MICROPHONE WIRING DETAIL

The information hereon is property of Stanley Security Solutions, integrator.com Division and shall not be transmitted, copied, or used for purposes other than that for which it was intended.

STANLEY
integrator.com
14670 Cumberland Road
Noblesville, Indiana 46060
Phone: (317) 776-3500 Fax: (317) 776-3510
www.integrator.com

STANLEY
Security Solutions

TITLE
JACKSON COUNTY JAIL

JEFFERSON, GA

CCTV DIAGRAM

JOB #: V.1666 JOB DATE: 2/25/2008
APPROVAL: JB APPROVAL DATE:

DESIGN: BRANDEN FRY
SOFTWARE: CHRIS MARLOW


PROJECT MANAGER: JASON BRYAN

REVISIONS	
DESCRIPTION	BY/DATE
1	
2	
3	
4	
5	
6	

FILENAME: JCGA-ES220.0

DWG NO.

ES220.0

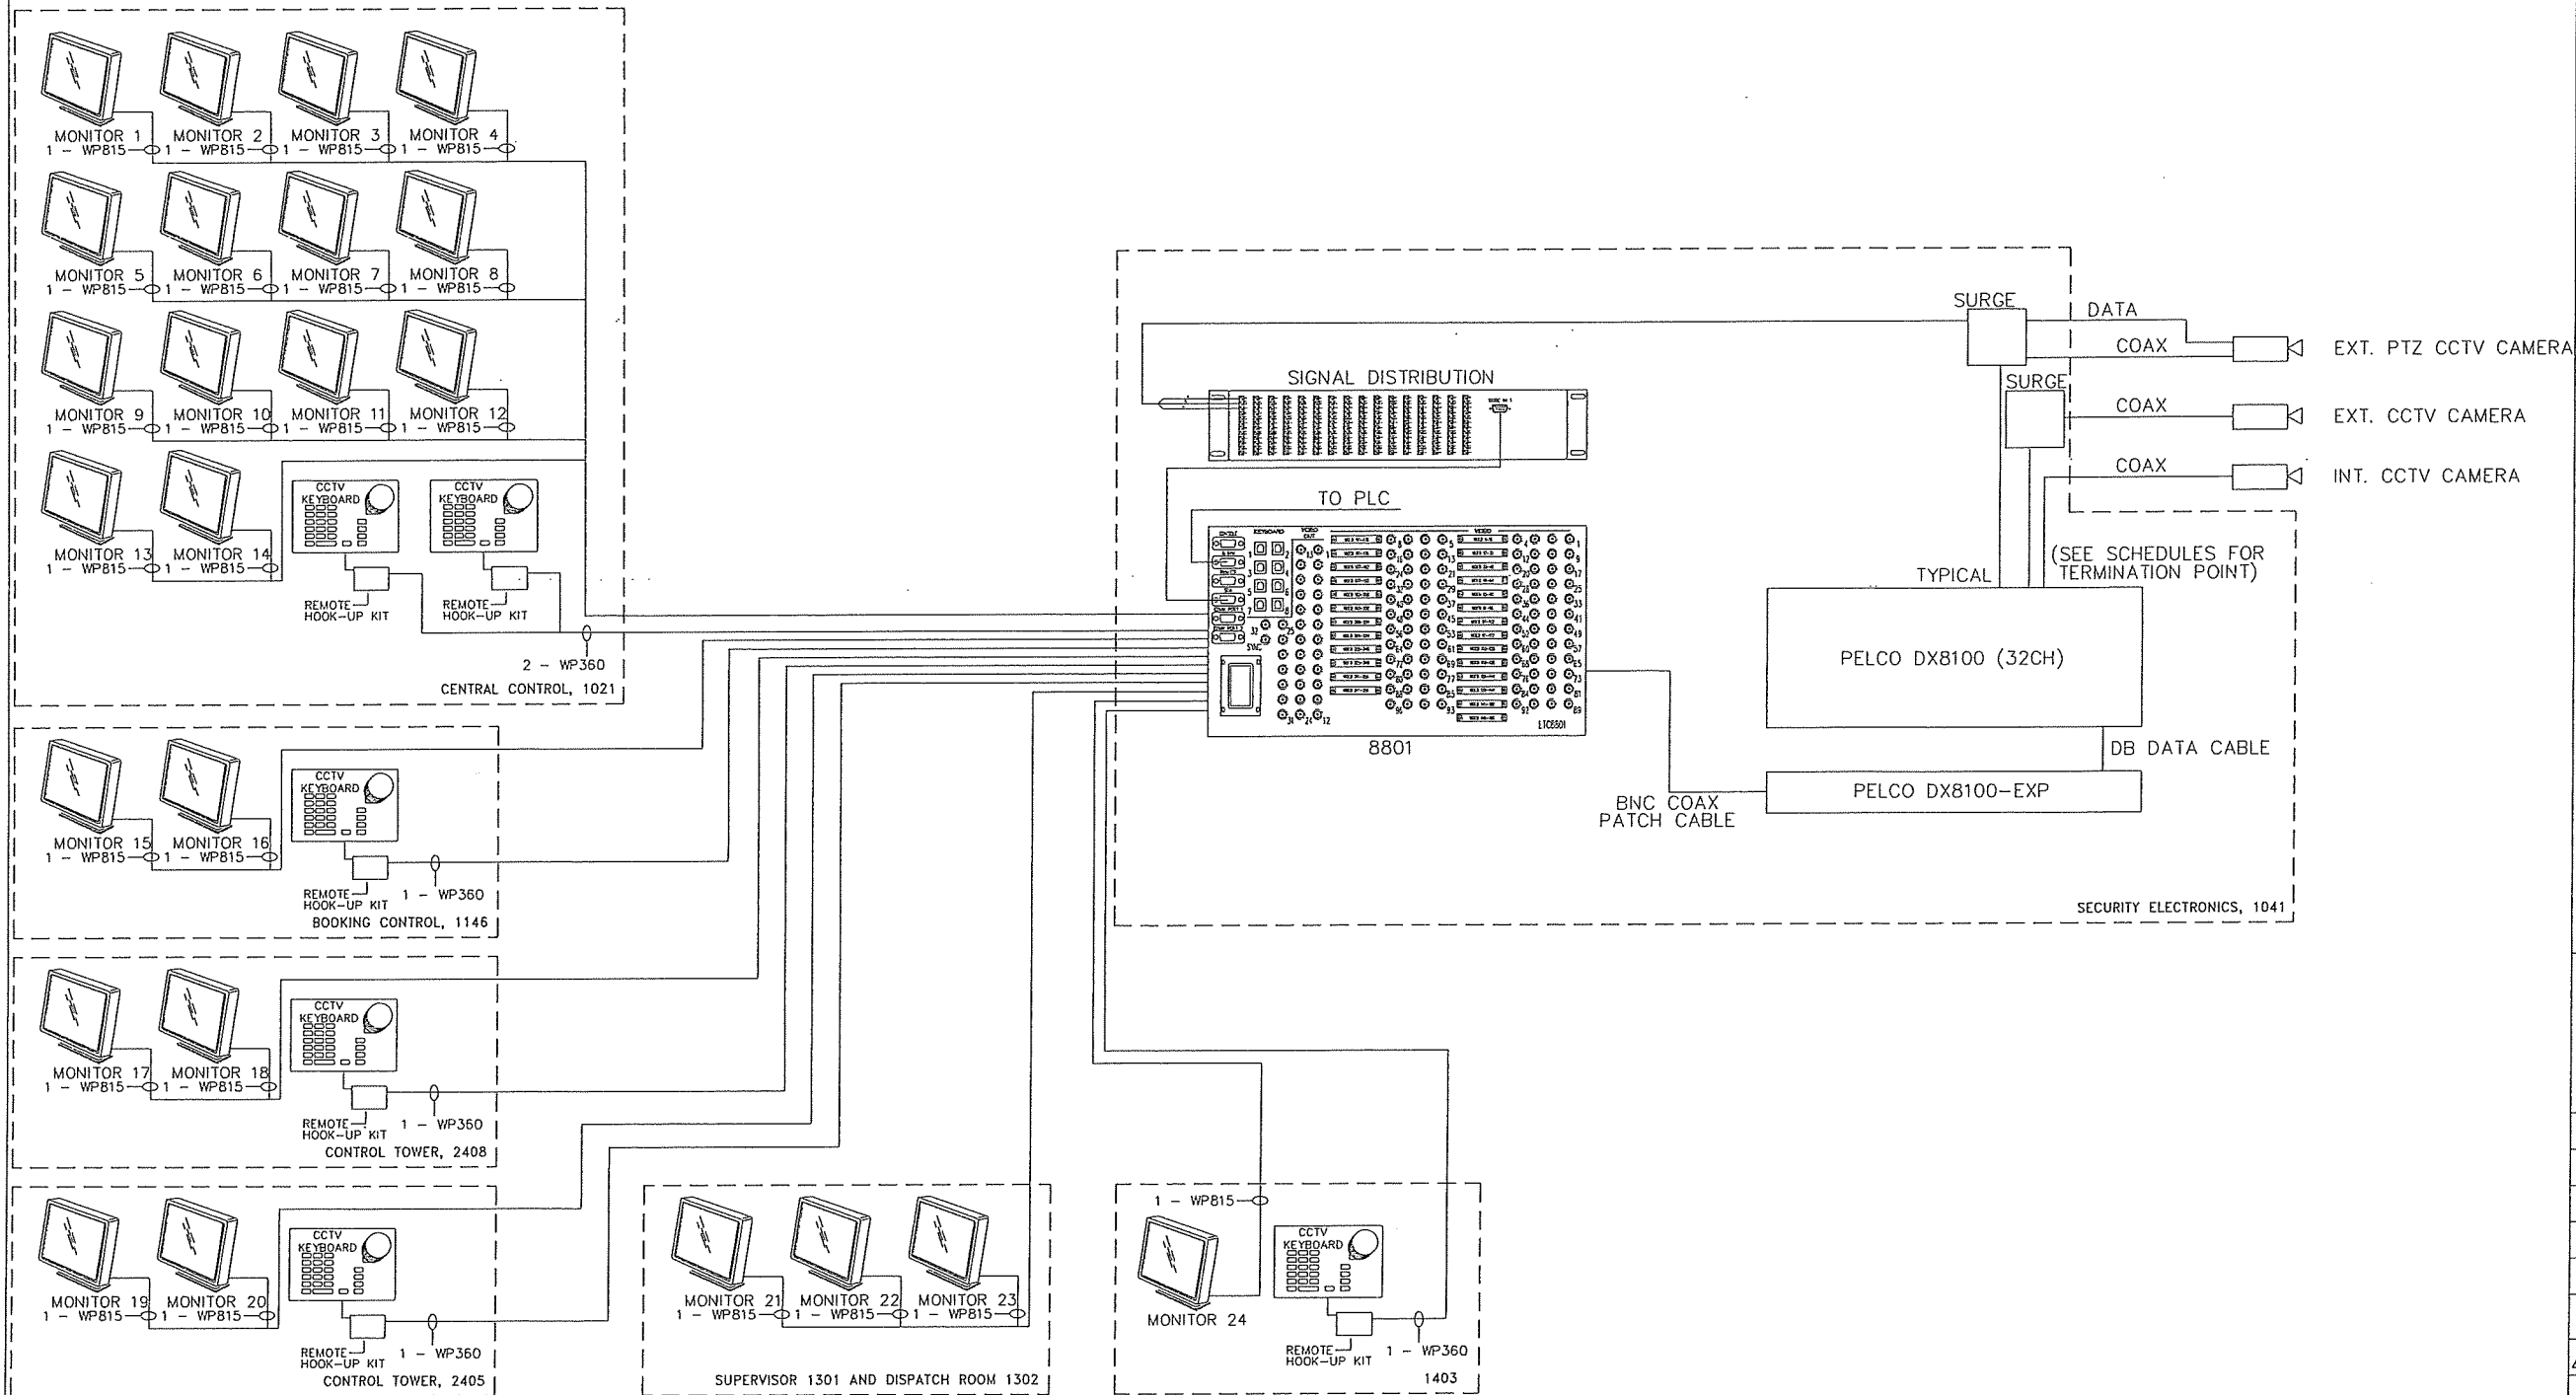

CCTV HEADEND INTERCONNECTION DIAGRAM

The information hereon is property of Stanley Security Solutions, Integrator.com Division and shall not be transmitted, copied, or used for purposes other than that for which it was intended.

STANLEY
integrator.com
14670 Cumberland Road
Noblesville, Indiana 46060
Phone: (317) 776-5550
www.integrator.com

STANLEY
Security Solutions

TITLE
JACKSON COUNTY JAIL

JEFFERSON, GA

57700 WIRING DETAIL

JOB #: V.1666 JOB DATE: 2/25/2008

APPROVAL: JB APPROVAL DATE:

DESIGN: BRANDEN FRY

SOFTWARE: CHRIS MARLOW

PROJECT MANAGER: JASON BRYAN

REVISIONS

DESCRIPTION	BY/DATE
1	
2	
3	
4	
5	
6	


FILENAME: JCGA-ES900.0

DWG NO.

ES900.0

LEFT SIDE PANEL WIRING (SEE NOTE 6)

RIGHT SIDE PANEL WIRING (SEE NOTE 6)

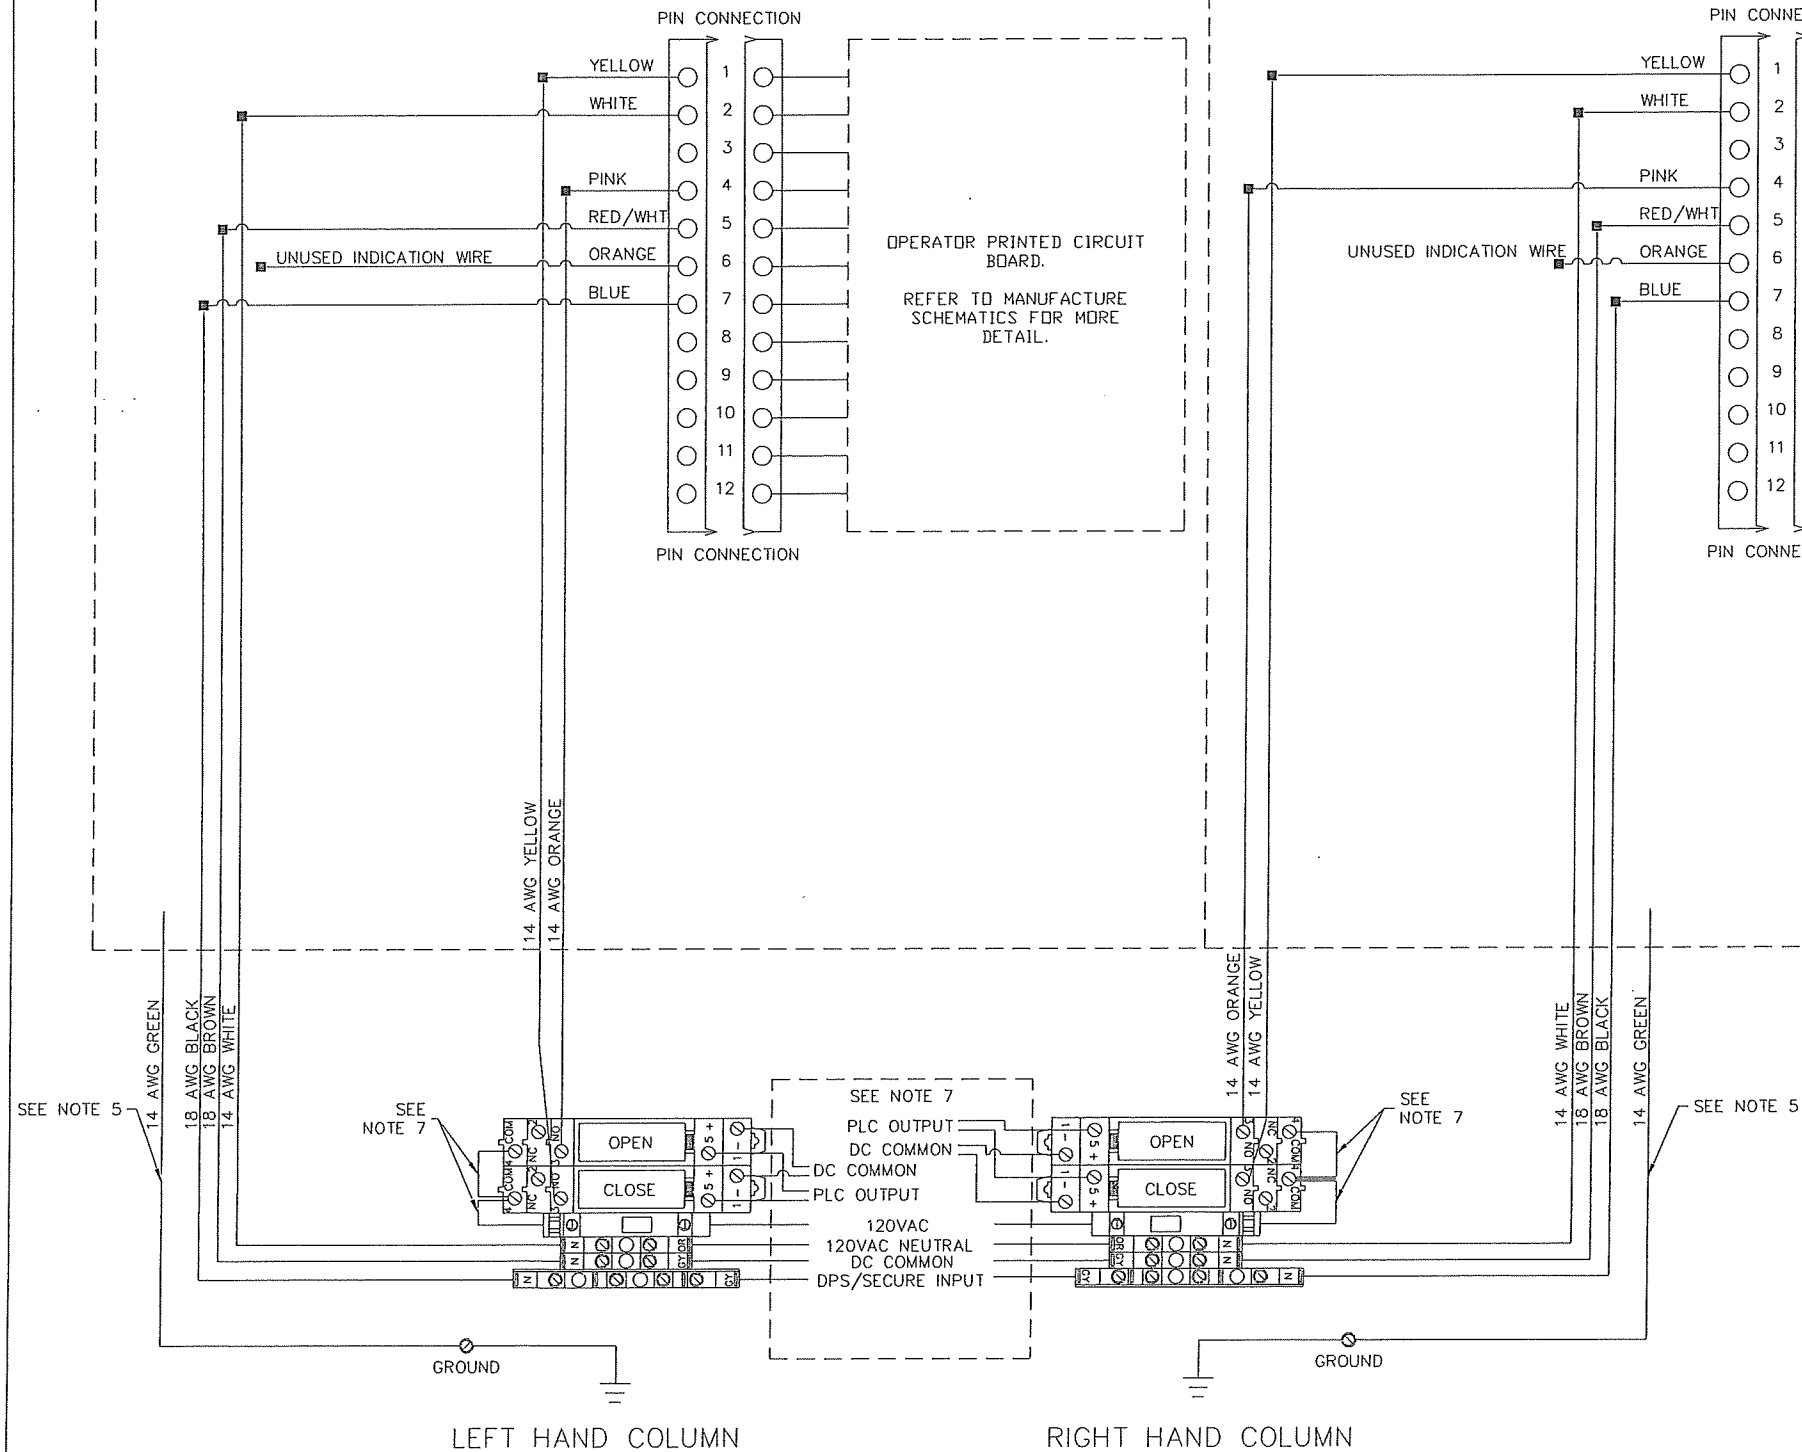

NOTES:

1. ALL WIRING BY ELECTRICAL CONTRACTOR UNLESS OTHERWISE NOTED. ELECTRICAL CONTRACTOR IS RESPONSIBLE FOR COMPLYING WITH ALL APPLICABLE WIRING AND INSTALLATION CODES, INCLUDING THE USE OF PLENUM RATED WIRE AND CABLE WHERE IT MAY BE NECESSARY.
2. TYPICAL LOCK SCHEMATIC FOR REFERENCE ONLY. WIRE COLORS ARE SUBJECT TO CHANGE.
3. LOCK, WIRE HARNESS, AND INDICATOR SWITCHES BY OTHERS.
4. SEE DOOR SCHEDULE FOR HARDWARE SET(S) & FUSING INFORMATION.
5. IF LOCK CAN BE GROUNDED LOCALLY, OMIT 14AWG. GREEN GROUND WIRE.
6. DOORS ARE WIRED TO ONLY ONE RELAY. REFER TO DOOR SCHEDULE FOR TERMINATION DETAILS.
7. WIRED BY INTEGRATOR.COM.

RRBRINK 57700 SLIDER LOCK WIRING DETAIL DETAILS