




 FLOOR PLAN AREA "A" - HVAC
SCALE: 1/8" = 1'-0"

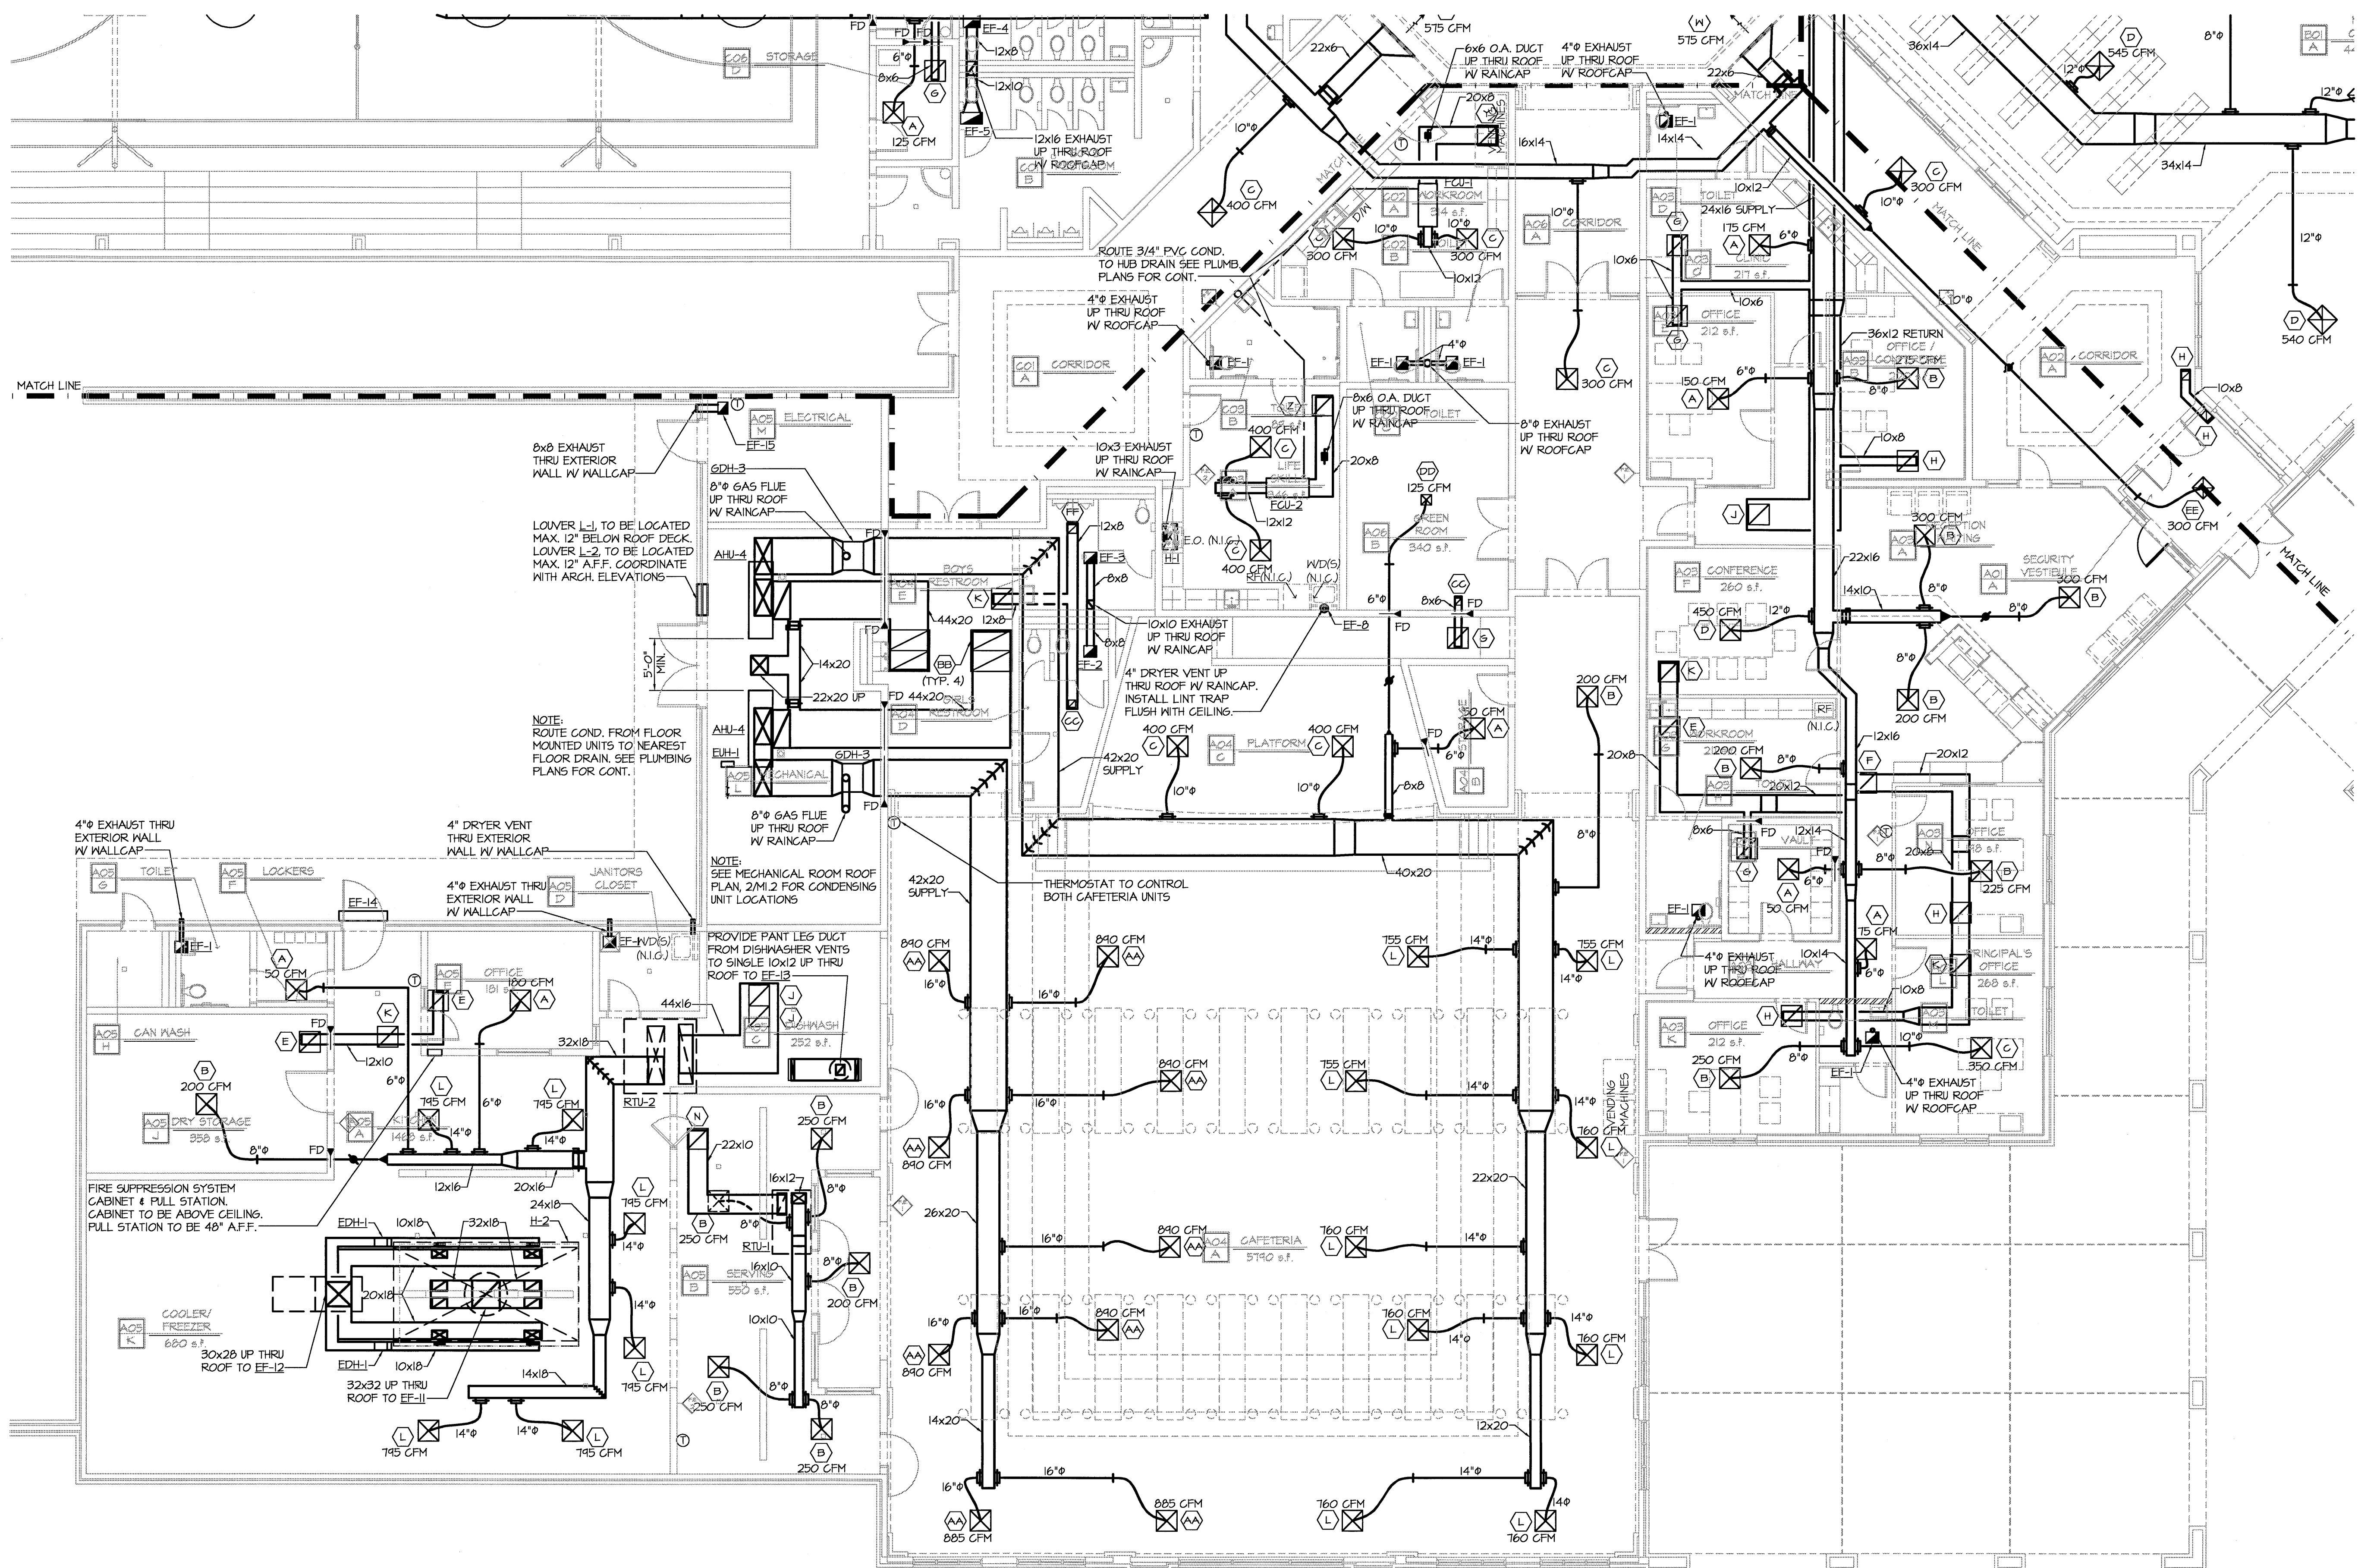