


XXXX = INFORMATION STILL BEING RESEARCHED.

Q:\CTD\OBG-Line Emerg Pwr Gen\OBG-Line Emerg Pwr Gen CURRENT.dwg

REV	DATE	DESCRIPTION	BY	CHK'D	AP'D
12	07/10/18	PUMP ROOM INVERTERS ADDED	GZ	JJW	DTM
11	06/19/12	GENERAL REVISIONS, NO INFORMATION CHANGED	MJD	JJW	DTM
10	06/10/09	SANSON SUB UPDATES	CTRIII	JC	DTM
9	03/20/09	15th ST. AND LOAD TEST UPDATES	CTRIII	JC	DTM
8	03/06/09	BUTLER CABLES ADDED	CTRIII	JC	DTM
7	01/13/09	ADDED GENERATOR AT PINE	CTRIII	JC	DTM
6	08/11/08	ADDED 36th AND 37th	CTRIII	JC	AFR

SCALE: N.T.S.  
 DRAWN BY: CTRIII  
 DATE: 12/26/07  
 CHECKED BY: JC

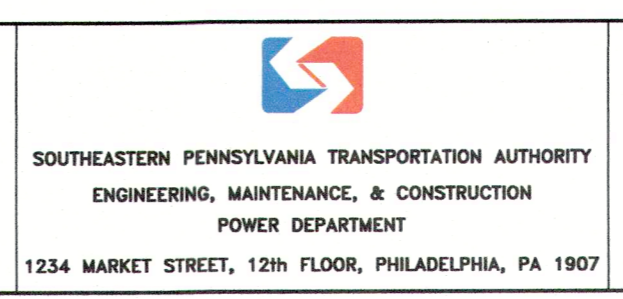

ORANGE, BLUE, AND GREEN LINE SUBWAYS  
 CITY TRANSIT DIVISION  
 630V DC EMERGENCY LIGHTING & POWER CABLE  
 EMERGENCY POWER GENERATION  
 ELECTRICAL  
 SINGLE LINE DIAGRAM  
 600V DC EMERGENCY DISTRIBUTION EXISTING CONDITIONS

WORK ORDER NUMBER	736-3002
DRAWING	E01 OF E01
SHEET NO.	1 OF 1
DRAWING NUMBER	
REV	